



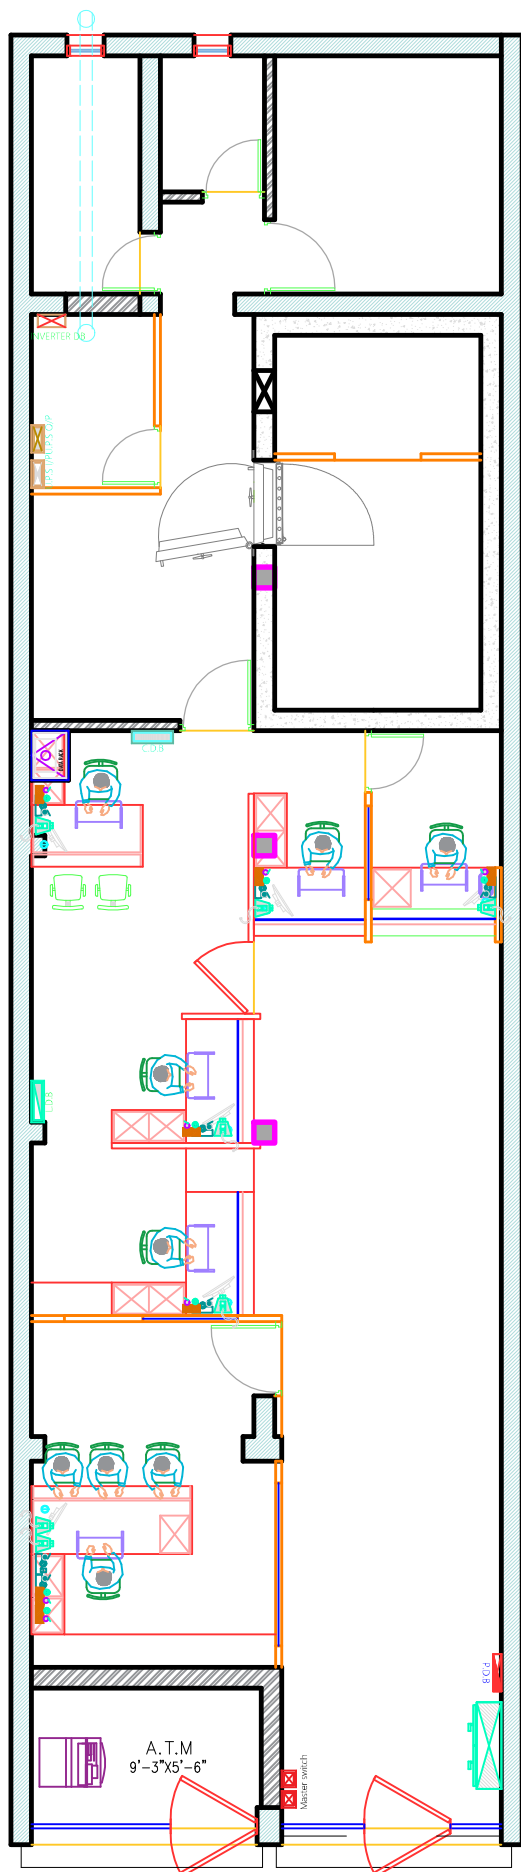

LEGEND	
MARK	DESCRIPTION
	4nos 6A SOCKET WITH 1nos 16A SWITCH
	5 NO OF 6/16A SOCKET + 2 No of 16 A SWITCH
	COMPUTER TERMINAL (CAT 6 I.O BOX)
	TELEPHONE TERMINAL (CAT 6 I.O BOX)
	MAIN PANEL BOARD
	L.D.B
	P.D.B
	C.D.B
	U.P.S INPUT & U.P.S OUTPUT
	INVERTER DB
	A.C & LIGHT MASTER SWITCHES
	6 A SOCKET WITH 6 A SWITCH. IN SEPARATE BOARD
	16 A SOCKET WITH 16A SWITCH. IN SEPARATE BOARD
	SWICH BOARD WITH 5A. SOCKET
	SWICH BOARD
	DATA RACK

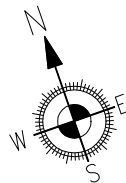

ELECTRICAL LAYOUT PLAN

Clint Name. INDIAN BANK	Drg. Title. ELECTRICAL LAYOUT PLAN(DATA)	Rev. No.	Drg. No. 1	 Plot No.- 7/7, Jadupur, Near Ranasinghpur Moo Bus stand. Bhubaneswar Ph. 0674-2551479 Mobile. 9437189632
Location. BHANJANAGAR			Drawn by. SSA	
			Date. 22/04/2026	