


Indian Bank Residential Building At Mylapore

Indian Bank

Mylapore



KEY PLAN

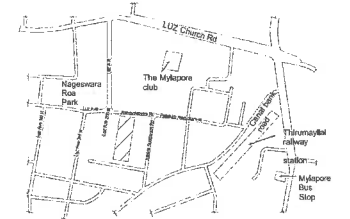

LEGEND

- SERVICES
- BUILDING PROFILE ABOVE
- SECURITY CABIN
- EPDM FLOORING
- TREES TO BE RETAINED
- RED TREES-TREES TO BE REMOVED
- TREES TO BE TRANSPLANTED
- PLANTING AS PER SPECIFICATION

NOTES

- ALL DIMENSIONS ARE IN M.
- THIS DRAWING IS TO BE READ AND NOT SCALED.
- THE DRAWING IS A COPYRIGHT AND PROPERTY OF THE ARCHITECT. IS NOT TO BE PRODUCED, HARDED OVER TO THIRD PARTY OR USED FOR ANY OTHER USE WITHOUT THE WRITTEN PERMISSION OF THE ARCHITECT.

REVISION SCHEDULE

Rev No.	Date	Revisions	Rev by.
00	04/07/2023	Revised as per client comments	DD

STRUCTURAL CONSULTANT

UNIVERSAL CONSULTANTS
New No.2/4, First Cross Street, India Nagar,
Chennai - 600 020

MEP CONSULTANT

AIR TREATMENT ENGINEERING PVT. LTD.
L-6, 2nd WEST STREET, RAMARAJ
NAGAR, THIRUVANMIYUR, CHENNAI-600
041, PHONE: +91 - 44 - 2441 2536, 2445 4891
FAX: +91 - 44 - 2445 4306

Proj.No. : 2214
Scale : As Indicated
Date : 04/07/2023
Rev.No. : R0
Drawn by : DD
Checked by : SS

LA-350



TENDER DRAWINGS- ARCHITECTURAL

LANDSCAPE GENERAL ARRANGEMENT PLAN

shilpa
ARCHITECTS PLANNERS DESIGNERS PVT. LTD.

"The Muse"
120, Dr. VSI Estate, Thiruvanniyur, Chennai 600 041.
Phone : 044 24542162 / 43358531 / 42696536
Email : studio@shilpaarchitects.com
Web site : www.shilpaarchitects.com

EXISTING NO OF TREES	TREES TO BE REMOVED	TRANSPLANTED
88	27	2

1 STILT LANDSCAPE
1:200


Indian Bank Residential Building At Mylapore

Indian Bank

Mylapore



KEY PLAN

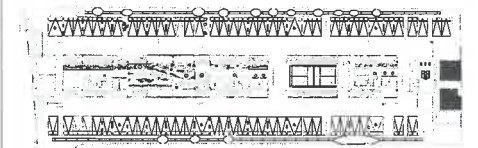

LEGEND

F.S. - FINISHED SURFACE LEVEL
F.G. - FINISHED GRADE LEVEL

NOTES

1. ALL DIMENSIONS ARE IN M.
2. THIS DRAWING IS TO BE READ AND NOT SCALED.
3. THIS DRAWING IS A COPYRIGHT AND PROPERTY OF THE ARCHITECT. IS NOT TO BE PRODUCED, HANDED OVER TO THIRD PARTY OR USED FOR ANY OTHER PURPOSE OTHER THAN FOR WHICH IT IS INTENDED.

REVISION SCHEDULE

Rev No.	Date	Revisions	Rev by.

STRUCTURAL CONSULTANT

UNIVERSAL CONSULTANTS
New No. 2/4, First Cross Street, Indira Nagar,
Chennai - 600 020

ELECTRICAL CONSULTANT

AIR TREATMENT ENGINEERING PVT. LTD.,
L-6, 2nd WEST STREET, KAMARAJ
NAGAR, THIRUVANMIYUR, CHENNAI-600
041. PHONE: +91 - 44 - 2441 2536, 2445 4891
FAX: +91 - 44 - 2445 4306

PLUMBING CONSULTANT

AIR TREATMENT ENGINEERING PVT. LTD.,
L-6, 2nd WEST STREET, KAMARAJ
NAGAR, THIRUVANMIYUR, CHENNAI-600
041. PHONE: +91 - 44 - 2441 2536, 2445 4891
FAX: +91 - 44 - 2445 4306

Proj. No. : 2021-0012

Scale : AS SHOWN

Date : 04-07-2023

Rev. No. : R0

Drawn by : JD

Checked by :

LA-352




TYPICAL LANDSCAPE SECTIONS AND DETAIL

DETAILED DESIGN

shilpa


ARCHITECTS PLANNERS DESIGNERS PVT. LTD.

"The Muse"
L20, Dr. VSI Estate, Thiruvanniyur, Chennai 600 041.
Phone : 044 24542162 / 43358531 / 42696536
Email : studio@shilpaarchitects.com
Web site : www.shilpaarchitects.com

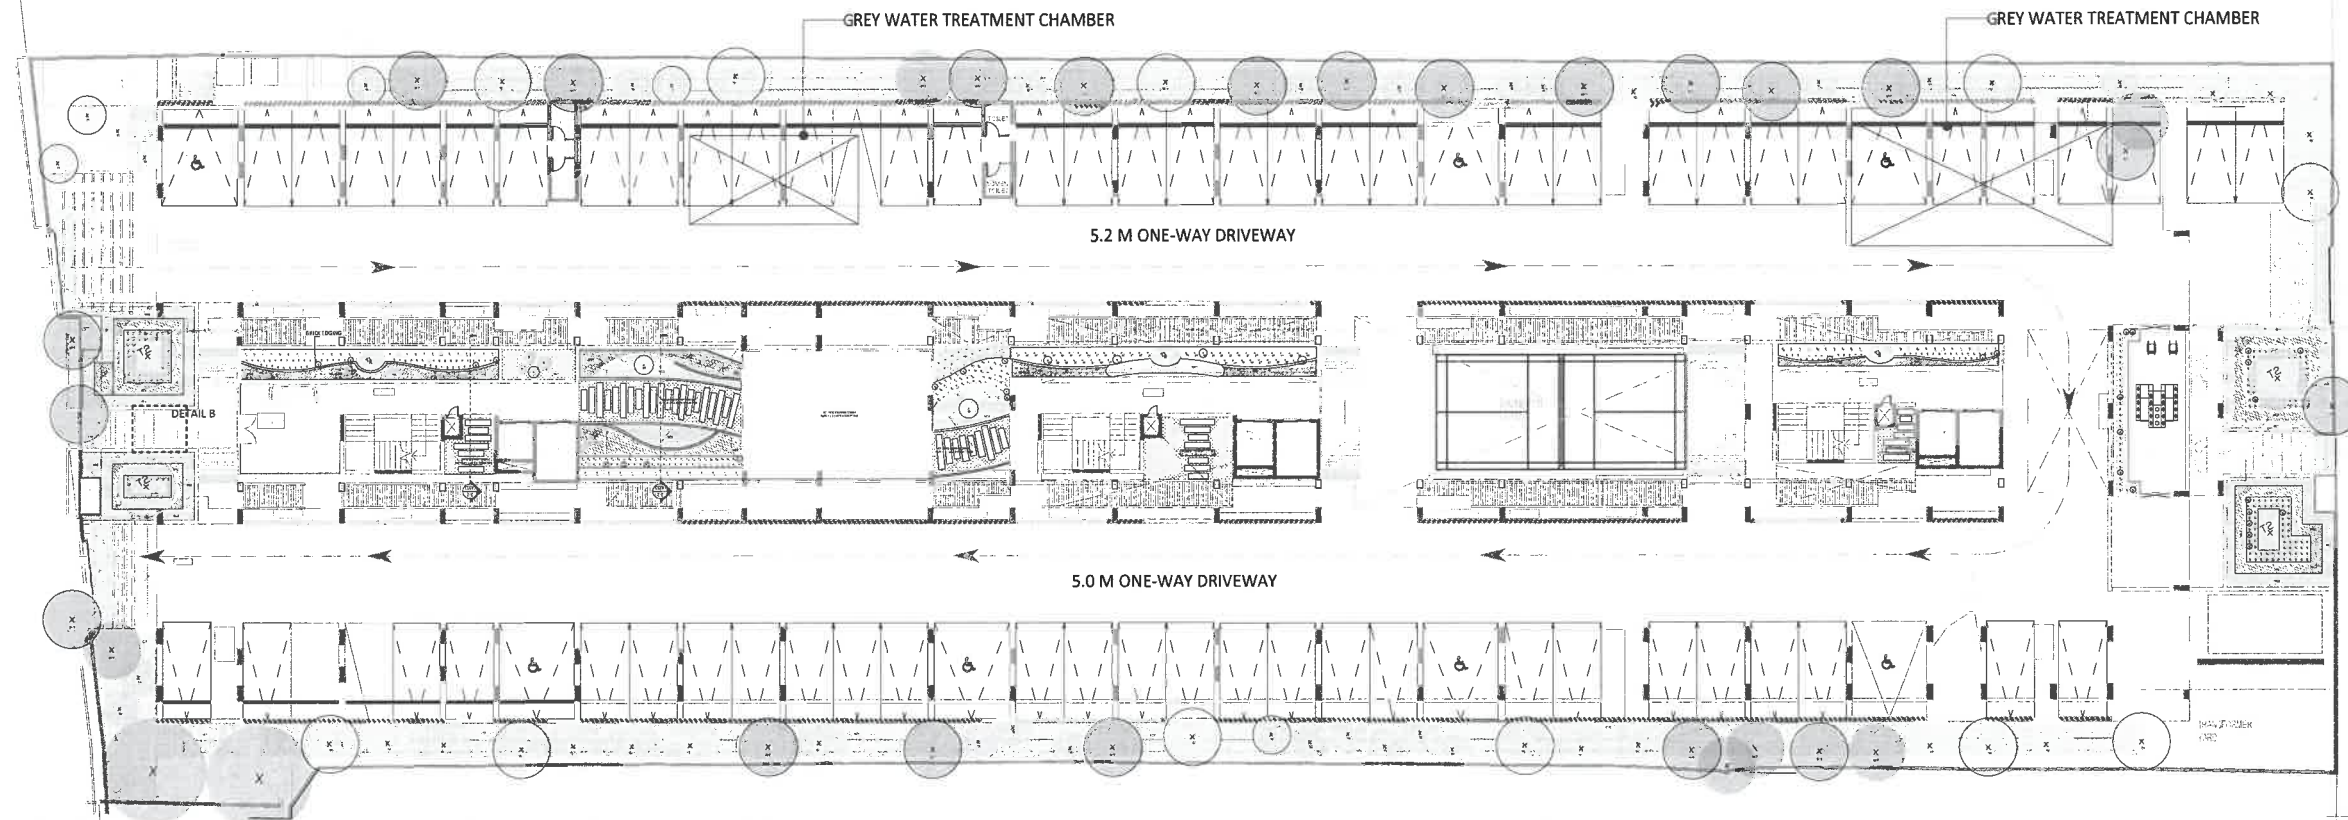


01 BOUNDARY/PERIPHERAL PLANTING

1:200

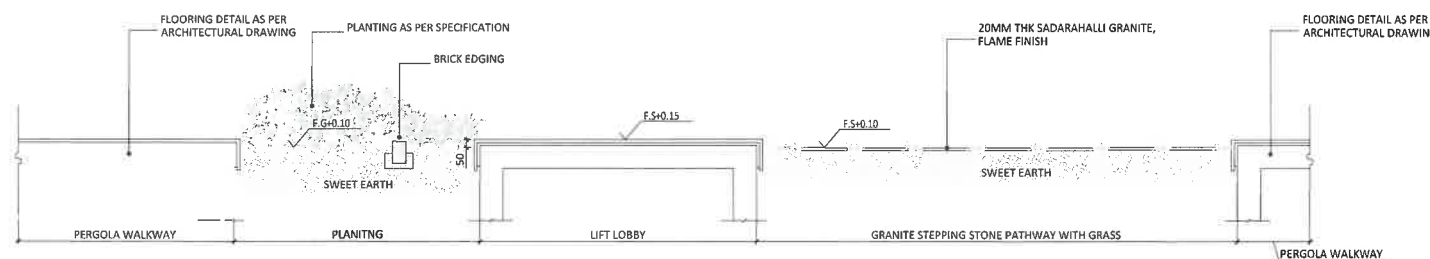

02 TYPICAL DETAIL - SECTION 1-1

1:25


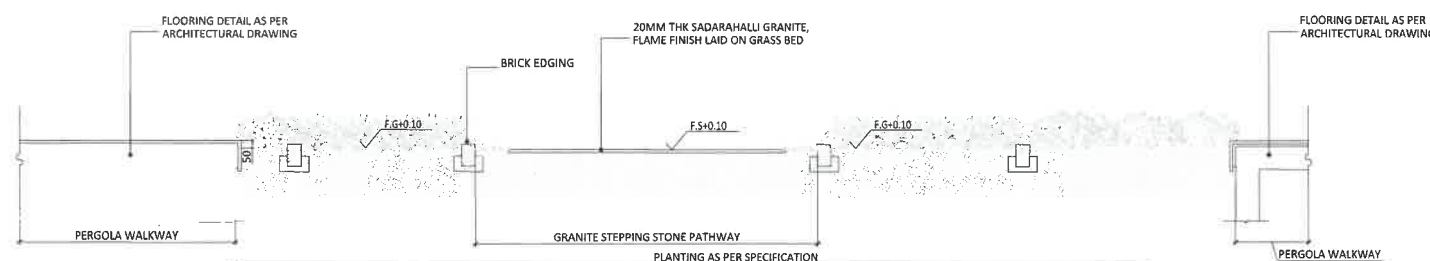


02 TYPICAL DETAIL - SECTION 2-2

1:25

03 TYPICAL DETAIL A - BRICK EDGING - ELEVATION AND SECTION

1:25

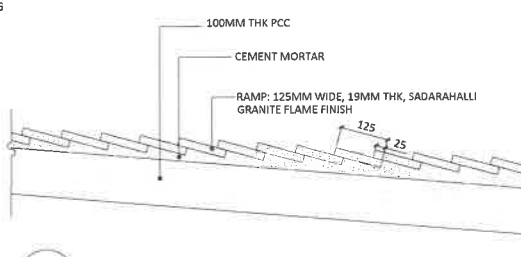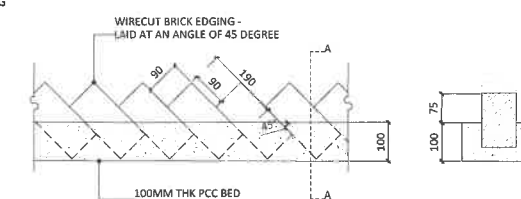

04 TYPICAL DETAIL B - RAMP GRANITE LAYING DETAIL

1:10


Indian Bank Residential Building At Mylapore

Indian Bank

Mylapore



KEY PLAN

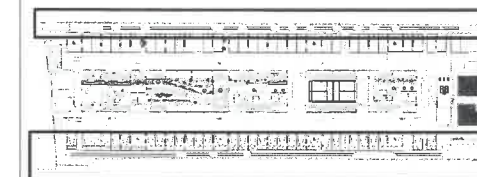

LEGEND

NOTES

- ALL DIMENSION ARE IN M.
- THIS DRAWING IS TO BE READ AND NOT SCALED.
- THIS DRAWING IS A COPYRIGHT AND PROPERTY OF THE ARCHITECT. IT IS NOT TO BE PRODUCED, HANDLED OVER TO THIRD PARTY OR USED FOR ANY OTHER PURPOSE OTHER THAN FOR WHICH IT IS INTENDED.

REVISION SCHEDULE

Rev No.	Date	Revisions	Rev by.

STRUCTURAL CONSULTANT

UNIVERSAL CONSULTANTS
New No.2/4, First Cross Street, Indira Nagar,
Chennai - 600 020

ELECTRICAL CONSULTANT

AIR TREATMENT ENGINEERING PVT. LTD.
L-6, 2nd WEST STREET, KAMARAJ
NAGAR, THIRUVANMIYUR, CHENNAI-600
041. PHONE: +91 - 44 - 2441 2536, 2445 4891
FAX: +91 - 44 - 2445 4306

PLUMBING CONSULTANT

AIR TREATMENT ENGINEERING PVT. LTD.
L-6, 2nd WEST STREET, KAMARAJ
NAGAR, THIRUVANMIYUR, CHENNAI-600
041. PHONE: +91 - 44 - 2441 2536, 2445 4891
FAX: +91 - 44 - 2445 4306

Proj.No. : 2021-0012
Scale : AS SHOWN
Date : 26-06-2023
Rev.No. : R1
Drawn by : JD
Checked by :

LA-351
5 of 5




PLANTING PLAN

DETAILED DESIGN

shilpa
ARCHITECTS PLANNERS DESIGNERS PVT. LTD.

"The Muse"
L20, Dr. VSI Estate, Thiruvanniyur, Chennai 600 041.
Phone : 044 24542162 / 43358531 / 42696536
Email : studio@shilpaarchitects.com
Web site : www.shilpaarchitects.com

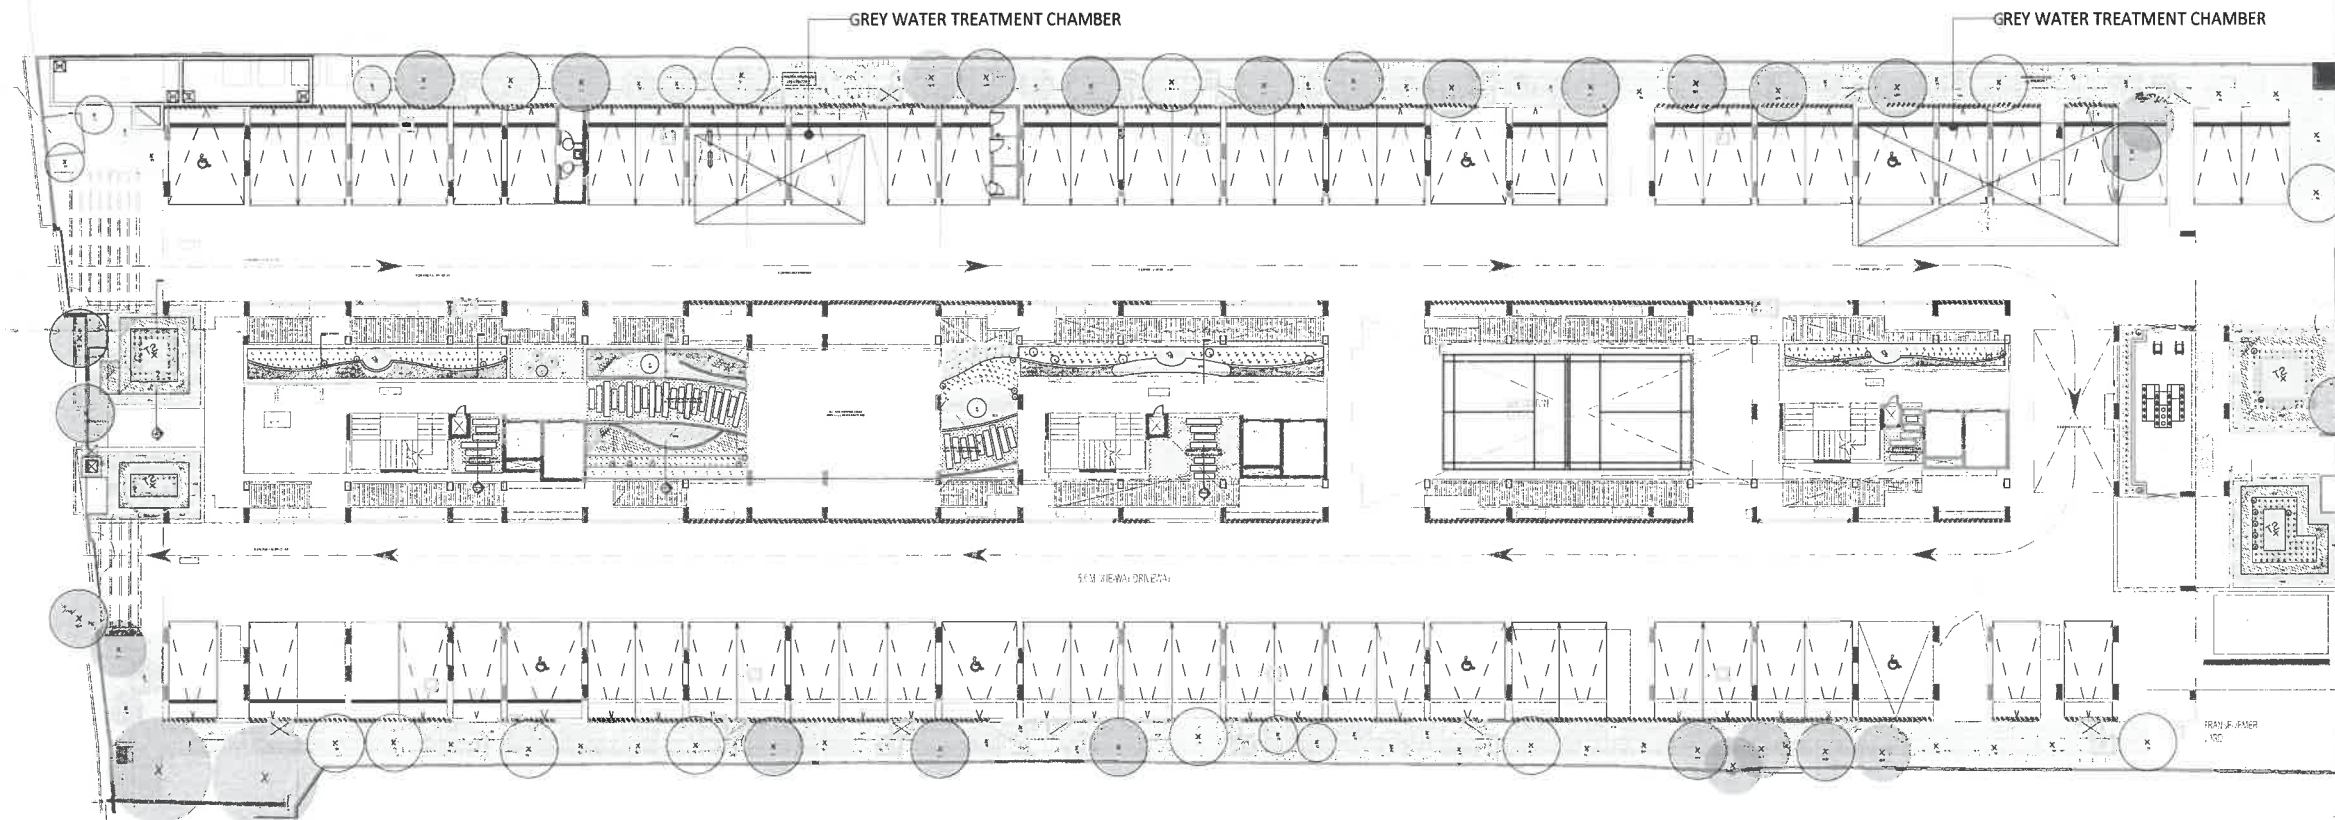

01 BOUNDARY/PERIPHERAL PLANTING

PLANTING PALETTE - PHERIPHERY

SL.NO	REF NO	LEGEND	BOTANIC NAME	COMMON NAME	QUANTITY	UNITS	SPACING	REF IMAGE	SPECIFICATION
1	T3		LAGERSTROEMIA FLOS REGINAE	CRABE MYRTLE TREE	27	NOS	3000mm		6' - 10' height, 3" - 4" girth, 4' spread
2	T4		CASSIA FISTULA	GOLDEN SHOWER	12	NOS	3000mm		7' - 10' height, 2" - 3" girth, 2'6" - 3' spread
3	T5		SARACA INDICA	ASHOKA TREE	13	NOS	3000mm		7' - 10' height, 3" girth, 3' spread
4	T6		DILLENIA INDICA	ELEPHANT APPLE	02	NOS	5500mm		6' * 10' height, 4" girth, 3' - 4' spread
5	T7		EXISTING TREE SPECIES		27	NOS			
GROUND COVERS	1		OPHIPOGON JABURAN	OPHIPOGON VARIEGATED	404	SQ.M			Carpet Effect

02 BOUNDARY/PERIPHERAL - PLANTING PALETTE

SL.NO	REF NO	BOTANIC NAME	COMMON NAME
1	GC1	FITTONIA VERSCHAFFELTII	NERVE PLANT
2	GC2	OPHIPOGON VARIEGATED	VARIGATED LEAF MONDO GRASS
3	GC3	STENOTAPHRUM SECUNDATUM	AUGUSTINE GRASS
4	GC4	SETCREASEA PURPUREA	PURPLE HEART
5	GC5	OPHIPOGON JABURAN	OPHIPOGON VARIEGATED
1	S1	ALPINIA ZERUMBET	SHELL GINGER
2	S2	RHAPIS EXCELSA	LADY PALM
3	S3	MONSTERA DELICIOSA	SPLIT-LEAF PHILODENDRON
4	S4	ANTHURIUM ANDREANUM	TAIL FLOWER
5	S5	BAMBOO DWARF VARIGATED	BAMBOO VARIEGATED
6	S6	FICUS BENJAMINA	WEeping FIG
7	S7	FICUS REGINOLD	WEeping FIG
8	S8	DURANTA GOLDII	GOLDEN DURANTA
9	S9	BELOPRONE AMHERSTAE GUTTATA	SHRIMP PLANT
10	S10	BAMBUSA VENTRICOSA	BUDDHA BELLY BAMBOO
1	T1	LICUALA GRANDIS	FAN PALM
2	T2	'PLUMERIA HYBRID PINK	HYBRID PINK FLOWER
3	T3	LAGERSTROEMIA FLOS REGINAE	CRABE MYRTLE TREE
4	T4	CASSIA FISTULA	GOLDEN SHOWER
5	T5	SARACA INDICA	ASHOKA TREE
6	T6	DILLENIA INDICA	ELEPHANT APPLE
7	T7	EXISTING TREE SPECIES	

03 LIST OF SPECIES PROPOSED


Indian Bank Residential
Building At Mylapore

Indian Bank

Mylapore



KEY PLAN

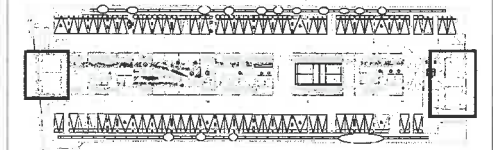

LEGEND

NOTES	REVISION SCHEDULE			
	Rev No.	Date	Revisors	Rev by.
1. ALL DIMENSION ARE IN M. 2. THIS DRAWING IS TO BE READ AND NOT SCALED. 3. THIS DRAWING IS A COPYRIGHT AND PROPERTY OF THE ARCHITECT, IS NOT TO BE PRODUCED, HANDED OVER TO THIRD PARTY OR USED FOR ANY OTHER PURPOSE OTHER THAN FOR WHICH IT IS INTENDED.				


STRUCTURAL CONSULTANT	ELECTRICAL CONSULTANT
UNIVERSAL CONSULTANTS New No.224, First Cross Street, Indira Nagar, Chennai - 600 020	AIR TREATMENT ENGINEERING PVT. LTD. L-6, 2nd WEST STREET, KAMARAJ NAGAR, THIRUVANMIYUR, CHENNAI-600 041,PHONE:+91 - 44 - 2441 2536, 2445 4891 FAX: +91 - 44 - 2445 4306

PLUMBING CONSULTANT
AIR TREATMENT ENGINEERING PVT. LTD., L-6, 2nd WEST STREET, KAMARAJ NAGAR, THIRUVANMIYUR, CHENNAI-600 041,PHONE:+91 - 44 - 2441 2536, 2445 4891 FAX: +91 - 44 - 2445 4306


Proj.No. : 2021-0012	LA-351 4 of 5
Scale : AS SHOWN	
Date : 26-06-2023	
Rev.No. : R1	
Drawn by : JD	
Checked by :	

PLANTING PLAN

DETAILED DESIGN

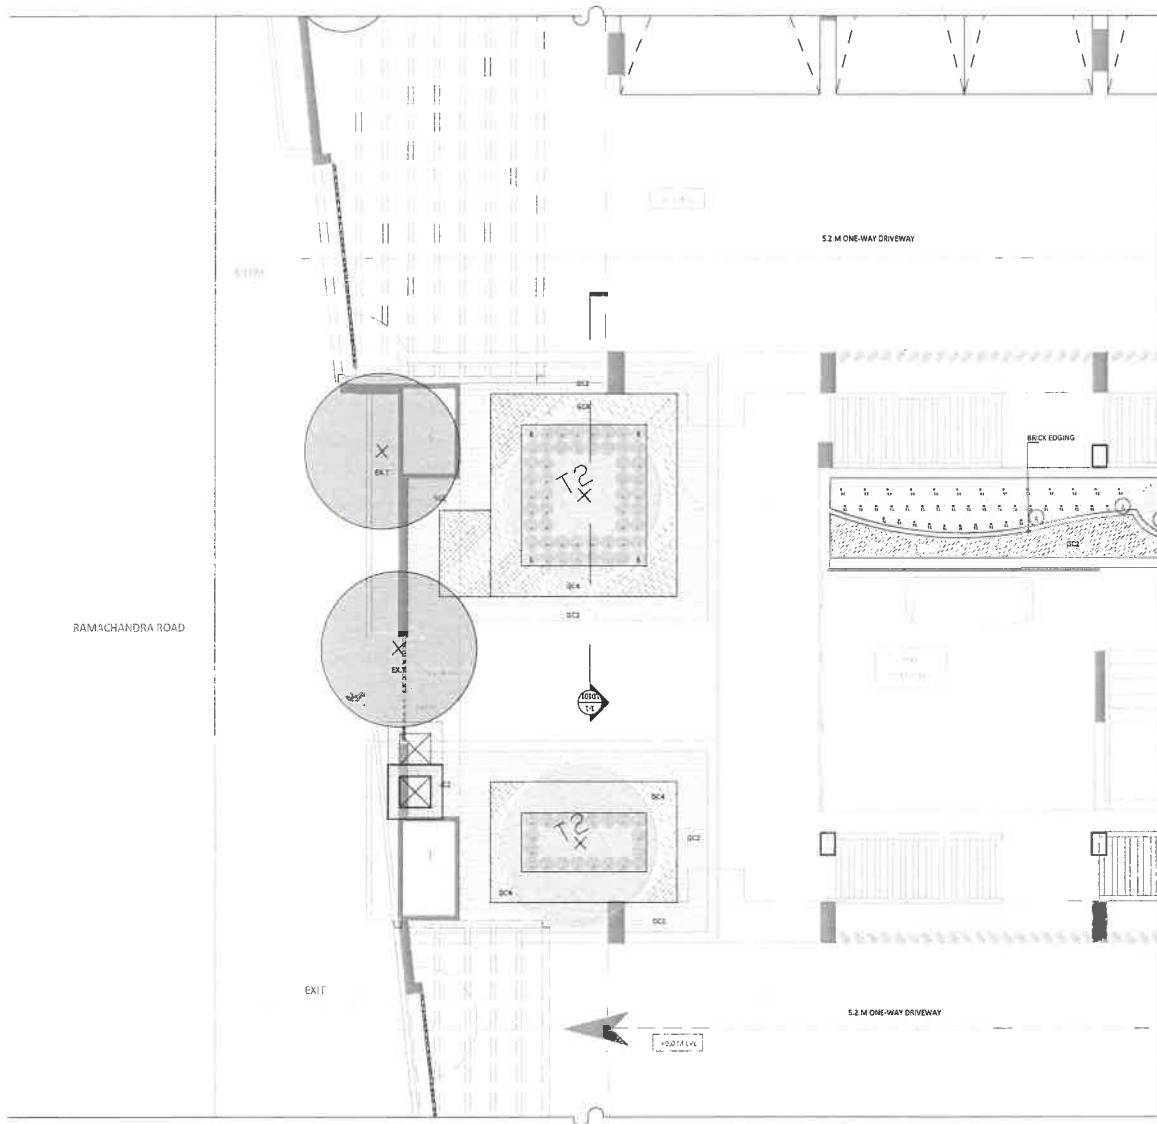

01 ENTRY/EXIT
1:50

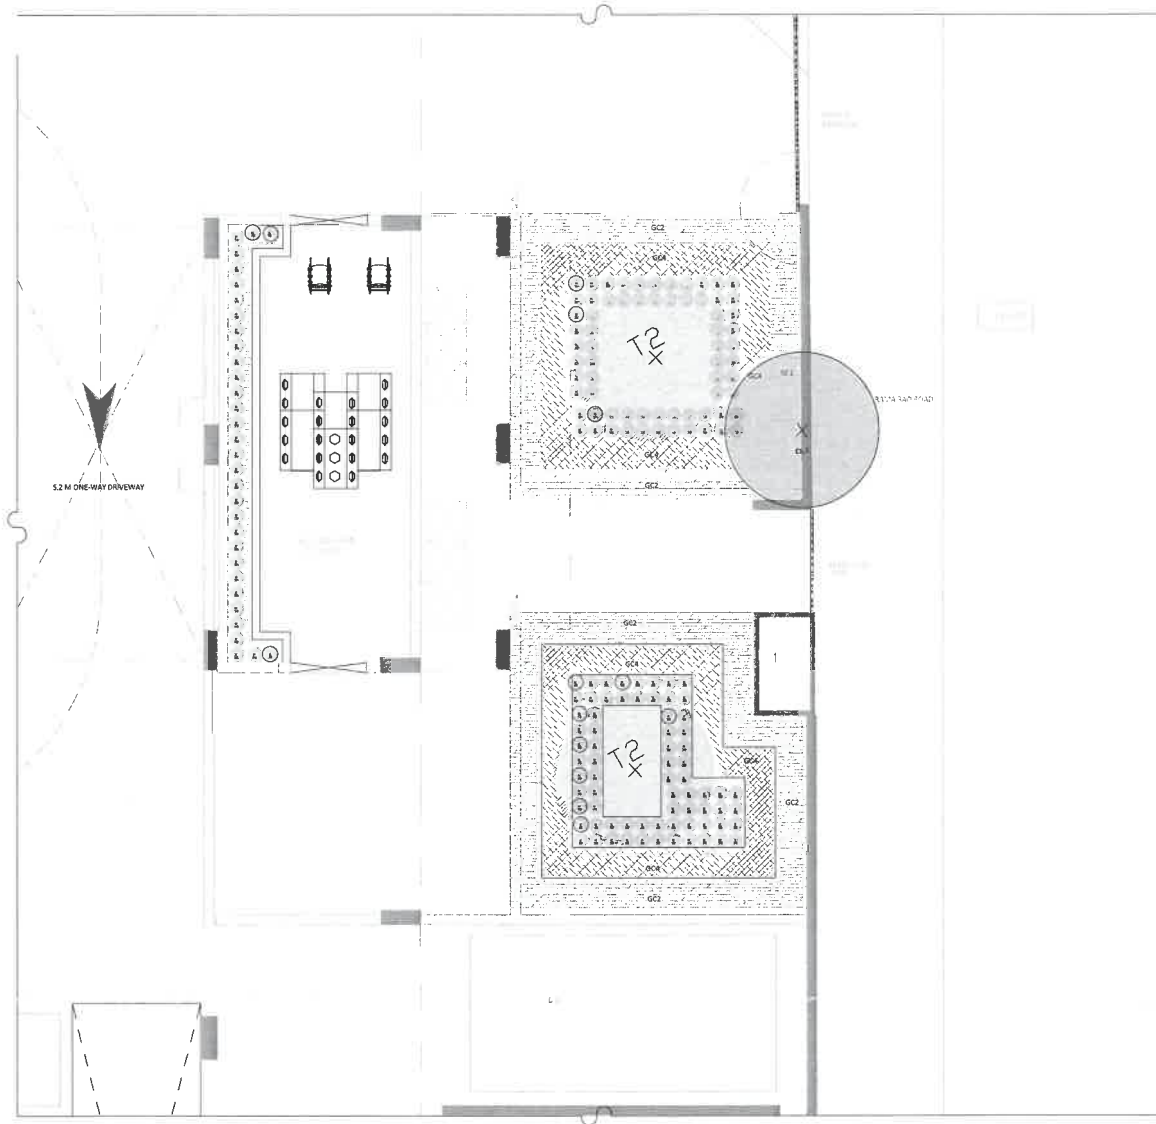

02 ENTRY/EXIT
1:50

PLANTING PALETTE

	SL.NO	REF NO	LEGEND	BOTANIC NAME	COMMON NAME	QUANTITY	UNITS	SPACING	REF IMAGE	SPECIFICATION
GROUND COVERS	1	GC2		OPHIPOGON VARIEGATED	VARIGATED LEAF MONDO GRASS	28.5	SQ.M	-		Carpet Effect
	2	GC4		SETCREASEA PURPUREA	PURPLE HEART	34	SQ.M	-		Carpet Effect
SHRUBS	3	S8		DURANTA GOLDII	GOLDEN DURANTA	245	NOS	300mm		1' height, 6"-8"spread, bushy, kept as box hedge
TREE	5	T2		'PLUMERIA HYBRID PINK	HYBRID PINK FLOWER	4	NOS	-		10'-12' height, well developed non drooping 4'-5' crown spread


03 PLANTING PALETTE - ENTRY/EXIT
1:50

Indian Bank Residential
Building At Mylapore

Indian Bank
Mylapore



KEY PLAN

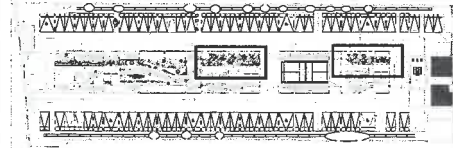

LEGEND

NOTES

1. ALL DIMENSION ARE IN M.
2. THIS DRAWING IS TO BE READ AND NOT SCALED.
3. THIS DRAWING IS A COPYRIGHT AND PROPERTY OF THE ARCHITECT. IS NOT TO BE PRODUCED, HANDED OVER TO THIRD PARTY OR USED FOR ANY OTHER PURPOSE OTHER THAN FOR WHICH IT IS INTENDED.

REVISION SCHEDULE		Rev No.	Date	Revisions	Rev by.
STRUCTURAL CONSULTANT					
ELECTRICAL CONSULTANT					

UNIVERSAL CONSULTANTS
New No.274, First Cross Street, Indira Nagar,
Chennai - 600 022

AIR TREATMENT ENGINEERING PVT. LTD.
L-6, 2nd WEST STREET, KAMARAJ
NAGAR, THIRUVANMIYUR, CHENNAI-600
041.PHONE:+91 - 44 - 2441 2536, 2445 4891
FAX: +91 - 44 - 2445 4306

Proj.No. : 2021-0012
Scale : AS SHOWN
Date : 26-06-2023
Rev.No. : R1
Drawn by : JD
Checked by :

LA-351
3 of 5




PLANTING PLAN

DETAILED DESIGN

shilpa
ARCHITECTS PLANNERS DESIGNERS PVT. LTD.

"The Muse"
L20, Dr. VSI Estate, Thiruvanniyur, Chennai 600 041.
Phone : 044 24542162 / 43358531 / 42696536
Email : studio@shilpaarchitects.com
Web site : www.shilpaarchitects.com

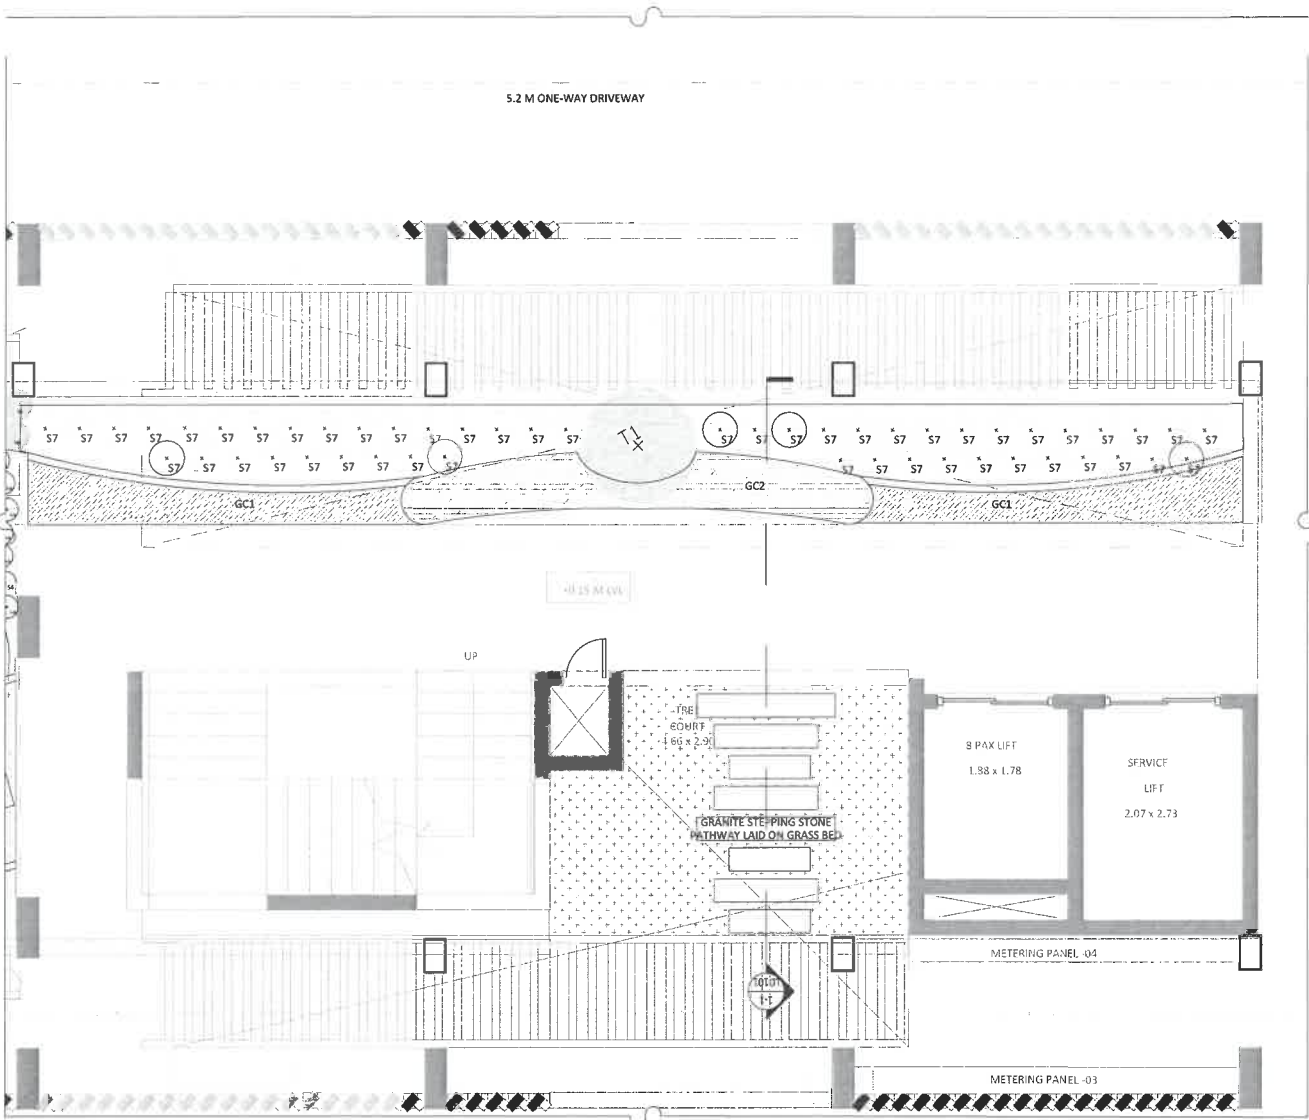


01 BLOCK A-3
1:50

PLANTING PALETTE

	SL.NO	REF NO	LEGEND	BOTANIC NAME	COMMON NAME	QUANTITY	UNITS	SPACING	REF IMAGE	SPECIFICATION
GROUND COVERS	1	GC2		OPHIPOGON VARIEGATED	VARIGATED LEAF MONDO GRASS	4	SQ.M			Carpet Effect
	2	GC1		FITTONIA VERSCHAFFELTII	NERVE PLANT	6	SQ.M			Carpet Effect
	3	GC3		STENOTAPHRUM SECUNDATUM	AUGUSTINE GRASS	10.7	SQ.M			Carpet Effect
SHRUBS	4	S7		FICUS REGINOLD	WEEPING FIG	51	SQ.M	400mm		
TREE	5	T1		LANTANIA LONTAROIDES	RED PALM	1	NOS			Low watering, Water only when soils get dried.

02 PLANTING PALETTE - BLOCK A-3
1:50

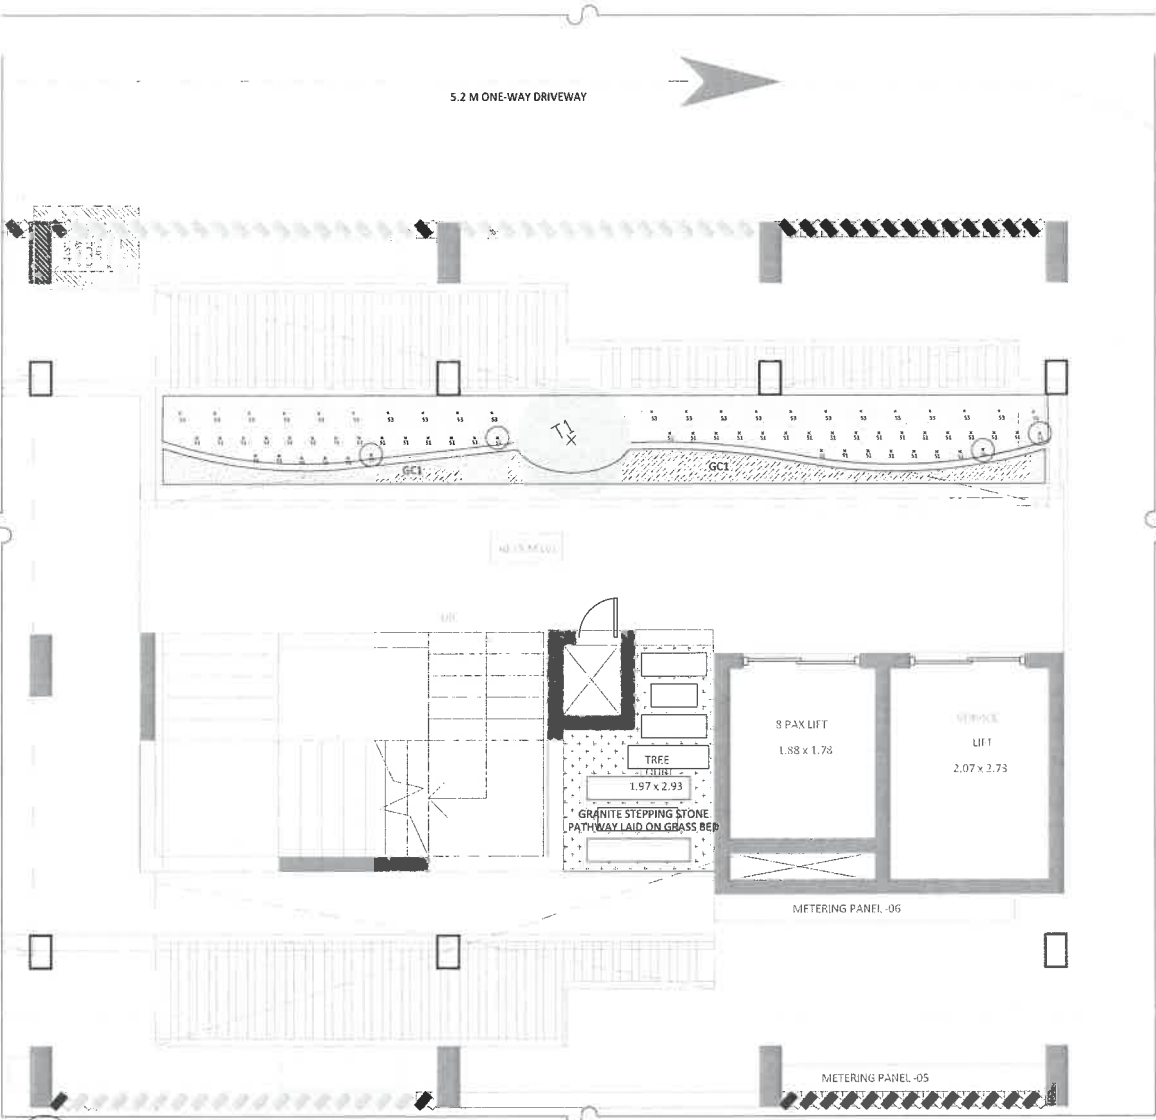

03 BLOCK B
1:50

PLANTING PALETTE

	SL.NO	REF NO	LEGEND	BOTANIC NAME	COMMON NAME	QUANTITY	UNITS	SPACING	REF IMAGE	SPECIFICATION
GROUND COVERS	1	GC1		FITTONIA VERSCHAFFELTII	NERVE PLANT	4.5	SQ.M			Carpet Effect
	2	GC2		OPHIPOGON VARIEGATED	VARIGATED LEAF MONDO GRASS	1	SQ.M			Carpet Effect
	3	GC3		STENOTAPHRUM SECUNDATUM	AUGUSTINE GRASS	2.6	SQ.M			Carpet Effect
SHRUBS	4	S1		ALPINIA ZERUMBET	SHELL GINGER	47	NOS	300mm		3' high, prefers shade
	5	S3		MONSTERA DELICIOSA	SPLIT-LEAF PHILODENDRON	23	NOS	400mm		3-15 ft. tall, 3-8 ft. wide Well-drained soil
TREE	6	T1		LANTANIA LONTAROIDES	RED PALM	1	NOS			Low watering, Water only when soils get dried.

04 PLANTING PALETTE - BLOCK B
1:50


Indian Bank Residential
Building At Mylapore

Indian Bank

Mylapore



KEY PLAN

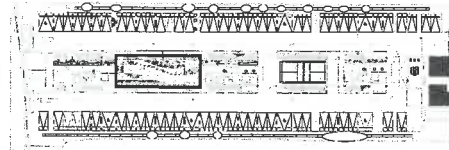

LEGEND

NOTES

1. ALL DIMENSION ARE IN M.
2. THIS DRAWING IS TO BE READ AND NOT SCALED.
3. THIS DRAWING IS A COPYRIGHT AND PROPERTY OF THE ARCHITECT, IS NOT TO BE PRODUCED, HANDED OVER TO THIRD PARTY OR USED FOR ANY OTHER PURPOSE OTHER THAN FOR WHICH IT IS INTENDED.

REVISION SCHEDULE

Rev No.	Date	Revisions	Rev by.

STRUCTURAL CONSULTANT

UNIVERSAL CONSULTANTS
New No.24, First Cross Street, Indira Nagar,
Chennai - 600 020

ELECTRICAL CONSULTANT

AIR TREATMENT ENGINEERING PVT. LTD.,
L-6, 2nd WEST STREET, KAMARAJ
NAGAR, THIRUVANMIYUR, CHENNAI-600
041.PHONE:+91 - 44 - 2441 2536, 2445 4891
FAX: +91 - 44 - 2445 4305

PLUMBING CONSULTANT

AIR TREATMENT ENGINEERING PVT. LTD.,
L-6, 2nd WEST STREET, KAMARAJ
NAGAR, THIRUVANMIYUR, CHENNAI-600
041.PHONE:+91 - 44 - 2441 2536, 2445 4891
FAX: +91 - 44 - 2445 4305

Proj.No. : 2021-0012
Scale : AS SHOWN
Date : 26-06-2023
Rev.No. : R1
Drawn by : JD
Checked by :

LA-351
2 of 5




PLANTING PLAN

DETAILED DESIGN

shilpa

ARCHITECTS PLANNERS DESIGNERS PVT. LTD.

"The Muse"
L20, Dr. VSI Estate, Thiruvanniyur, Chennai 600 041.
Phone : 044 24542162 / 43358531 / 42696536
Email : studio@shilpaarchitects.com
Web site : www.shilpaarchitects.com

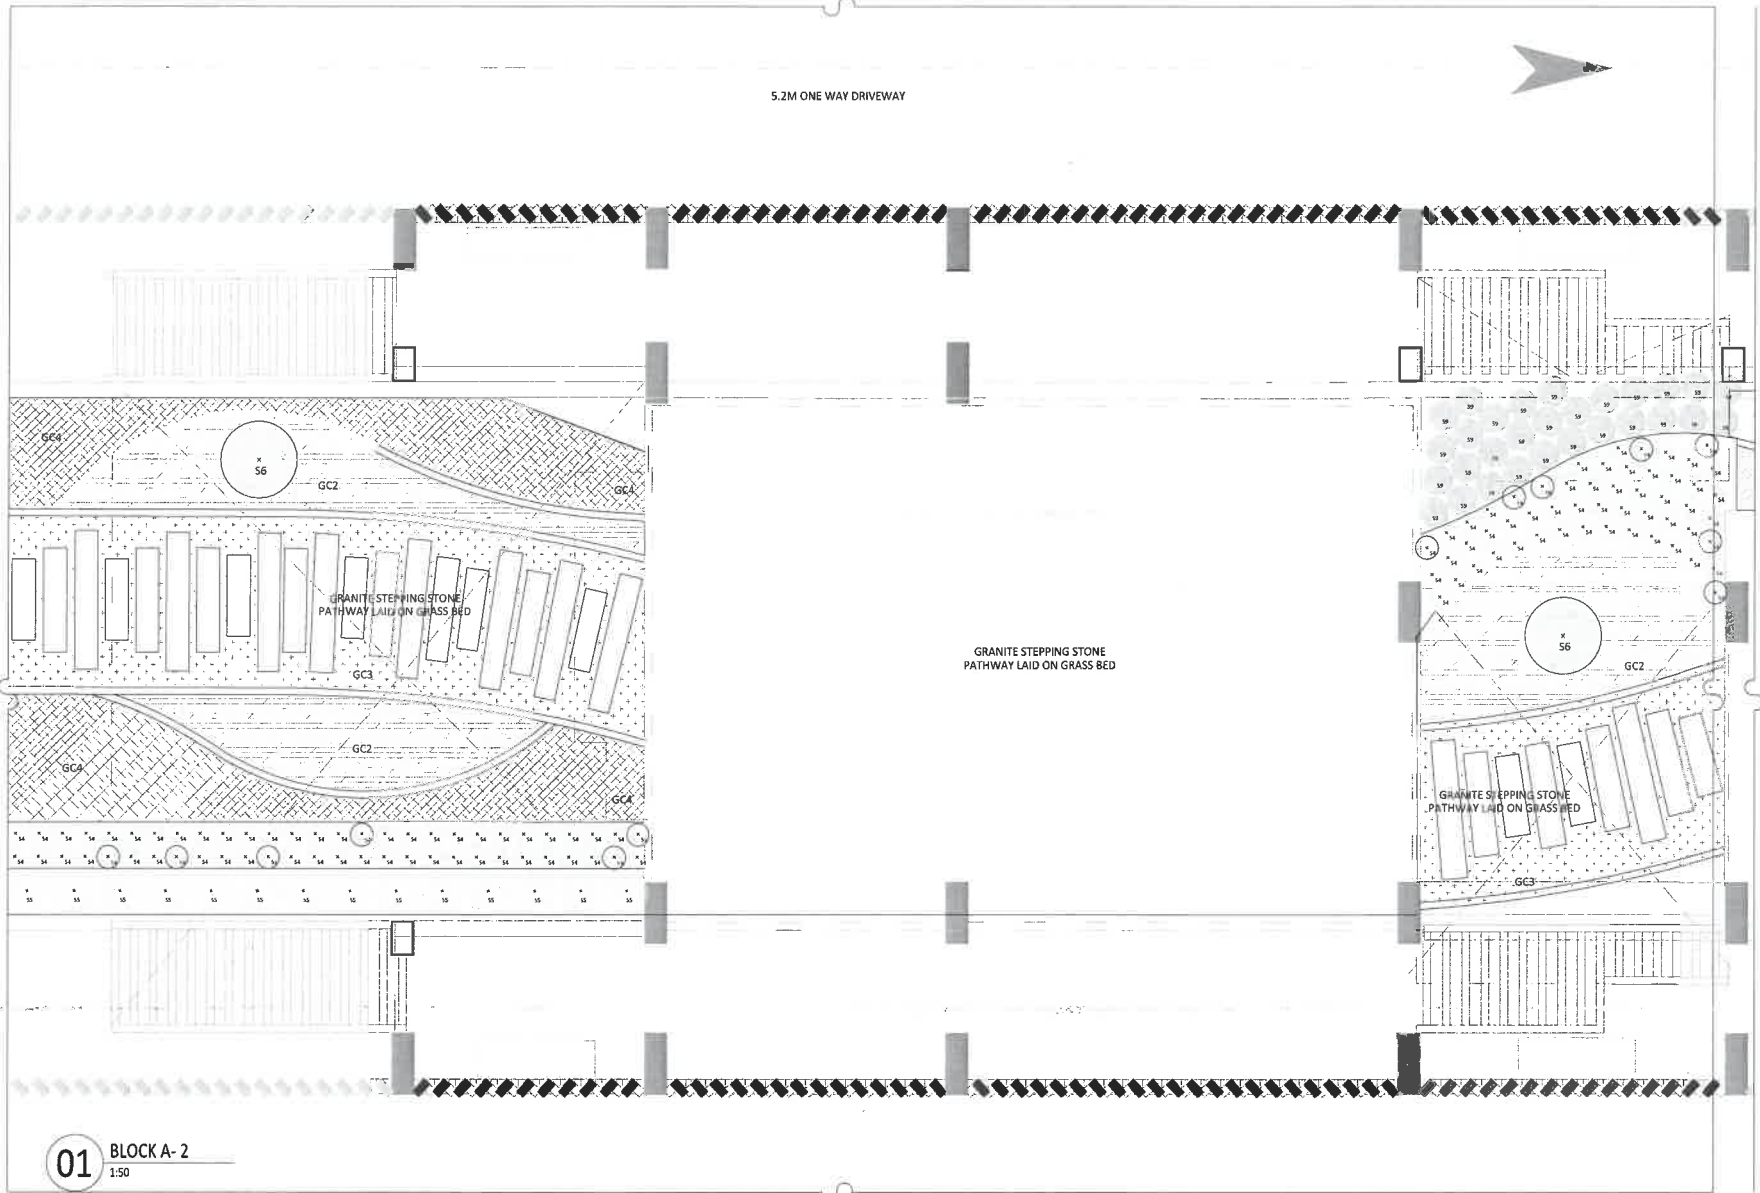

01 BLOCK A-2
1:50

PLANTING PALETTE

	SL.NO	REF NO	LEGEND	BOTANIC NAME	COMMON NAME	QUANTITY	UNITS	SPACING	REF IMAGE	SPECIFICATION
GROUND COVERS	1	GC2		OPHIPOGON VARIEGATED	VARIATED LEAF MONDO GRASS	17	SQ.M	-		Carpet Effect
	2	GC5		SETCREASEA PURPUREA	PURPLE HEART	15	SQ.M	-		Carpet Effect
	3	GC3		STENOTAPHRUM SECUNDATUM	AUGUSTINE GRASS	12	SQ.M	-		Carpet Effect
SHRUBS	4	S4		ANTHURIUM ANDREANUM	TAIL FLOWER	111	NOS	300mm		prefers shade, porous compact soil
	5	S5		BAMBOO DWARF VARIGATED	BAMBOO VARIEGATED	14	NOS	600mm		2'6" - 3' height, 18" spread, kept as round hedge
	6	S6		FICUS BENJAMINA	WEEPING FIG	02	NOS	1000mm		3'-4' height, 2'-6" spread bushy
	6	S9		BELOPRONE AMHERSTAE GUTTATA	SHRIMP PLANT	30	NOS	400mm		0.6m high, well drained soil

02 PLANTING PALETTE - BLOCK A-2
1:50


Indian Bank Residential Building At Mylapore

Indian Bank

Mylapore



KEY PLAN

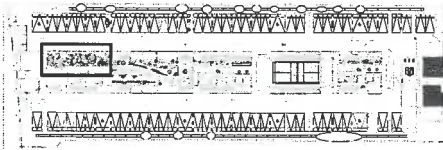

LEGEND

NOTES	REVISION SCHEDULE			
ALL DIMENSION ARE IN M. THIS DRAWING IS TO BE READ AND NOT SCALED. THIS DRAWING IS A COPYRIGHT AND PROPERTY OF THE ARCHITECT, IS NOT TO BE PRODUCED, HANDED OVER TO THIRD PARTY OR USED FOR ANY OTHER PURPOSE OTHER THAN FOR WHICH IT IS INTENDED.	Rev.No.	Date	Revisions	Rev.by.
STRUCTURAL CONSULTANT	ELECTRICAL CONSULTANT			
UNIVERSAL CONSULTANTS New No.24, First Cross Street, Indira Nagar, Chennai - 600 020		AIR TREATMENT ENGINEERING PVT. LTD. L-6, 2nd WEST STREET, KAMARAJ NAGAR, THIRUVANMIYUR, CHENNAI-600 041.PHONE: +91 - 44 - 2441 2536, 2445 4891 FAX: +91 - 44 - 2445 4306		

Proj.No.	: 2021-0012	LA-351 1 of 5
Scale	: AS SHOWN	
Date	: 26-06-2023	
Rev.No.	: R1	
Drawn by	: JD	
Checked by	:	

PLANTING PLAN

DETAILED DESIGN

shilpa

ARCHITECTS PLANNERS DESIGNERS PVT. LTD.

"The Muse"

L20, Dr. VSI Estate, Thiruvanniyur, Chennai 600 041.

Phone : 044 24542162 / 43358531 / 42696536

Email : studio@shilpaarchitects.com

Web site : www.shilpaarchitects.com

5.2 M ONE-WAY DRIVEWAY

5.2M ONE WAY DRIVEWAY

BRICK EDGING

GC1

GC1

GC3

GRANITE STEPPING STONE
PATHWAY LAID ON GRASS BED

9 PAX LIFT
1.78 x 1.78

LIFT
3.03 x 2.85

METERING PANEL -02

METERING PANEL -01

01 BLOCK A-1
1:50

PLANTING PALETTE

	SL.NO	REF NO	LEGEND	BOTANIC NAME	COMMON NAME	QUANTITY	UNITS	SPACING	REF IMAGE	SPECIFICATION
GROUND COVERS	1	GC1		FITTONIA VERSCHAFFELTII	NERVE PLANT	9	SQ.M	-		Carpet Effect
	2	GC2		OPHIPOGON VARIEGATED	VARIGATED LEAF MONDO GRASS	1.5	SQ.M	-		Carpet Effect
	3	GC3		STENOTAPHRUM SECUNDATUM	AUGUSTINE GRASS	9.7	SQ.M	-		Carpet Effect
SHRUBS	4	S1		ALPINIA ZERUMBET	SHELL GINGER	60	NOS	300mm		3' high, prefers shade
	5	S2		RHAPIS EXCELSA	LADY PALM	4	NOS	VARIES		2'- 2'6" height, 1'6" spread
	6	S3		MONSTERA DELICIOSA	SPLIT-LEAF PHILODENDRON	26	NOS	400mm		Well-drained soil
TREES	7	T1		LANTANIA LONTARIOIDES	RED PALM	1	NOS	-		Low watering, Water only when soils get dried.

02 PLANTING PALETTE - BLOCK A- 1
1:50

	SL.NO	REF NO	BOTANIC NAME	COMMON NAME
GROUND COVERS	1	GC1	FITTONIA VERSCHAFFELTII	NERVE PLANT
	2	GC2	OPHIPOGON VARIEGATED	VARIGATED LEAF MONDO GRASS
	3	GC3	STENOTAPHRUM SECUNDATUM	AUGUSTINE GRASS
	4	GC4	SETCREASEA PURPUREA	PURPLE HEART
	5	GC5	OPHIPOGON JABURAN	OPHIPOGON VARIEGATED
SHRUBS	1	S1	ALPINIA ZERUMBET	SHELL GINGER
	2	S2	RHAPIS EXCELSA	LADY PALM
	3	S3	MONSTERA DELICIOSA	SPLIT-LEAF PHILODENDRON
	4	S4	ANTHURIUM ANDREANUM	TAIL FLOWER
	5	S5	BAMBOO DWARF VARIGATED	BAMBOO VARIEGATED
	6	S6	FICUS BENJAMINA	WEEPING FIG
	7	S7	FICUS REGINOLD	WEEPING FIG
	8	S8	DURANTA GOLDII	GOLDEN DURANTA
	9	S9	BELOPRONE AMHERSTIAE GUTTATA	SHRIMP PLANT
	10	S10	BAMBUSA VENTRICOSA	BUDDHA BELLY BAMBOO
TREES	1	T1	LICUALA GRANDIS	FAN PALM
	2	T2	'PLUMERIA HYBRID PINK	HYBRID PINK FLOWER
	3	T3	LAGERSTROEMIA FLOS REGINAE	CRAPE MYRTLE TREE
	4	T4	CASSIA FISTULA	GOLDEN SHOWER
	5	T5	SARACA INDICA	ASHOKA TREE
	6	T6	DILLENIA INDICA	ELEPHANT APPLE
	7	T7	EXISTING TREE SPECIES	

03 LIST OF SPECIES PROPOSED
1:50


Indian Bank Residential Building At Mylapore

Indian Bank

Mylapore



KEY PLAN

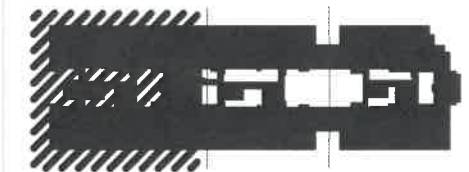

LEGEND

- PAVERS BLOCKS
- HEAVY DUTY PAVERS
- KOTA STONE
- HIGH SOLAR REFLECTANCY PERMEABLE PAVERS/GRASS PAVERS
- CONCRETE FINISH
- NATURAL GROUND
- GROUND COVER 1
- GROUND COVER 2
- SAND PIT
- EVA MAT
- LAWN GRASS
- GRANITE

NOTES

1. ALL DIMENSIONS ARE IN M.
2. THIS DRAWING IS TO BE READ AND NOT SCALED.
3. THE DRAWING IS A COPYRIGHT AND PROPERTY OF THE ARCHITECT. IT IS NOT TO BE PRODUCED, REPRODUCED, COPIED, OR USED FOR ANY OTHER PURPOSE WITHOUT THE WRITTEN PERMISSION OF THE ARCHITECT.

REVISION SCHEDULE

Rev. No.	Date	Revisions	Rev. by.
R1	21-06-23	AS PER CLIENT	DD

STRUCTURAL CONSULTANT

UNIVERSAL CONSULTANTS
Near No.214, First Cross Street, Indira Nagar,
Chennai - 600 029

ELECTRICAL CONSULTANT

AIR TREATMENT ENGINEERING PVT. LTD.,
L-6, 2nd WEST STREET, KAMARAJ
NAGAR, THIRUVANMIYUR, CHENNAI-600
041. PHONE: +91 - 44 - 2441 2536, 2445 4891
FAX: +91 - 44 - 2445 4308

PLUMBING CONSULTANT

AIR TREATMENT ENGINEERING PVT. LTD.,
L-6, 2nd WEST STREET, KAMARAJ
NAGAR, THIRUVANMIYUR, CHENNAI-600
041. PHONE: +91 - 44 - 2441 2536, 2445 4891
FAX: +91 - 44 - 2445 4308

Proj.No. : 2214
Scale : As indicated
Date : 21/06/23
Rev.No. : R0
Drawn by : DD
Checked by : SR

AR-351.15a




TENDER

FLOORING LAYOUT-STILT
FLOOR-BLOCK A PART 1


CHILPA
ARCHITECTS PLANNERS DESIGNERS PVT. LTD.
"The Muse"
120, Dr. VSI Estate, Thiruvanniyur, Chennai 600 041.
Phone : 044-24542162 / 43368531 / 42696536
Email : studio@hilpaarchitects.com
Web site : www.hilpaarchitects.com

FLOORING LAYOUT- STILT FLOOR
PLAN-BLOCK A PART 1

1/176

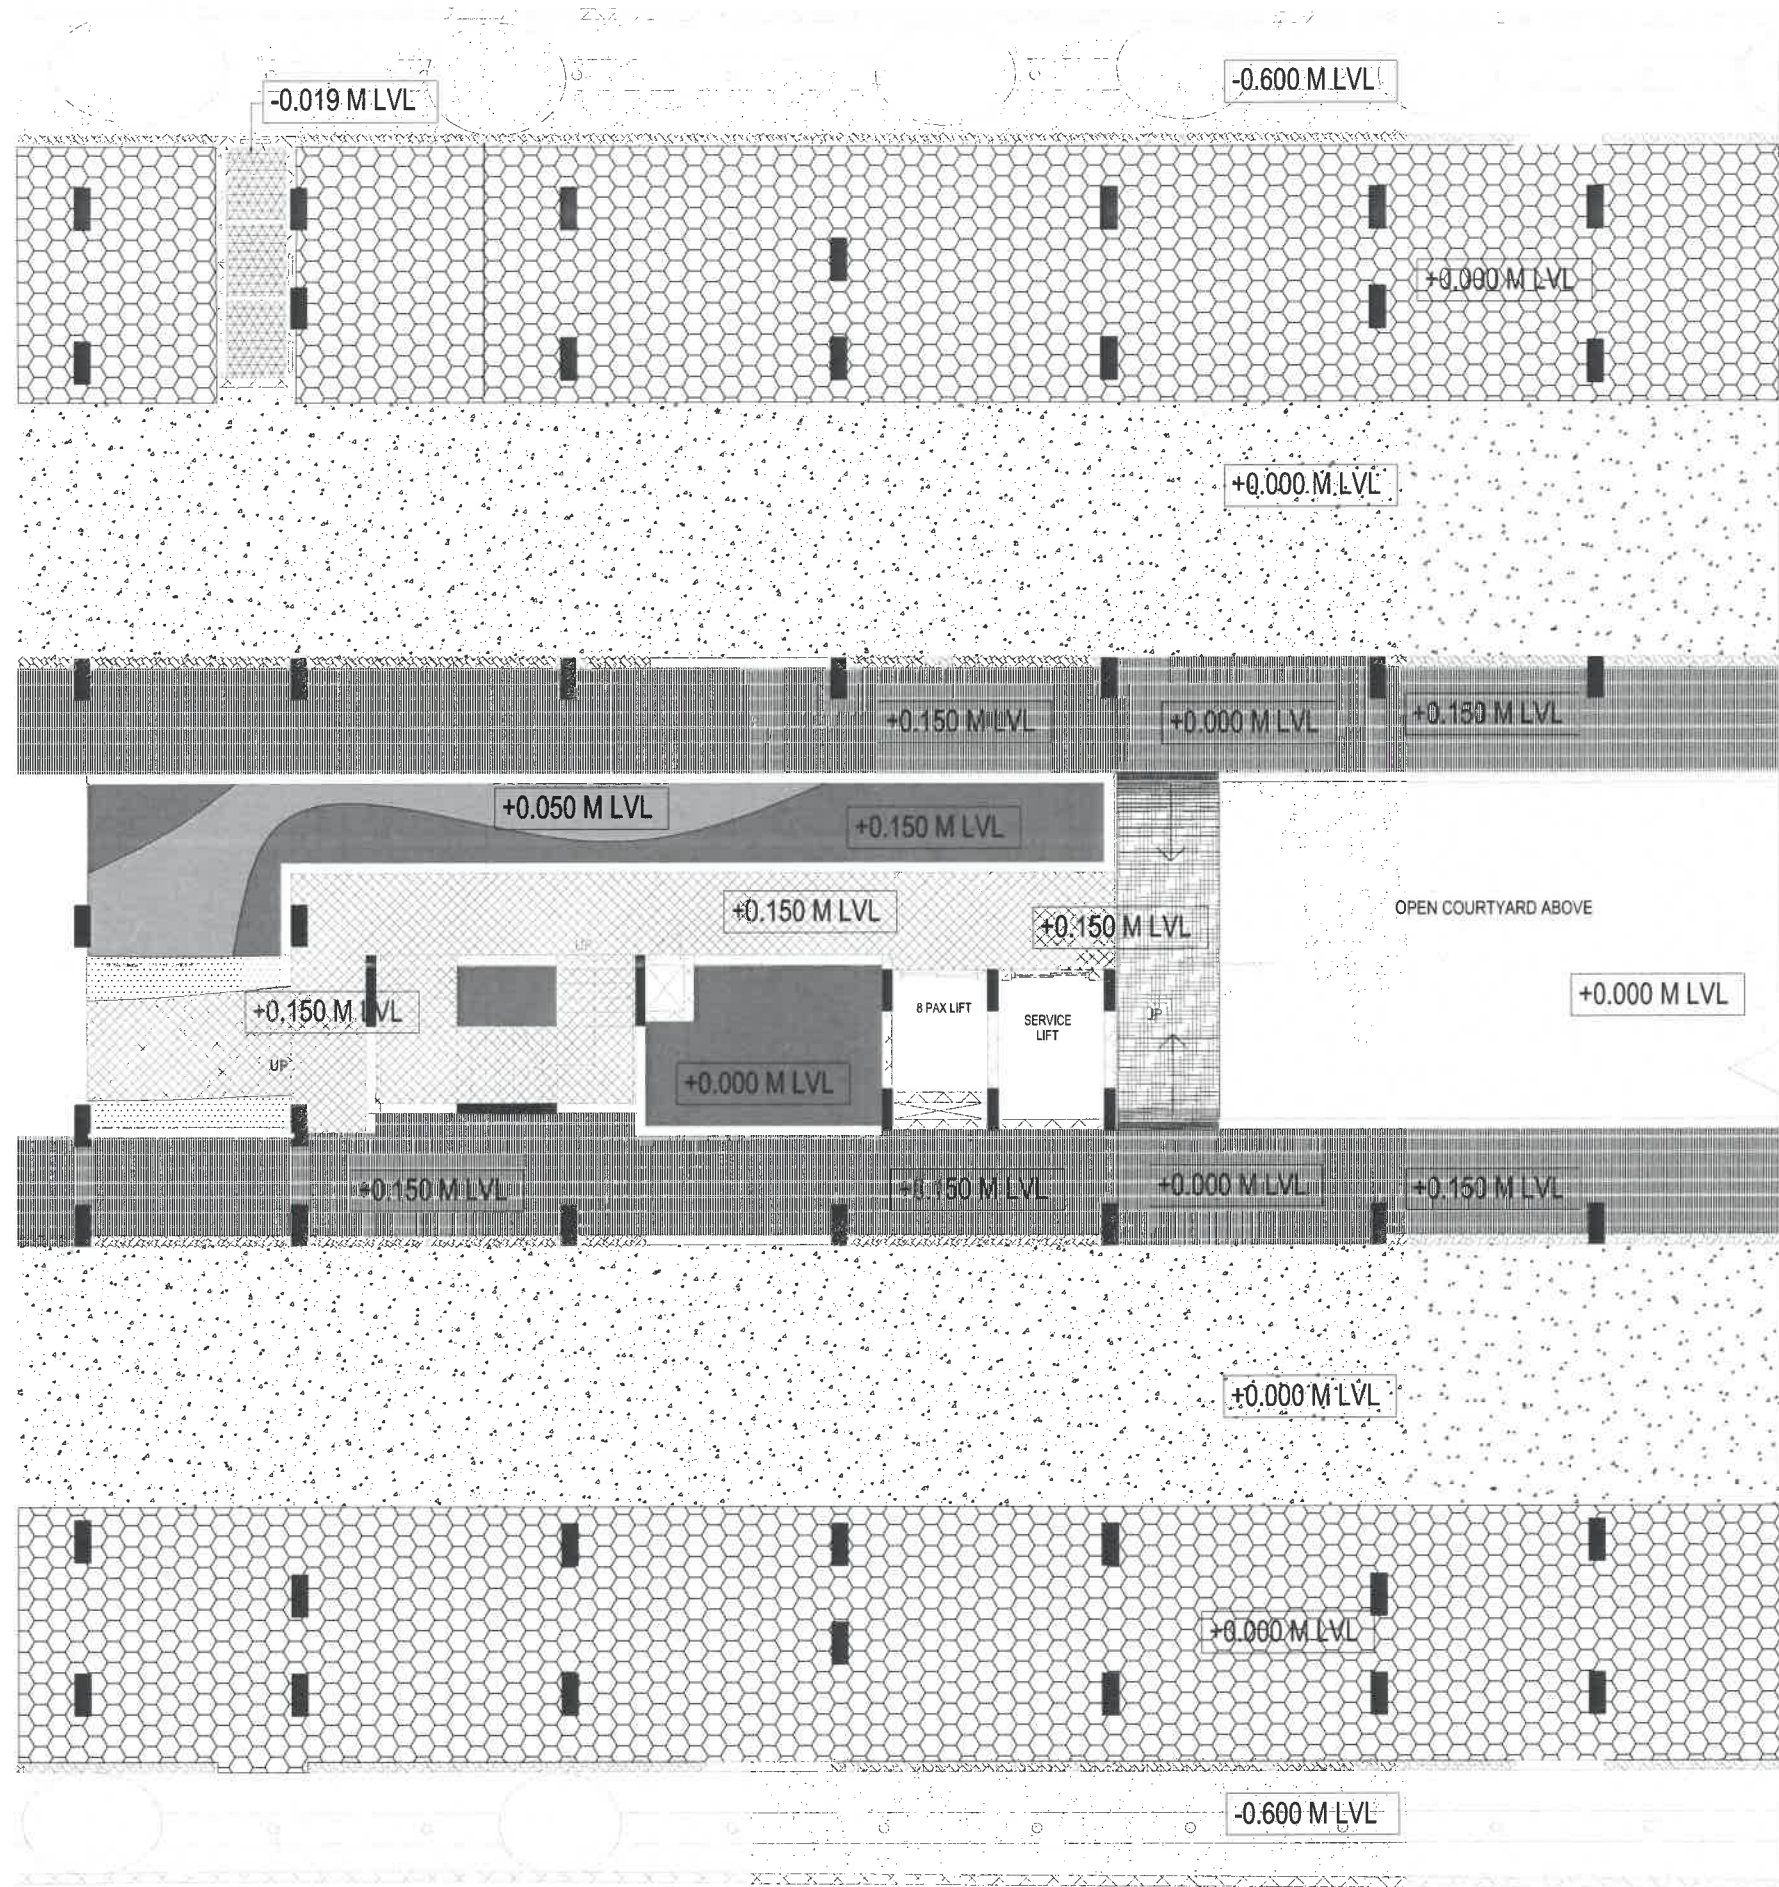

KEY PLAN

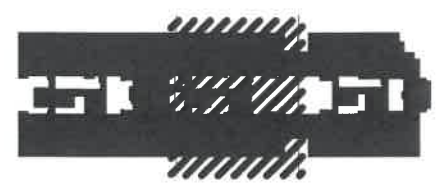

LEGEND

- PAVER BLOCKS
- HEAVY DUTY PAVERS
- KOTA STONE
- HIGH SOLAR REFLECTANCY PERMEABLE PAVERS/GRASS PAVERS
- CONCRETE FINISH
- NATURAL GROUND
- GROUND COVER 1
- GROUND COVER 2
- SAND PIT
- EVA MAT
- LAWN GRASS
- GRANITE

NOTES

REVISION	DATE	BY	REASON
1	21/06/23	DD	AS PER CLIENT

STRUCTURAL CONSULTANT	ELECTRICAL CONSULTANT
UNIVERSAL CONSULTANTS Room No. 101, First Floor, Mylapore, Chennai - 600 005	AR THIRUVENKATACHANDRAN & CO. P. LTD. 12, 13 and 14, WEST STREET, KATKAL CHENNAI - 600 002 TELEPHONE: 411-44-2411, 2500, 2441-4881 FAX: 411-44-2442, 4306

PLUMBING CONSULTANT
ENVIRONMENT ENGINEERING PVT. LTD. 12, 13 and 14, WEST STREET, KATKAL CHENNAI - 600 002 TELEPHONE: 411-44-2411, 2500, 2441-4881 FAX: 411-44-2442, 4306

Proj.No. : 2214	AR-351.15b
Scale : As Indicated	
Date : 21/06/23	
Rev.No. : R0	
Drawn by : DD	
Checked by : SR	

TENDER

FLOORING LAYOUT-STILT
FLOOR-BLOCK A PART 2


Indian Bank Residential Building At M

Indian Bank

Mylapore



KEY PLAN

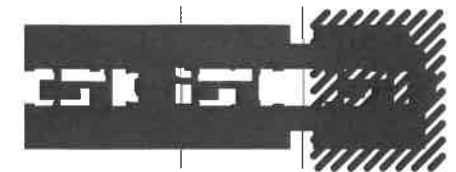

LEGEND

- PAVER BLOCKS
- HEAVY DUTY PAVERS
- KOTA STONE
- HIGH SOLAR REFLECTANCY PERMEABLE PAVERS/GRASS PAVERS
- CONCRETE FINISH
- NATURAL GROUND
- GROUND COVER 1
- GROUND COVER 2
- SAND PIT
- EVA MAT
- LAWN GRASS
- GRANITE

NOTES

Rev. No.	Disp.	Revised	Rev. By.
R1	21-06-23	AS PER CLIENT	DC

STRUCTURAL CONSULTANT	ELECTRICAL CONSULTANT
UNIVERSAL CONSULTANTS New No. 241, First Cross Street, Indira Nagar, Chennai - 600 020	AIR TREATMENT ENGINEERING PVT. LTD. L-6, 2nd WEST STREET, KAMARAJ NAGAR, THIRUVANMIYUR, CHENNAI-600 041.PHONE: +91 - 44 - 2441 2530, 2445 4891 FAX: +91 - 44 - 2445 4306

PLUMBING CONSULTANT
AIR TREATMENT ENGINEERING PVT. LTD. L-6, 2nd WEST STREET, KAMARAJ NAGAR, THIRUVANMIYUR, CHENNAI-600 041.PHONE: +91 - 44 - 2441 2530, 2445 4891 FAX: +91 - 44 - 2445 4306

Proj.No. : 2214
Scale : As indicated
Date : 21/06/23
Rev.No. : R0
Drawn by : DD
Checked by : SR


AR-351.16



TENDER

FLOORING LAYOUT-STILT FLOOR-BLOCK B

shilpa
ARCHITECTS PLANNERS DESIGNERS PVT. LTD.
"The Muse"
170, Dr. VSI Estate, Thiruvanniyur, Chennai 600 041.
Phone : 044 24542162 / 43358531 / 42696536
Email : studio@shilpaarchitects.com
Web site : www.shilpaarchitects.com

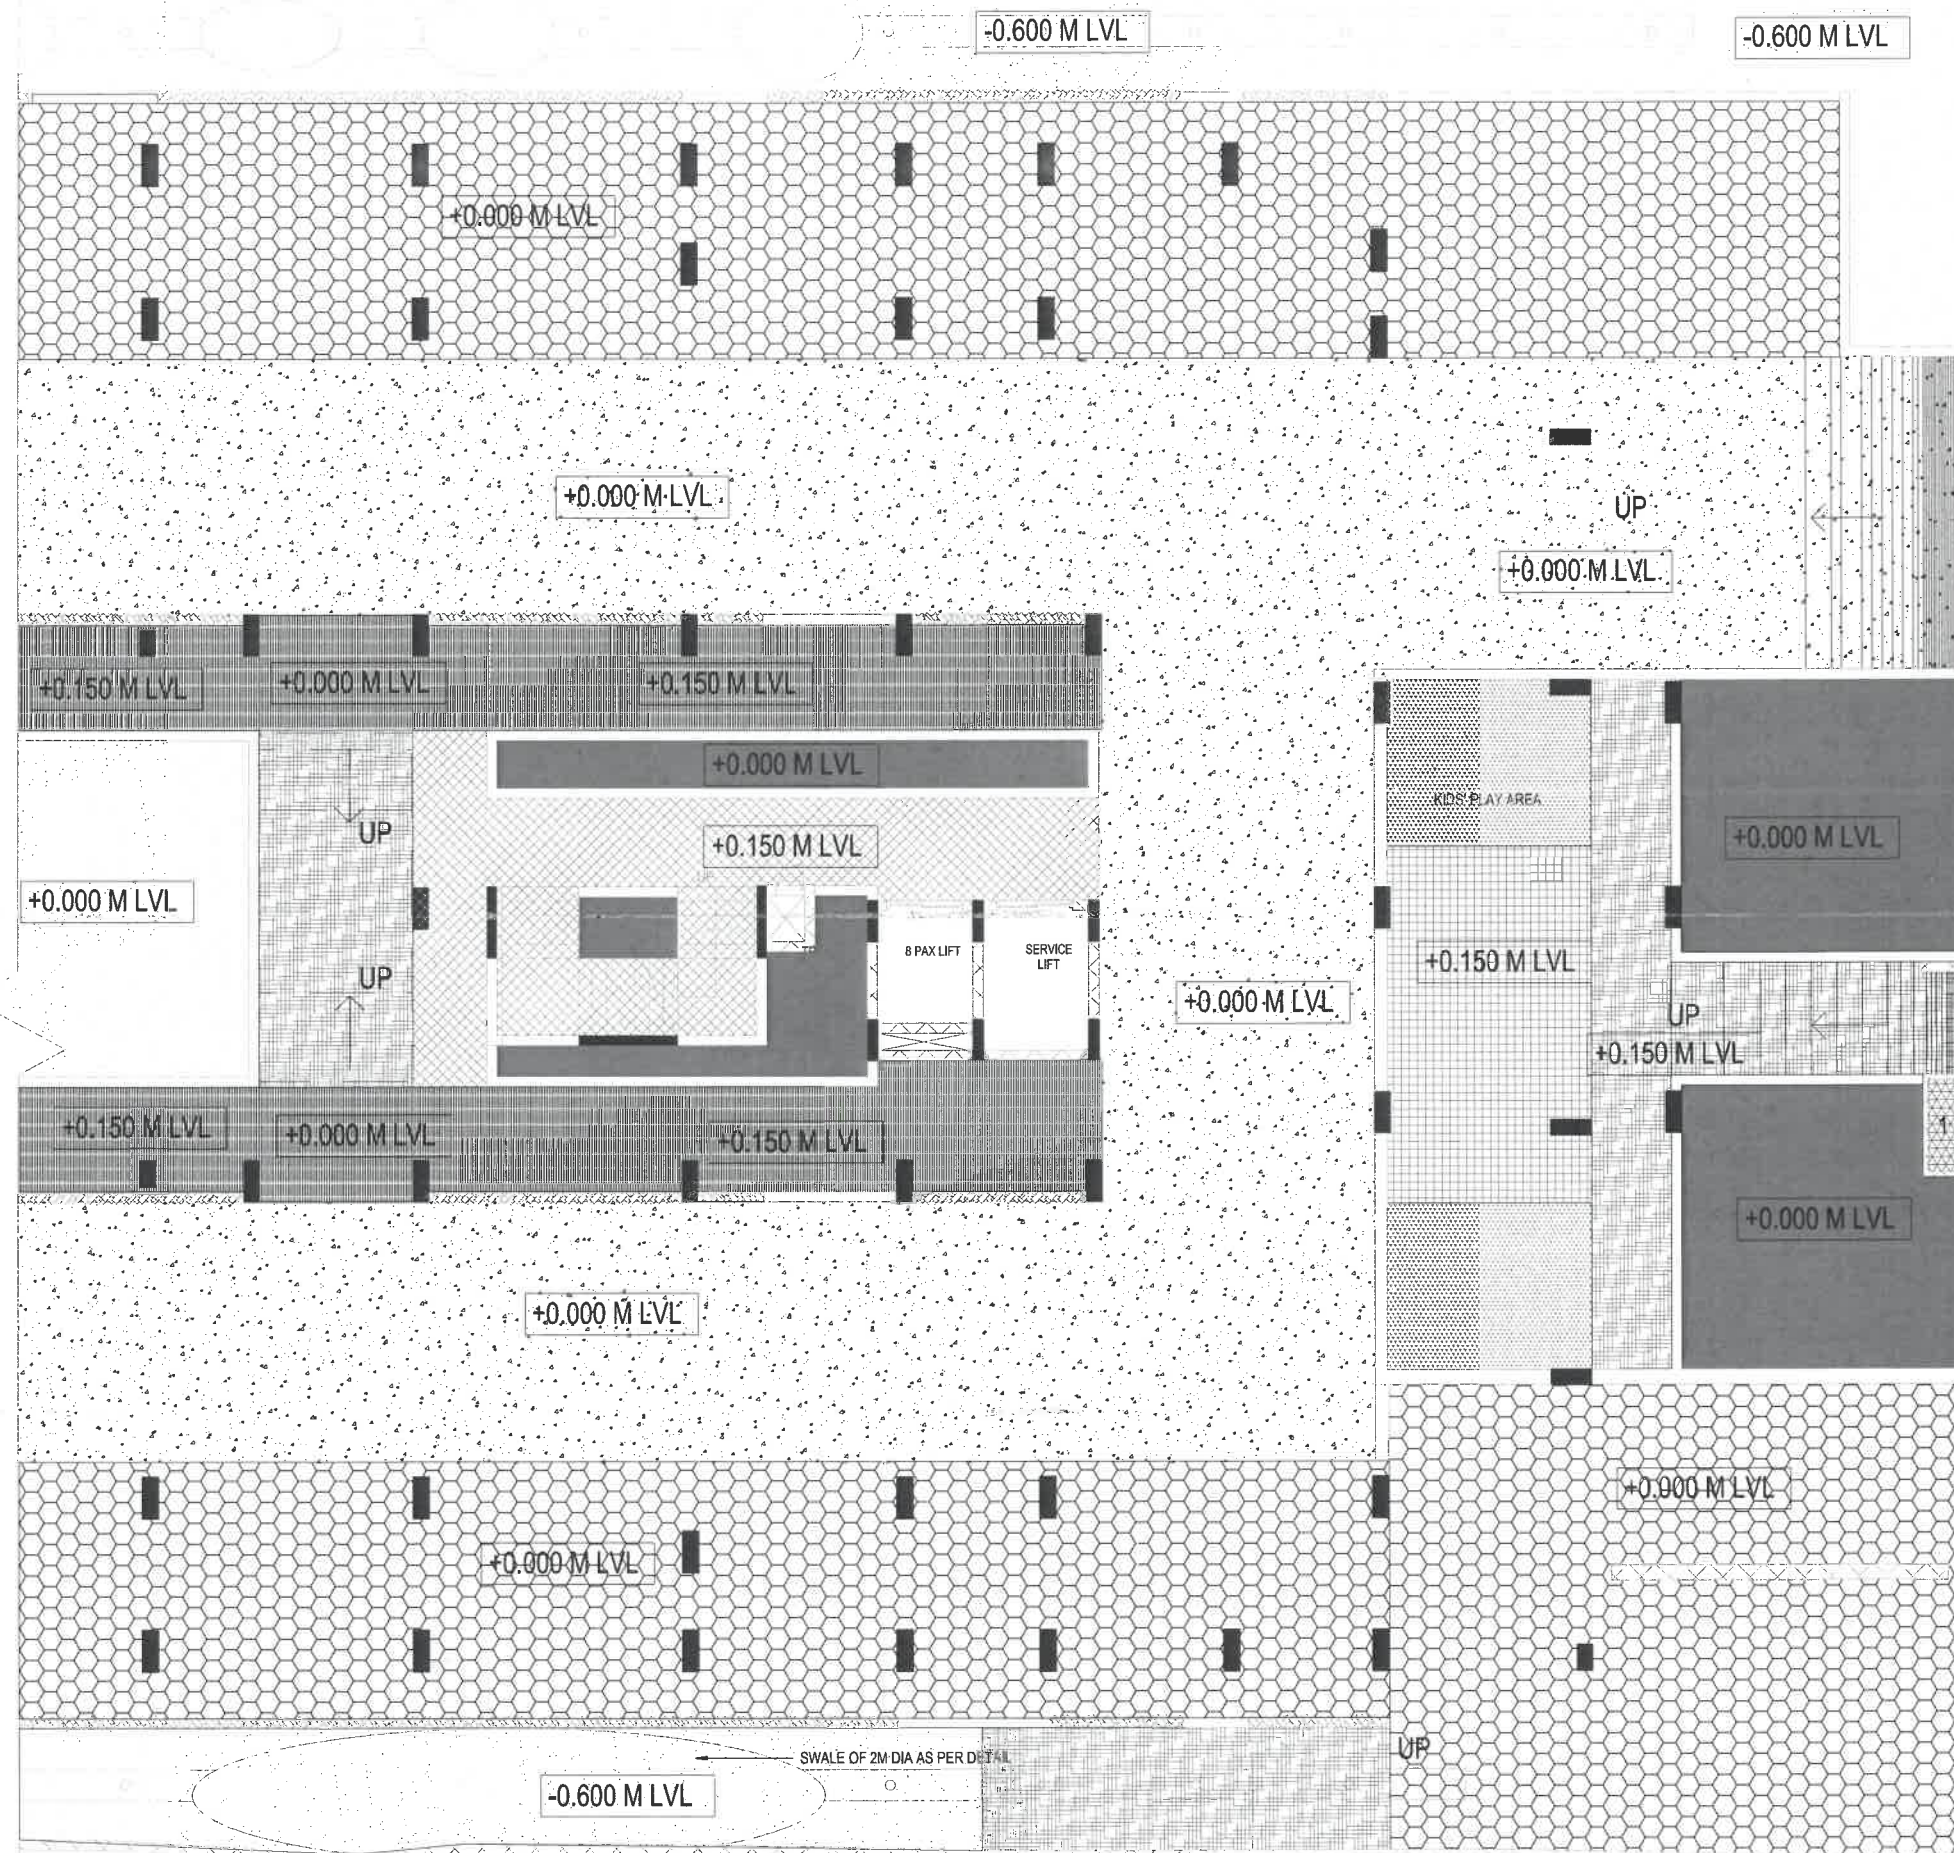

FLOORING LAYOUT- STILT FLOOR
PLAN- BLOCK B
1:75



Indian Bank Residential Building At Mylapore

KEY PLAN



KEY

LEGEND		
CAR CHARGING POINT		
5A 3 PIN SWITCHED SOCKET		
MOTION SENSOR LIGHT		
LOCAL CONTROL BOARD	4'6" LVL	
CONTROL BOARD	2'0" LVL	
TV ANTENNA SOCKET	2'0" LVL	
TELEPHONE SOCKET	2'0" LVL	
WALL BRACKET	@6" ABOVE LINTE	
STROBE LIGHT FIXTURE		
BELL PUSH		
CALLING BELL	8'9" LVL	
SHRUB LIGHTING	FLOOR MOUNTED	
FLOOD LIGHTING	FLOOR MOUNTED	
48" SWEEP CEILING FAN		
36" SWEEP CEILING FAN		
20A METAL CLAD SOCKET -A/C	8'0" LVL	
CHANDLIER LIGHT		
NETWORK POINT		
SURFACE MOUNT LED		
LOCAL CONTROL BOARD	2'0" LVL	
LOCAL CONTROL BOARD	3'0" LVL	
LOW LEVEL LIGHT	1'0" LVL	
9" DIA EXHAUST FAN		
WALL MOUNT FAN		
WARDROBE LIGHT	7'0" LVL	

NOTES

1) CALLING BELL AT 8'9" LEVEL (CB)
2) TELEPHONE OUTLET AT 2'0" LEVEL (TV)
3) LOCAL CONTROL BOARD AT 4'6" LEVEL (LCB)
4) LIGHT POINT AT 6" ABOVE LINTE LEVEL (LP)
5) CONTROL BOARD AT 2'0" LVL (CB)
6) TV OUTLET AT 2'0" LEVEL WITH TWO 6AMP PLUG POINTS (TV)
7) CONTROL BOARD AT 3'0" LVL (CB)
8) BALL LIGHT FIXTURES ARE LED
9) A/C CONTROL AT 8' LEVEL (AC)
10) TELEPHONE, NETWORK, CABLE TV SOCKETS TO BE TERMINATED AT SUITABLE LOCATION FOR ONT SIDE CONNECTION FROM SERVICE PROVIDERS IF SATELLITE TV IS DECIDED THEN ALL THE TV CABLE TO BE TERMINATED AT SUITABLE POINT IN TERRACE

NOTES		REVISION SCHEDULE		
Rev No.	Date	Revisions	Rev by.	

STRUCTURAL CONSULTANT	MEP CONSULTANT
UNIVERSAL CONSULTANTS New No.2/4, First Cross Street, Indira Nagar, Chennai - 600 020	AIR TREATMENT ENGINEERING PVT. LTD., L-6, 2nd WEST STREET, KAMARAJ NAGAR, THIRUVANMIYUR, CHENNAI-600 041,PHONE: +91 - 44 - 2441 2536, 2445 4891 FAX: +91 - 44 - 2445 4306

Proj.No. : 2214	AR-351.22a
Scale : As indicated	
Date : 26/06/23	
Rev.No. : R1	
Drawn by : DD	
Checked by : SS	

TENDER

BLOCK A- STILT FLOOR ELECTRICAL
FIXTURE LAYOUT PART 1/2

 
shilpa
ARCHITECTS PLANNERS DESIGNERS PVT. LTD.

"The Muse"
L20, Dr. VSI Estate, Thiruvanniyur, Chennai 600 041.
Phone : 044 24542162 / 43358531 / 42696536
Email : studio@shilpaarchitects.com
Web site : www.shilpaarchitects.com



Indian Bank Residential
Building At Mylapore

KEY PLAN



KEY

LEGEND		
5/15 A 3PIN SWITCHED SOCKET		⬆
5A 3 PIN SWITCHED SOCKET		⬆
MOTION SENSOR LIGHT		⬆
LOCAL CONTROL BOARD	4'-6" LVL	⬆
DISTRIBUTION BOARD		⬆
T.V ANTENNA SOCKET	2'-0" LVL	⬆
TELEPHONE SOCKET	2'-0" LVL	⬆
WALL BRACKET	6" ABOVE LINTE	⬆
CEILING DOME LIGHT FIXTURE		⬆
BELL PUSH		⬆
CALLING BELL	8'-9" LVL	⬆
BULK HEAD FITTING		⬆
48" SWEEP CEILING FAN		⬆
36" SWEEP CEILING FAN		⬆
20A METAL CLAD SOCKET -A/C	8'-0" LVL	⬆
CHANDLIER LIGHT		⬆
NETWORK POINT		⬆
SURFACE MOUNT LED		⬆
LOCAL CONTROL BOARD	2'-0" LVL	⬆
LOCAL CONTROL BOARD	3'-0" LVL	⬆
LOW LEVEL LIGHT	1'-0" LVL	⬆
9" DIA EXHAUST FAN		⬆
WALL MOUNT FAN	5'-6" LVL	⬆
WARDROBE LIGHT	7'-0" LVL	⬆

NOTE

1. CALLING BELL AT 8'-9" LEVEL (⬆)

2. TELEPHONE OUTLET AT 2'-0" LEVEL (⬆)

3. LOCAL CONTROL BOARD AT 4'-6" LEVEL (⬆)

4. LIGHT POINT AT 6" ABOVE LINTEL LEVEL (⬆)

5. CONTROL BOARD AT 2'-6" LVL (⬆)

6. T.V OUTLET AT 2'-0" LEVEL WITH TWO 6AMP PLUG POINTS (⬆)

7. CONTROL BOARD AT 3'-0" LVL (⬆)

8. ALL LIGHT FIXTURES ARE LED

9. A/C CONTROL AT 8' LEVEL (⬆)

10. TELEPHONE, NETWORK, CABLE TV SOCKETS TO BE TERMINATED AT SUITABLE LOCATION FOR OUT SIDE CONNECTION FROM SERVICE PROVIDERS IF SATELITE TV IS DECIDED THEN ALL THE TV CABLE TO BE TERMINATED AT SUITABLE POINT IN TERRACE

NOTES		REVISION SCHEDULE			
1. ALL DIMENSION ARE IN M.		Rev No.	Date	Revisions	Rev by.
2. THIS DRAWING IS TO BE READ AND NOT SCALED.					
3. THIS DRAWING IS A COPYRIGHT AND PROPERTY OF THE ARCHITECT, IS NOT TO BE PRODUCED, HANDED OVER TO THIRD PARTY OR USED FOR ANY OTHER PURPOSE OTHER THAN FOR WHICH IT IS INTENDED.					

STRUCTURAL CONSULTANT	MEP CONSULTANT
UNIVERSAL CONSULTANTS New No.2/4, First Cross Street, Indira Nagar, Chennai - 600 020	AIR TREATMENT ENGINEERING PVT. LTD. L-6, 2nd WEST STREET, KAMARAJ NAGAR, THIRUVANMIYUR, CHENNAI-600 041.PHONE: +91 - 44 - 2441 2536, 2445 4891 FAX: +91 - 44 - 2445 4306


Proj.No. : 2214	AR-351.26b
Scale : As Indicated	
Date : 04/07/23	
Rev.No. : R0	
Drawn by : DD	
Checked by : SS	NORTH

TENDER

BLOCK A- TERRACE FLOOR
ELECTRICAL FIXTURE LAYOUT
PART 2/2

Indian Bank Residential Building At Mylapore

 KEY PLAN



KEY

LEGEND	
1. 15 A 3PIN SWITCHED SOCKET	
2. 15 A 3PIN SWITCHED SOCKET	
3. MOTION SENSOR LIGHT	
4. LOCAL CONTROL BOARD	4'-6" LVL
5. DISTRIBUTION BOARD	
6. TV ANTENNA SOCKET	2'-0" LVL
7. TELEPHONE SOCKET	2'-0" LVL
8. WALL BRACKET	6'-6" ABOVE LINTEL
9. 1/4" DIA DOME LIGHT FIXTURE	
10. BELL PUSH	
11. CALLING BELL	8'-9" LVL
12. BELL HEAD FITTING	
13. 8" SWEEP CEILING FAN	
14. 16" SWEEP CEILING FAN	
15. TERMINAL CLAD SOCKET - A/C	8'-0" LVL
16. CHANCELLER LIGHT	
17. NETWORK POINT	
18. SURFACE MOUNT LED	
19. LOCAL CONTROL BOARD	2'-0" LVL
20. LOCAL CONTROL BOARD	3'-0" LVL
21. LOW LEVEL LIGHT	1'-0" LVL
22. 1/4" DIA EXHAUST FAN	
23. WALL MOUNT FAN	6'-5" LVL
24. WARDROBE LIGHT	7'-0" LVL
25. DOWNLIGHTER	

NOTE

1. CALLING BELL AT 8'-9" LEVEL ()
2. TELEPHONE OUTLET AT 2'-0" LEVEL ()
3. LOCAL CONTROL BOARD AT 4'-6" LEVEL ()
4. LIGHT POINT AT 6" ABOVE LINTEL LEVEL ()
5. CONTROL BOARD AT 2'-6" LVL ()
6. T.V OUTLET AT 2'-0" LEVEL WITH TWO 6AMP PLUG POINTS ()
7. CONTROL BOARD AT 3'-0" LVL ()
8. ALL LIGHT FIXTURES ARE LED
9. A/C CONTROL AT 8' LEVEL ()
10. TELEPHONE, NETWORK, CABLE TV SOCKETS TO BE TERMINATED AT SUITABLE LOCATION FOR OUT SIDE CONNECTION FROM SERVICE PROVIDERS IF SATELITE TV IS DECIDED THEN ALL THE TV CABLE TO BE TERMINATED AT SUITABLE POINT IN TERRACE

NOTES

1. ALL DIMENSION ARE IN M.
2. THIS DRAWING IS TO BE READ AND NOT SCALED.
3. THIS DRAWING IS A COPYRIGHT AND PROPERTY OF THE ARCHITECT. IS NOT TO BE PRODUCED, HANDED OVER TO THIRD PARTY OR USED FOR ANY OTHER PURPOSE OTHER THAN FOR WHICH IT IS INTENDED.

REVISION SCHEDULE

Rev No.	Date	Revisions	Rev by.

STRUCTURAL CONSULTANT MEP CONSULTANT

UNIVERSAL CONSULTANTS
New No.24, First Cross Street, Indira Nagar,
Chennai - 600 020

AIR TREATMENT ENGINEERING PVT. LTD.
C-6, 2nd WEST STREET, KAMARAJ
NAGAR, THIRUVANMIYUR, CHENNAI-600
041.PHONE: +91 - 44 - 2441 2536, 2445 4891
FAX: +91 - 44 - 2445 4306

Proj.No. : 2214
Scale : As indicated
Date : 04/07/23
Rev.No. : R1
Drawn by : DD
Checked by : SS

AR-351.24a




TENDER

BLOCK A- TYPICAL FLOOR ELECTRICAL FIXTURE PART 1/2

shilpa
ARCHITECTS PLANNERS DESIGNERS PVT. LTD.

"The Muse"
L20, Dr. VSI Estate, Thiruvanniyur, Chennai 600 041.
Phone : 044 24542162 / 4358531 / 42696536
Email : studio@shilpaarchitects.com
Web site : www.shilpaarchitects.com

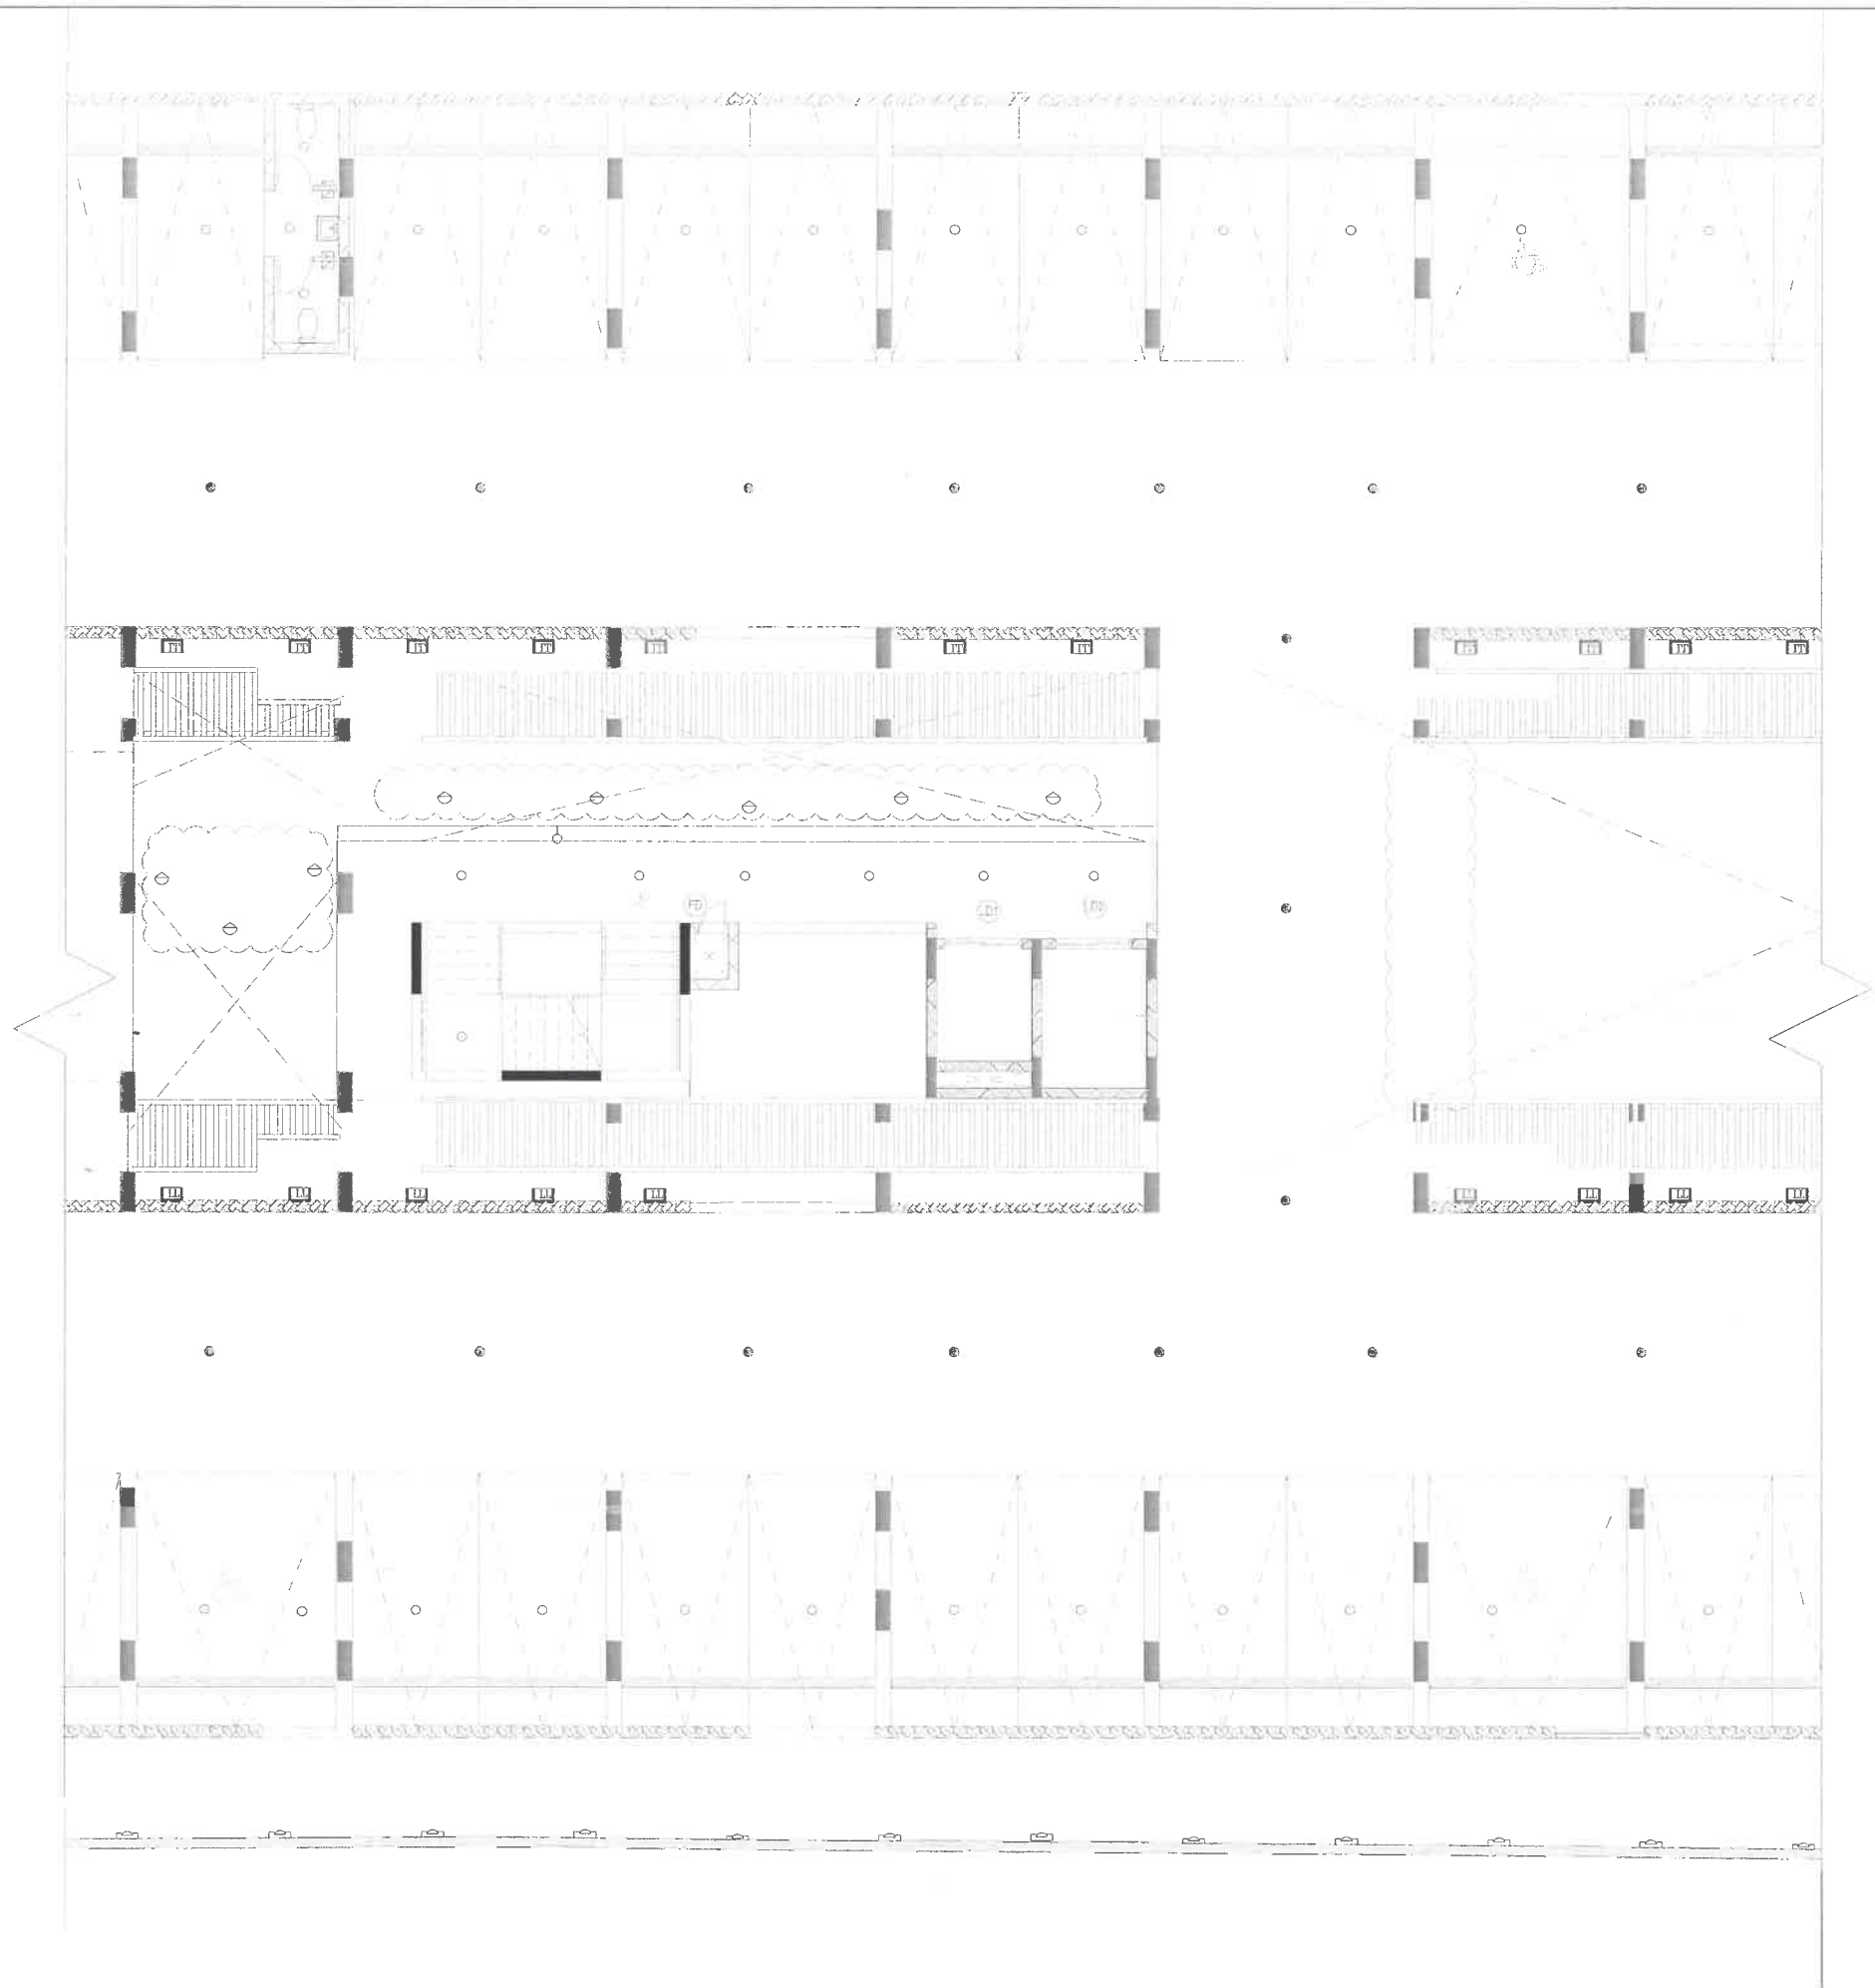

Indian Bank Residential Building At Mylapore

KEY PLAN



KEY

LEGEND		
CAR CHARGING POINT		
5A 3 PIN SWITCHED SOCKET		
MOTION SENSOR LIGHT		
LOCAL CONTROL BOARD	4'-6" LVL	
DISTRIBUTION BOARD		
T.V. ANTENNA SOCKET	2'-0" LVL	
TELEPHONE SOCKET	2'-0" LVL	
WALL BRACKET	@6" ABOVE LINTEL	
CEILING DOME LIGHT FIXTURE		
BELL PUSH		
CALLING BELL	8'-9" LVL	
SHRUB LIGHTING	FLOOR MOUNTED	
FLOOD LIGHTING	FLOOR MOUNTED	
48" SWEEP CEILING FAN		
36" SWEEP CEILING FAN		
20A METAL CLAD SOCKET -A/C	8'-0" LVL	
CHANDLER LIGHT		
NETWORK POINT		
SURFACE MOUNT LED		
LOCAL CONTROL BOARD	2'-0" LVL	
LOCAL CONTROL BOARD	3'-0" LVL	
LOW LEVEL LIGHT	1'-0" LVL	
5" DIA EXHAUST FAN		
WALL MOUNT FAN		
WALL DROBE LIGHT	7'-0" LVL	

- NOTE
1. CALLING BELL AT 8'-9" LEVEL ()
 2. TELEPHONE OUTLET AT 2'-0" LEVEL ()
 3. LOCAL CONTROL BOARD AT 4'-6" LEVEL ()
 4. LIGHT POINT AT 6" ABOVE LINTEL LEVEL ()
 5. CONTROL BOARD AT 2'-6" LVL ()
 6. T.V. OUTLET AT 2'-0" LEVEL WITH TWO 6AMP PLUG POINTS ()
 7. CONTROL BOARD AT 3'-0" LVL ()
 8. ALL LIGHT FIXTURES ARE LED
 9. A/C CONTROL AT 8' LEVEL ()
 10. TELEPHONE, NETWORK, CABLE TV SOCKETS TO BE TERMINATED AT SUITABLE LOCATION FOR OUT SIDE CONNECTION FROM SERVICE PROVIDERS IF SATELITE TV IS DECIDED THEN ALL THE TV CABLE TO BE TERMINATED AT SUITABLE POINT IN TERRACE

NOTES

1. ALL DIMENSION ARE IN M.
2. THIS DRAWING IS TO BE READ AND NOT SCALED.
3. THIS DRAWING IS A COPYRIGHT AND PROPERTY OF THE ARCHITECT, IS NOT TO BE PRODUCED, HANDED OVER TO THIRD PARTY OR USED FOR ANY OTHER PURPOSE OTHER THAN FOR WHICH IT IS INTENDED.

REVISION SCHEDULE

Rev No.	Date	Revisions	Rev by.

STRUCTURAL CONSULTANT	MEP CONSULTANT
UNIVERSAL CONSULTANTS New No.2/4, First Cross Street, Indira Nagar, Chennai - 600 020	AIR TREATMENT ENGINEERING PVT. LTD., L-6, 2nd WEST STREET, KAMARAJ NAGAR, THIRUVANMIYUR, CHENNAI-600 041, PHONE: +91 - 44 - 2441 2536, 2445 4891 FAX: +91 - 44 - 2445 4306

Proj.No. : 2214
Scale : As Indicated
Date : 26/06/23
Rev.No. : R1
Drawn by : DD
Checked by : SS

AR-351.20b



TENDER


BLOCK A- STILT FLOOR LIGHTING PLAN PART 2/2

shilpa
ARCHITECTS PLANNERS DESIGNERS PVT. LTD.
"The Muse"
L20, Dr. VSI Estate, Thiruvanniyur, Chennai 600 041.
Phone : 044 24542162 / 43358531 / 42696536
Email : studio@shilpaarchitects.com
Web site : www.shilpaarchitects.com



Indian Bank Residential
Building At Mylapore

KEY PLAN

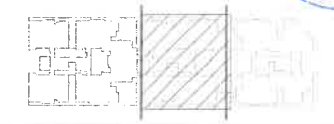

KEY

LEGEND		
5/15 A 3PIN SWITCHED SOCKET		⬆
5A 3 PIN SWITCHED SOCKET		⬆
MOTION SENSOR LIGHT		⬆
LOCAL CONTROL BOARD	4'-6" LVL	⬆
DISTRIBUTION BOARD		⬆
T.V ANTENNA SOCKET	2'-0" LVL	⬆
TELEPHONE SOCKET	2'-0" LVL	⬆
WALL BRACKET	@6" ABOVE LINTE	⬆
CEILING DOME LIGHT FIXTURE		⬆
BELL PUSH		⬆
CALLING BELL	8'-9" LVL	⬆
BULK HEAD FITTING		⬆
48" SWEEP CEILING FAN		⬆
36" SWEEP CEILING FAN		⬆
20A METAL CLAD SOCKET -A/C	8'-0" LVL	⬆
CHANDLIER LIGHT		⬆
NETWORK POINT		⬆
SURFACE MOUNT LED		⬆
LOCAL CONTROL BOARD	2'-0" LVL	⬆
LOCAL CONTROL BOARD	3'-0" LVL	⬆
LOW LEVEL LIGHT	1'-0" LVL	⬆
9" DIA EXHAUST FAN		⬆
WALL MOUNT FAN	6'-6" LVL	⬆
WARDROBE LIGHT	7'-0" LVL	⬆

NOTE

1. CALLING BELL AT 8'-9" LEVEL (⬆)
2. TELEPHONE OUTLET AT 2'-0" LEVEL (⬆)
3. LOCAL CONTROL BOARD AT 4'-6" LEVEL (⬆)
4. LIGHT POINT AT 6" ABOVE LINTEL LEVEL (⬆)
5. CONTROL BOARD AT 2'-6" LVL (⬆)
6. T.V OUTLET AT 2'-0" LEVEL WITH TWO 6AMP PLUG POINTS (⬆)
7. CONTROL BOARD AT 3'-0" LVL (⬆)
8. ALL LIGHT FIXTURES ARE LED
9. A/C CONTROL AT 6' LEVEL (⬆)
10. TELEPHONE, NETWORK, CABLE TV SOCKETS TO BE TERMINATED AT SUITABLE LOCATION FOR OUT SIDE CONNECTION FROM SERVICE PROVIDERS IF SATELITE TV IS DECIDED THEN ALL THE TV CABLE TO BE TERMINATED AT SUITABLE POINT IN TERRACE

NOTES	REVISION SCHEDULE			
	Rev No.	Date	Revisions	Rev by.
1. ALL DIMENSION ARE IN M. 2. THIS DRAWING IS TO BE READ AND NOT SCALED. 3. THIS DRAWING IS A COPYRIGHT AND PROPERTY OF THE ARCHITECT, IS NOT TO BE PRODUCED, HANDED OVER TO THIRD PARTY OR USED FOR ANY OTHER PURPOSE OTHER THAN FOR WHICH IT IS INTENDED.				

STRUCTURAL CONSULTANT	MEP CONSULTANT
UNIVERSAL CONSULTANTS New No.2/4, First Cross Street, Indra Nagar, Chennai - 600 020	AIR TREATMENT ENGINEERING PVT. LTD., C-6, 2nd WEST STREET, KAMARAJ NAGAR, THIRUVANMIYUR, CHENNAI-600 041, PHONE: +91 - 44 - 2441 2536, 2445 4891 FAX: +91 - 44 - 2445 4306

Proj.No. : 2214	AR-351.26b
Scale : As indicated	
Date : 04/07/23	
Rev.No. : R1	
Drawn by : DD	
Checked by : SS	

TENDER

BLOCK A- TERRACE FLOOR
ELECTRICAL FIXTURE LAYOUT
PART 2/2

shilpa
ARCHITECTS PLANNERS DESIGNERS PVT. LTD.

"The Muse"
L20, Dr. VSI Estate, Thiruvanniyur, Chennai 600 041.
Phone : 044 24542162 / 43358531 / 42696536
Email : studio@shilpaarchitects.com
Web site : www.shilpaarchitects.com



Indian Bank Residential Building At Mylapore

KEY PLAN



KEY

LEGEND		
5/15 A 3PIN SWITCHED SOCKET		
5A 3 PIN SWITCHED SOCKET		
MOTION SENSOR LIGHT		
LOCAL CONTROL BOARD	4'-6" LVL	
DISTRIBUTION BOARD		
T.V ANTENNA SOCKET	2'-0" LVL	
TELEPHONE SOCKET	2'-0" LVL	
WALL BRACKET	@6" ABOVE LINTEL	
CEILING DOME LIGHT FIXTURE		
BELL PUSH		
CALLING BELL	8'-9" LVL	
BULK HEAD FITTING		
48" SWEEP CEILING FAN		
36" SWEEP CEILING FAN		
20A METAL CLAD SOCKET -A/C	8'-0" LVL	
CHANDELIER LIGHT		
NETWORK POINT		
SURFACE MOUNT LED		
LOCAL CONTROL BOARD	2'-0" LVL	
LOCAL CONTROL BOARD	3'-0" LVL	
LOW LEVEL LIGHT	1'-0" LVL	
9" DIA EXHAUST FAN		
WALL MOUNT FAN	6'-6" LVL	
WARDROBE LIGHT	7'-0" LVL	

- NOTE
1. CALLING BELL AT 8'-9" LEVEL ()
 2. TELEPHONE OUTLET AT 2'-0" LEVEL ()
 3. LOCAL CONTROL BOARD AT 4'-6" LEVEL ()
 4. LIGHT POINT AT 6" ABOVE LINTEL LEVEL ()
 5. CONTROL BOARD AT 2'-6" LVL ()
 6. T.V OUTLET AT 2'-0" LEVEL WITH TWO 6AMP PLUG POINTS ()
 7. CONTROL BOARD AT 3'-0" LVL ()
 8. ALL LIGHT FIXTURES ARE LED
 9. A/C CONTROL AT 8' LEVEL ()
 10. TELEPHONE, NETWORK, CABLE TV SOCKETS TO BE TERMINATED AT SUITABLE LOCATION FOR OUT SIDE CONNECTION FROM SERVICE PROVIDERS IF SATELITE TV IS DECIDED THEN ALL THE TV CABLE TO BE TERMINATED AT SUITABLE POINT IN TERRACE

NOTES		REVISION SCHEDULE		
1. ALL DIMENSION ARE IN M.		Rev No.	Date	Revisions
2. THIS DRAWING IS TO BE READ AND NOT SCALED.				
3. THIS DRAWING IS A COPYRIGHT AND PROPERTY OF THE ARCHITECT. IS NOT TO BE PRODUCED, HANDLED OVER TO THIRD PARTY OR USED FOR ANY OTHER PURPOSE OTHER THAN FOR WHICH IT IS INTENDED.				

STRUCTURAL CONSULTANT	MEP CONSULTANT
UNIVERSAL CONSULTANTS New No.24, First Cross Street, Indira Nagar, Chennai - 600 020	AIR TREATMENT ENGINEERING PVT. LTD., L-6, 2nd WEST STREET, KAMARAJ NAGAR, THIRUVANMIYUR, CHENNAI-600 041, PHONE: +91 - 44 - 2441 2536, 2445 4891 FAX: +91 - 44 - 2445 4306

Proj.No.	: 2214
Scale	: As Indicated
Date	: 04/07/23
Rev.No.	: R0
Drawn by	: DD
Checked by	: SS

AR-351.24B




TENDER

BLOCK A- TYPICAL FLOOR
ELECTRICAL FIXTURE LAYOUT PART
2/2

shilpa
ARCHITECTS PLANNERS DESIGNERS PVT. LTD.

"The Muse"
L20, Dr. VSI Estate, Thiruvanniyur, Chennai 600 041.
Phone : 044 24542162 / 43358531 / 42696536
Email : studio@shilpaarchitects.com
Web site : www.shilpaarchitects.com

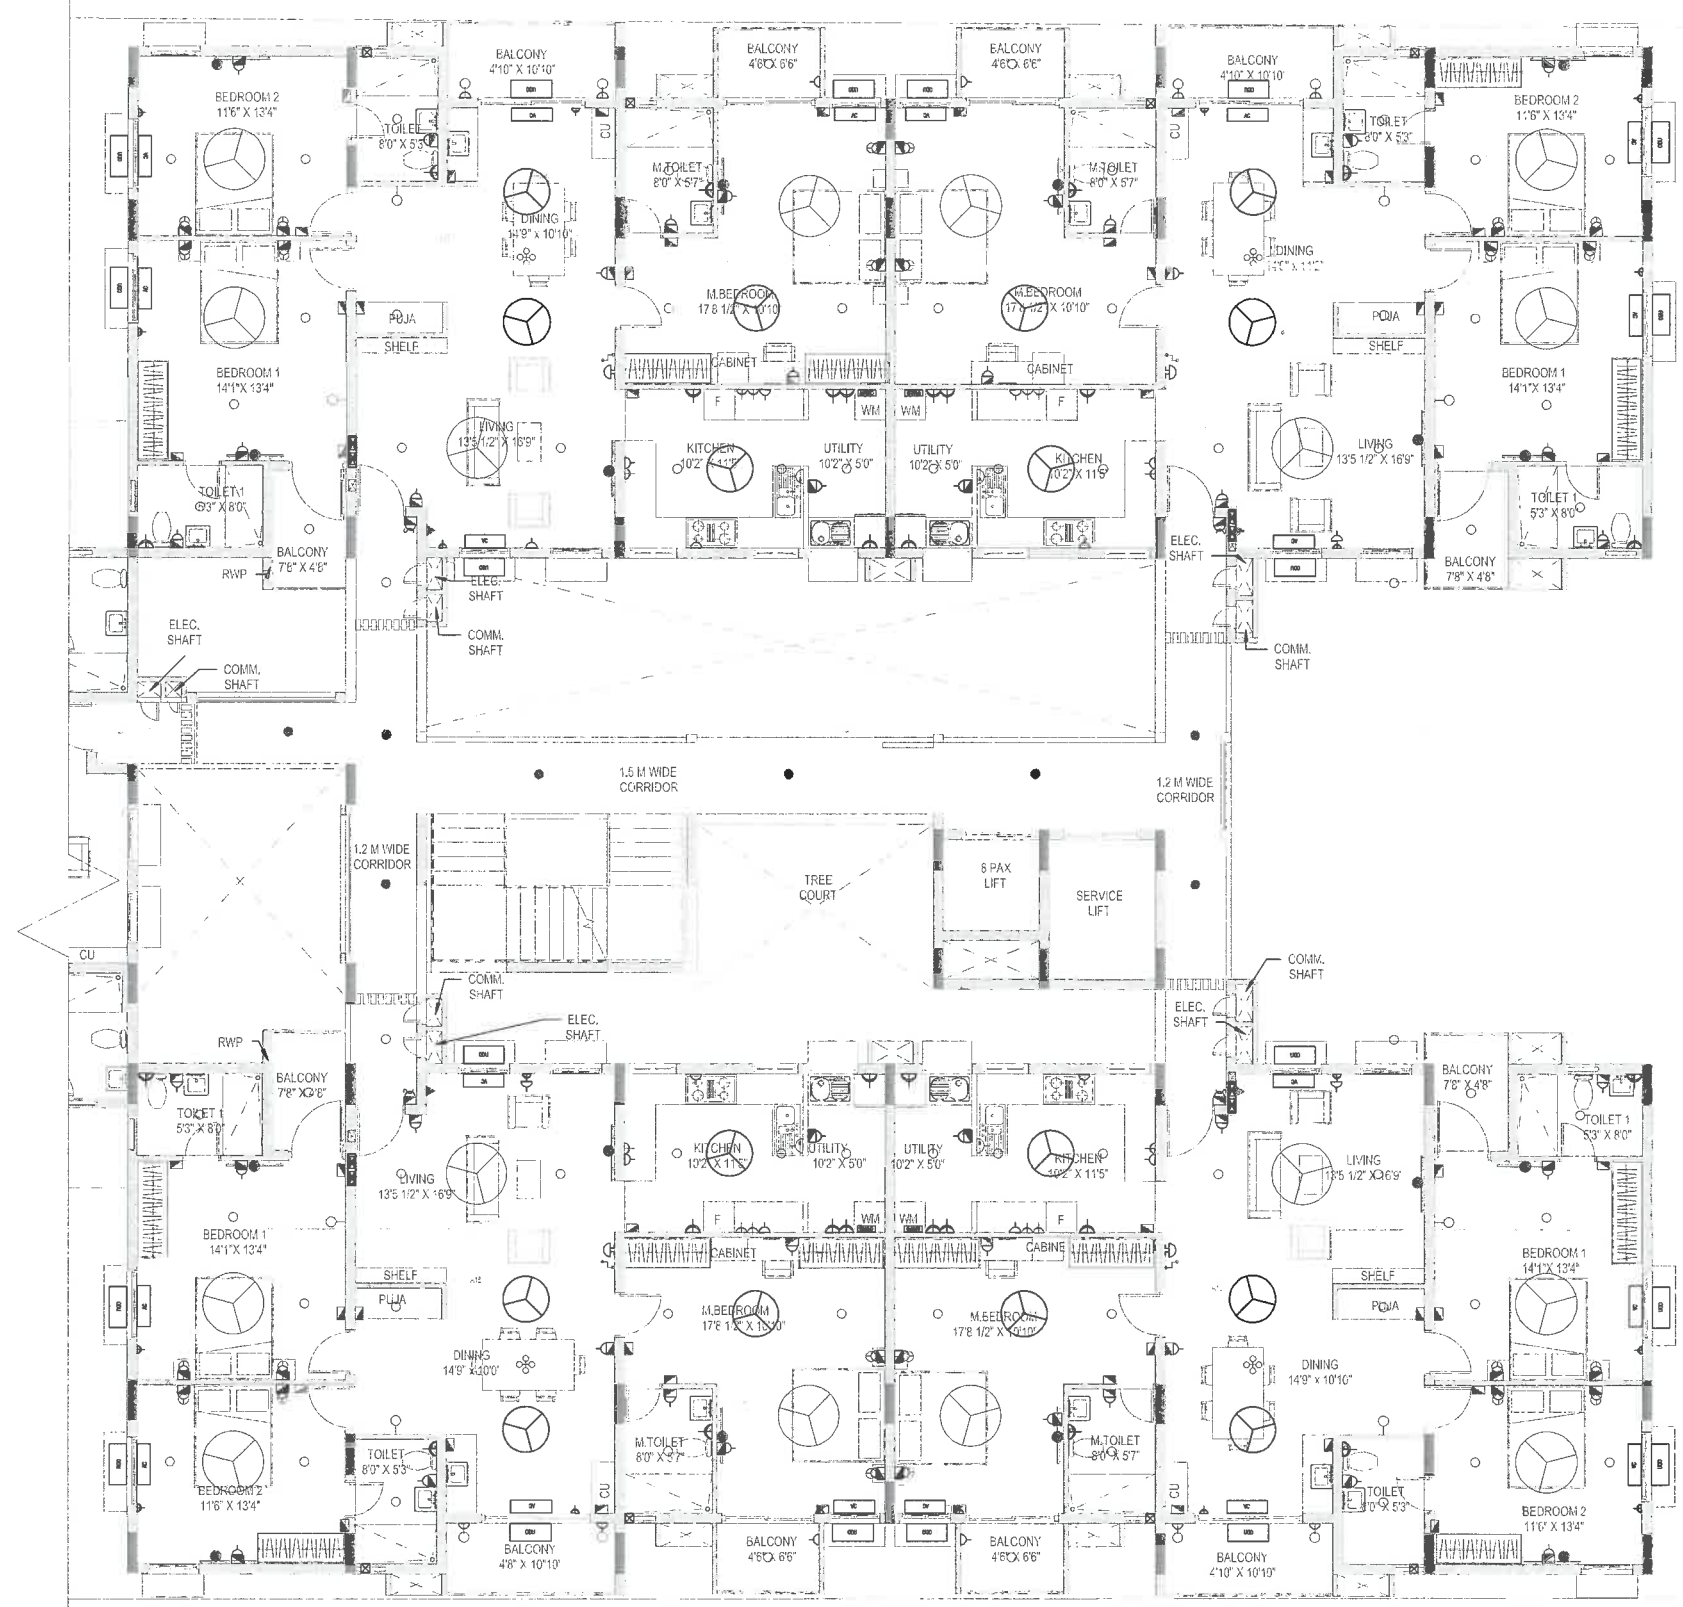



Indian Bank Residential Building At Mylapore

KEY PLAN



KEY

LEGEND		
CAR CHARGING POINT		△
5A 3 PIN SWITCHED SOCKET		△
MOTION SENSOR LIGHT		△
LOCAL CONTROL BOARD	4'-6" LVL	△
DISTRIBUTION BOARD		△
T.V ANTENNA SOCKET	2'-0" LVL	△
TELEPHONE SOCKET	2'-0" LVL	△
WALL BRACKET	6" ABOVE LINTEL	△
CEILING DOME LIGHT FIXTURE		△
BELL PUSH		△
CALLING BELL	8'-9" LVL	△
SHRUB LIGHTING	FLOOR MOUNTED	△
FLOOD LIGHTING	FLOOR MOUNTED	△
4'-8" SWEEP CEILING FAN		△
6'-6" SWEEP CEILING FAN		△
20A METAL CLAD SOCKET -A/C	8'-0" LVL	△
CHANDELIER LIGHT		△
NETWORK POINT		△
SURFACE MOUNT LED		△
LOCAL CONTROL BOARD	2'-0" LVL	△
LOCAL CONTROL BOARD	3'-0" LVL	△
LOW LEVEL LIGHT	1'-0" LVL	△
9" DIA EXHAUST FAN		△
WALL MOUNT FAN		△
WARDROBE LIGHT	7'-0" LVL	△

- NOTE**
1. CALLING BELL AT 8'-9" LEVEL (△)
 2. TELEPHONE OUTLET AT 2'-0" LEVEL (▽)
 3. LOCAL CONTROL BOARD AT 4'-6" LEVEL (△)
 4. LIGHT POINT AT 6" ABOVE LINTEL (△)
 5. CONTROL BOARD AT 2'-6" LVL (△)
 6. T.V OUTLET AT 2'-0" LEVEL WITH TWO 6AMP PLUG POINTS (△)
 7. CONTROL BOARD AT 3'-0" LVL (△)
 8. ALL LIGHT FIXTURES ARE LED
 9. A/C CONTROL AT 8' LEVEL (△)
 10. TELEPHONE, NETWORK, CABLE TV SOCKETS TO BE TERMINATED AT SUITABLE LOCATION FOR OUT SIDE CONNECTION FROM SERVICE PROVIDERS IF SATELLITE TV IS DECIDED THEN ALL THE TV CABLE TO BE TERMINATED AT SUITABLE POINT IN TERRACE

NOTES		REVISION SCHEDULE		
Rev No.	Date	Revisions	Rev by.	
1.		ALL DIMENSION ARE IN M.		
2.		THIS DRAWING IS TO BE READ AND NOT SCALED.		
3.		THIS DRAWING IS A COPYRIGHT AND PROPERTY OF THE ARCHITECT, IS NOT TO BE PRODUCED, HANDED OVER TO THIRD PARTY OR USED FOR ANY OTHER PURPOSE OTHER THAN FOR WHICH IT IS INTENDED.		

STRUCTURAL CONSULTANT	MEP CONSULTANT
UNIVERSAL CONSULTANTS New No.24, First Cross Street, Indira Nagar, Chennai - 600 020	AIR TREATMENT ENGINEERING PVT. LTD., L-6, 2nd WEST STREET, KAMARAJ NAGAR, THIRUVANMIYUR, CHENNAI-600 041. PHONE: +91 - 44 - 2441 2536, 2445 4891 FAX: +91 - 44 - 2445 4306

Proj.No. : 2214	AR-351.23
Scale : As Indicated	
Date : 26/06/23	
Rev.No. : R1	
Drawn by : DD	
Checked by : SS	

TENDER

BLOCK B- STILT FLOOR ELECTRICAL FIXTURE LAYOUT

 
shilpa
ARCHITECTS PLANNERS DESIGNERS PVT. LTD.

"The Muse"
L20, Dr. VSI Estate, Thiruvanniyur, Chennai 600 041.
Phone : 044 24542162 / 43358531 / 42696536
Email : studio@shilpaarchitects.com
Web site : www.shilpaarchitects.com



Indian Bank Residential Building At Mylapore

KEY PLAN



KEY

LEGEND		
5/15 A 3PIN SWITCHED SOCKET		Ⓜ
5A 3 PIN SWITCHED SOCKET		Ⓜ
MOTION SENSOR LIGHT		Ⓜ
LOCAL CONTROL BOARD	4'6" LVL	Ⓜ
DISTRIBUTION BOARD		Ⓜ
T.V ANTENNA SOCKET	2'0" LVL	Ⓜ
TELEPHONE SOCKET	2'0" LVL	Ⓜ
WALL BRACKET	6'6" ABOVE LINTEL	Ⓜ
CEILING DOME LIGHT FIXTURE		Ⓜ
BELL PUSH		Ⓜ
CALLING BELL	8'9" LVL	Ⓜ
BULK HEAD FITTING		Ⓜ
48" SWEEP CEILING FAN		Ⓜ
36" SWEEP CEILING FAN		Ⓜ
20A METAL CLAD SOCKET -A/C	6'0" LVL	Ⓜ
CHANDELLIER LIGHT		Ⓜ
NETWORK POINT		Ⓜ
SURFACE MOUNT LED		Ⓜ
LOCAL CONTROL BOARD	2'0" LVL	Ⓜ
LOCAL CONTROL BOARD	3'0" LVL	Ⓜ
LOW LEVEL LIGHT	1'0" LVL	Ⓜ
9" DIA EXHAUST FAN		Ⓜ
WALL MOUNT FAN	6'6" LVL	Ⓜ
WARDROBE LIGHT	7'0" LVL	Ⓜ

NOTE

1. CALLING BELL AT 8'-9" LEVEL (Ⓜ)

2. TELEPHONE OUTLET AT 2'-0" LEVEL (Ⓜ)

3. LOCAL CONTROL BOARD AT 4'-6" LEVEL (Ⓜ)

4. LIGHT POINT AT 6" ABOVE LINTEL LEVEL (Ⓜ)

5. CONTROL BOARD AT 2'-6" LVL (Ⓜ)

6. T.V OUTLET AT 2'-0" LEVEL WITH TWO 6AMP PLUG POINTS (Ⓜ)

7. CONTROL BOARD AT 3'-0" LVL (Ⓜ)

8. ALL LIGHT FIXTURES ARE LED

9. A/C CONTROL AT 8' LEVEL (Ⓜ)

10. TELEPHONE, NETWORK, CABLE TV SOCKETS TO BE TERMINATED AT SUITABLE LOCATION FOR OUT SIDE CONNECTION FROM SERVICE PROVIDERS IF SATELITE TV IS DECIDED THEN ALL THE TV CABLE TO BE TERMINATED AT SUITABLE POINT IN TERRACE

NOTES		REVISION SCHEDULE			
Rev No.	Date	Revisions	Rev by.		
1.		ALL DIMENSION ARE IN M.			
2.		THIS DRAWING IS TO BE READ AND NOT SCALED.			
3.		THIS DRAWING IS A COPYRIGHT AND PROPERTY OF THE ARCHITECT. IS NOT TO BE PRODUCED HANDED OVER TO THIRD PARTY OR USED FOR ANY OTHER PURPOSE OTHER THAN FOR WHICH IT IS INTENDED.			

STRUCTURAL CONSULTANT	MEP CONSULTANT
UNIVERSAL CONSULTANTS New No.24, First Cross Street, Indira Nagar, Chennai - 600 020	AIR TREATMENT ENGINEERING PVT. LTD., L-6, 2nd WEST STREET, KAMARAJ NAGAR, THIRUVANMIYUR, CHENNAI-600 041, PHONE: +91 - 44 - 2441 2536, 2445 4891 FAX: +91 - 44 - 2445 4306

Proj.No. : 2214	AR-351.27
Scale : As indicated	
Date : 04/07/23	
Rev.No. : R1	
Drawn by : DD	
Checked by : SS	

TENDER

BLOCK B- TERRACE FLOOR ELECTRICAL FIXTURE LAYOUT

shilpa ARCHITECTS PLANNERS DESIGNERS PVT. LTD.

"The Muse"

L20, Dr. VSI Estate, Thiruvannmyur, Chennai 600 041.

Phone : 044 24542162 / 43358531 / 42696536

Email : studio@shilpaarchitects.com

Web site : www.shilpaarchitects.com


Indian Bank Residential
Building At Mylapore

Indian Bank

Mylapore



KEY PLAN

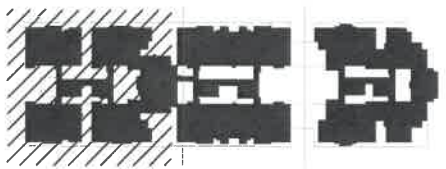

LEGEND

- LEGENDS**
- LIVING, DINING, BEDROOM - DOUBLE CHARGED VIRTRIFIED TILES
 - KITCHEN-DOUBLE CHARGED VIRTRIFIED TILES
 - TOILET- ANTI SKID TILES
 - UTILITY- ANTI SKID TILES
 - BALCONY-EXTERIOR GRADE ANTI SKID TILES
 - CORRIDOR- KOTA STONE
 - STAIRCASE AND CORRIDOR- GRANITE

NOTES		REVISION SCHEDULE			
1.	ALL DIMENSION ARE IN M.	Rev No.	Date	Revisions	Rev by.
2.	THIS DRAWING IS TO BE READ AND NOT SCALED.	R0	21-06-23	As per client comments	SR
3.	THIS DRAWING IS A COPYRIGHT AND PROPERTY OF THE ARCHITECT. IS NOT TO BE PRODUCED, HANDED OVER TO THIRD PARTY OR USED FOR ANY OTHER PURPOSE OTHER THAN FOR WHICH IT IS INTENDED.				

STRUCTURAL CONSULTANT	ELECTRICAL CONSULTANT
UNIVERSAL CONSULTANTS New No.24, First Cross Street, Indira Nagar, Chennai - 600 020	AIR TREATMENT ENGINEERING PVT. LTD. L-6, 2nd WEST STREET, KAMARAJ NAGAR, THIRUVANMIYUR, CHENNAI-600 041.PHONE:+91 - 44 - 2441 2536, 2445 4891 FAX: +91 - 44 - 2445 4306

PLUMBING CONSULTANT
AIR TREATMENT ENGINEERING PVT. LTD. L-6, 2nd WEST STREET, KAMARAJ NAGAR, THIRUVANMIYUR, CHENNAI-600 041.PHONE:+91 - 44 - 2441 2536, 2445 4891 FAX: +91 - 44 - 2445 4306

Proj.No. : 2214
Scale : As Indicated
Date : 28/04/23
Rev.No. : R0
Drawn by : DD
Checked by : SR

AR-351.17A




TENDER

Block A- FLOORING LAYOUT
PART 1/2

shilpa
ARCHITECTS PLANNERS DESIGNERS PVT. LTD.
"The Muse"
L20, Dr. VSI Estate, Thiruvanniyur, Chennai 600 041.
Phone : 044 24542162 / 43358531 / 42696536
Email : studio@shilpaarchitects.com
Web site : www.shilpaarchitects.com

REFER
AR-351.17b
For
Block A
Part-2
Typical
Floor Plan

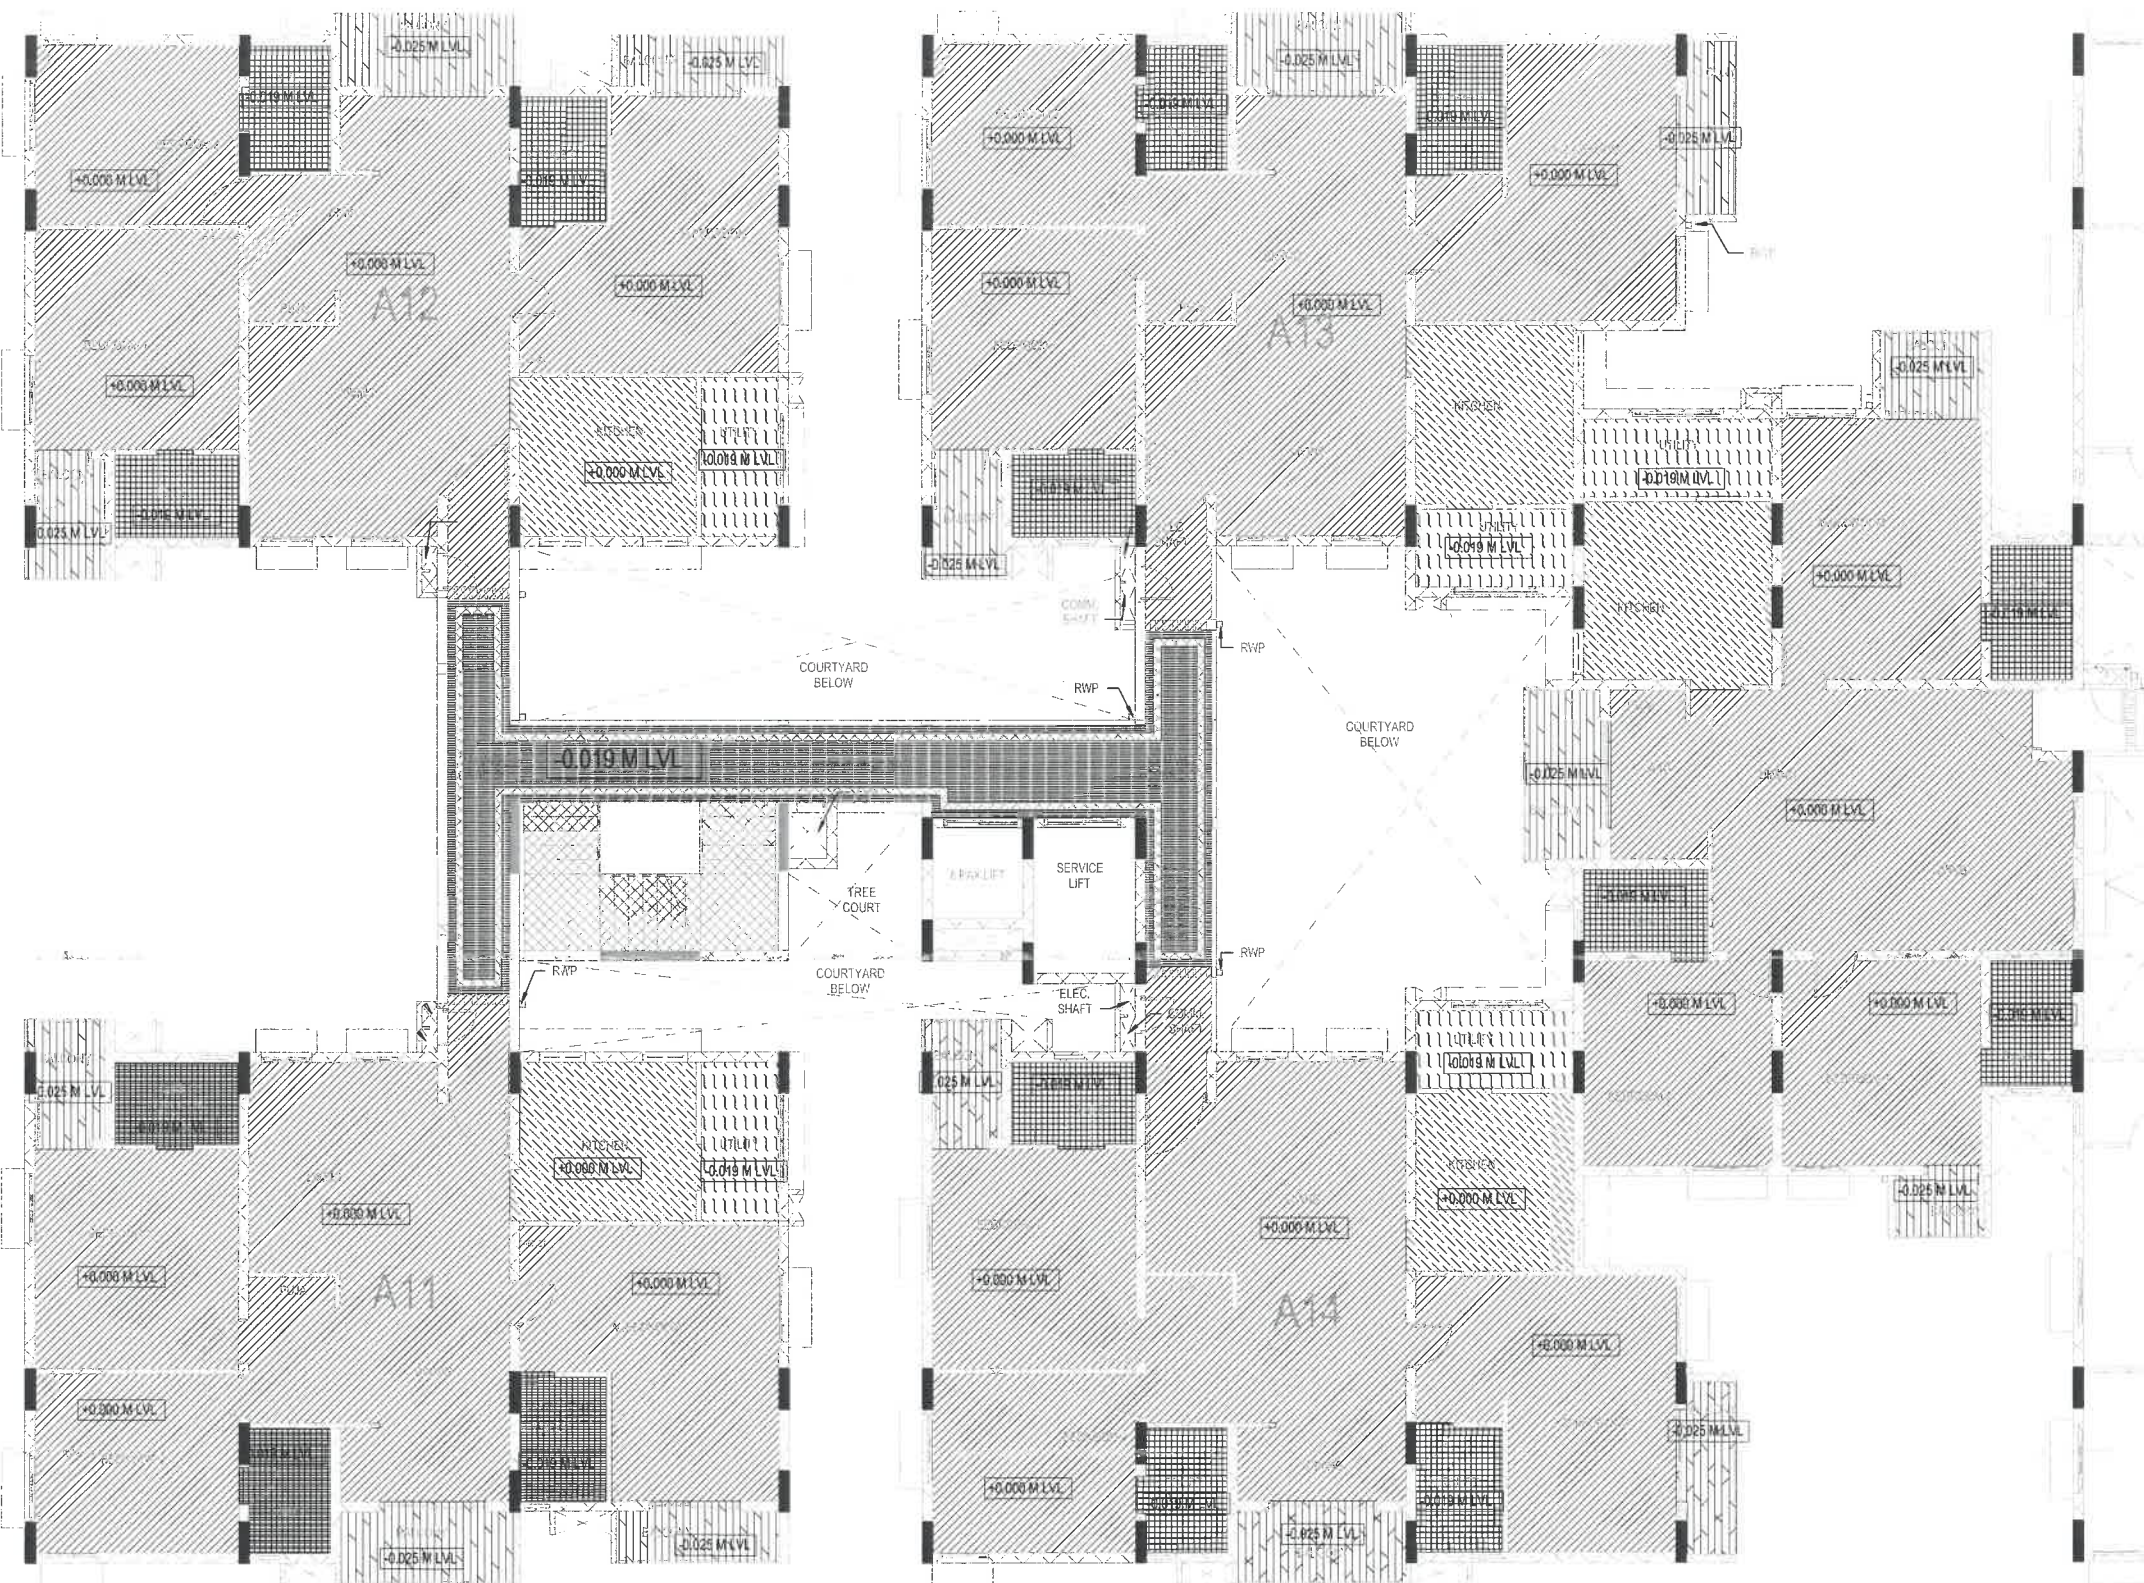

BLOCK A - TYPICAL FLOOR PLAN PART
1
1:75

Indian Bank Residential Building At Mylapore

Indian Bank

Mylapore



KEY PLAN



LEGEND

LEGENDS

- LIVING, DINING, BEDROOM -DOUBLE CHARGED VIRTRIFIED TILES
- KITCHEN-DOUBLE CHARGED VIRTRIFIED TILES
- TOILET- ANTI SKID TILES
- UTILITY- ANTI SKID TILES
- BALCONY-EXTERIOR GRADE ANTI SKID TILES
- CORRIDOR- KOIA STONE
- STAIRCASE AND CORRIDOR- GRANITE

NOTES

- ALL DIMENSION ARE IN M.
- THIS DRAWING IS TO BE READ AND NOT SCALED.
- THIS DRAWING IS A COPYRIGHT AND PROPERTY OF THE ARCHITECT, IS NOT TO BE PRODUCED, HANDED OVER TO THIRD PARTY OR USED FOR ANY OTHER PURPOSE OTHER THAN FOR WHICH IT IS INTENDED.

REVISION SCHEDULE

Rev No.	Date	Revisions	Rev by.
R0	21-06-23	As per client comments	SR

STRUCTURAL CONSULTANT

UNIVERSAL CONSULTANTS
New No.24, First Cross Street, Indira Nagar,
Chennai - 600 020

ELECTRICAL CONSULTANT

AIR TREATMENT ENGINEERING PVT. LTD.
L-6, 2nd WEST STREET, KAMARAJ
NAGAR, THIRUVANMIYUR, CHENNAI-600
041.PHONE:+91 - 44 - 2441 2536, 2445 4891
FAX: +91 - 44 - 2445 4306

PLUMBING CONSULTANT

AIR TREATMENT ENGINEERING PVT. LTD.
L-6, 2nd WEST STREET, KAMARAJ
NAGAR, THIRUVANMIYUR, CHENNAI-600
041.PHONE:+91 - 44 - 2441 2536, 2445 4891
FAX: +91 - 44 - 2445 4306

Proj.No. : 2214
Scale : As indicated
Date : 28/04/23
Rev.No. : R0
Drawn by : DD
Checked by : SS

AR-351.17A



TENDER


Block A- FLOORING LAYOUT PART 2/2

shilpa

ARCHITECTS PLANNERS DESIGNERS PVT. LTD.

"The Muse"
L20, Dr. VSI Estate, Thiruvanniyur, Chennai 600 041.
Phone : 044 24542162 / 43358531 / 42696536
Email : studio@shilpaarchitects.com
Web site : www.shilpaarchitects.com

REFER
AR-351.17b
For
Block A
Part-1
Typical
Floor Plan

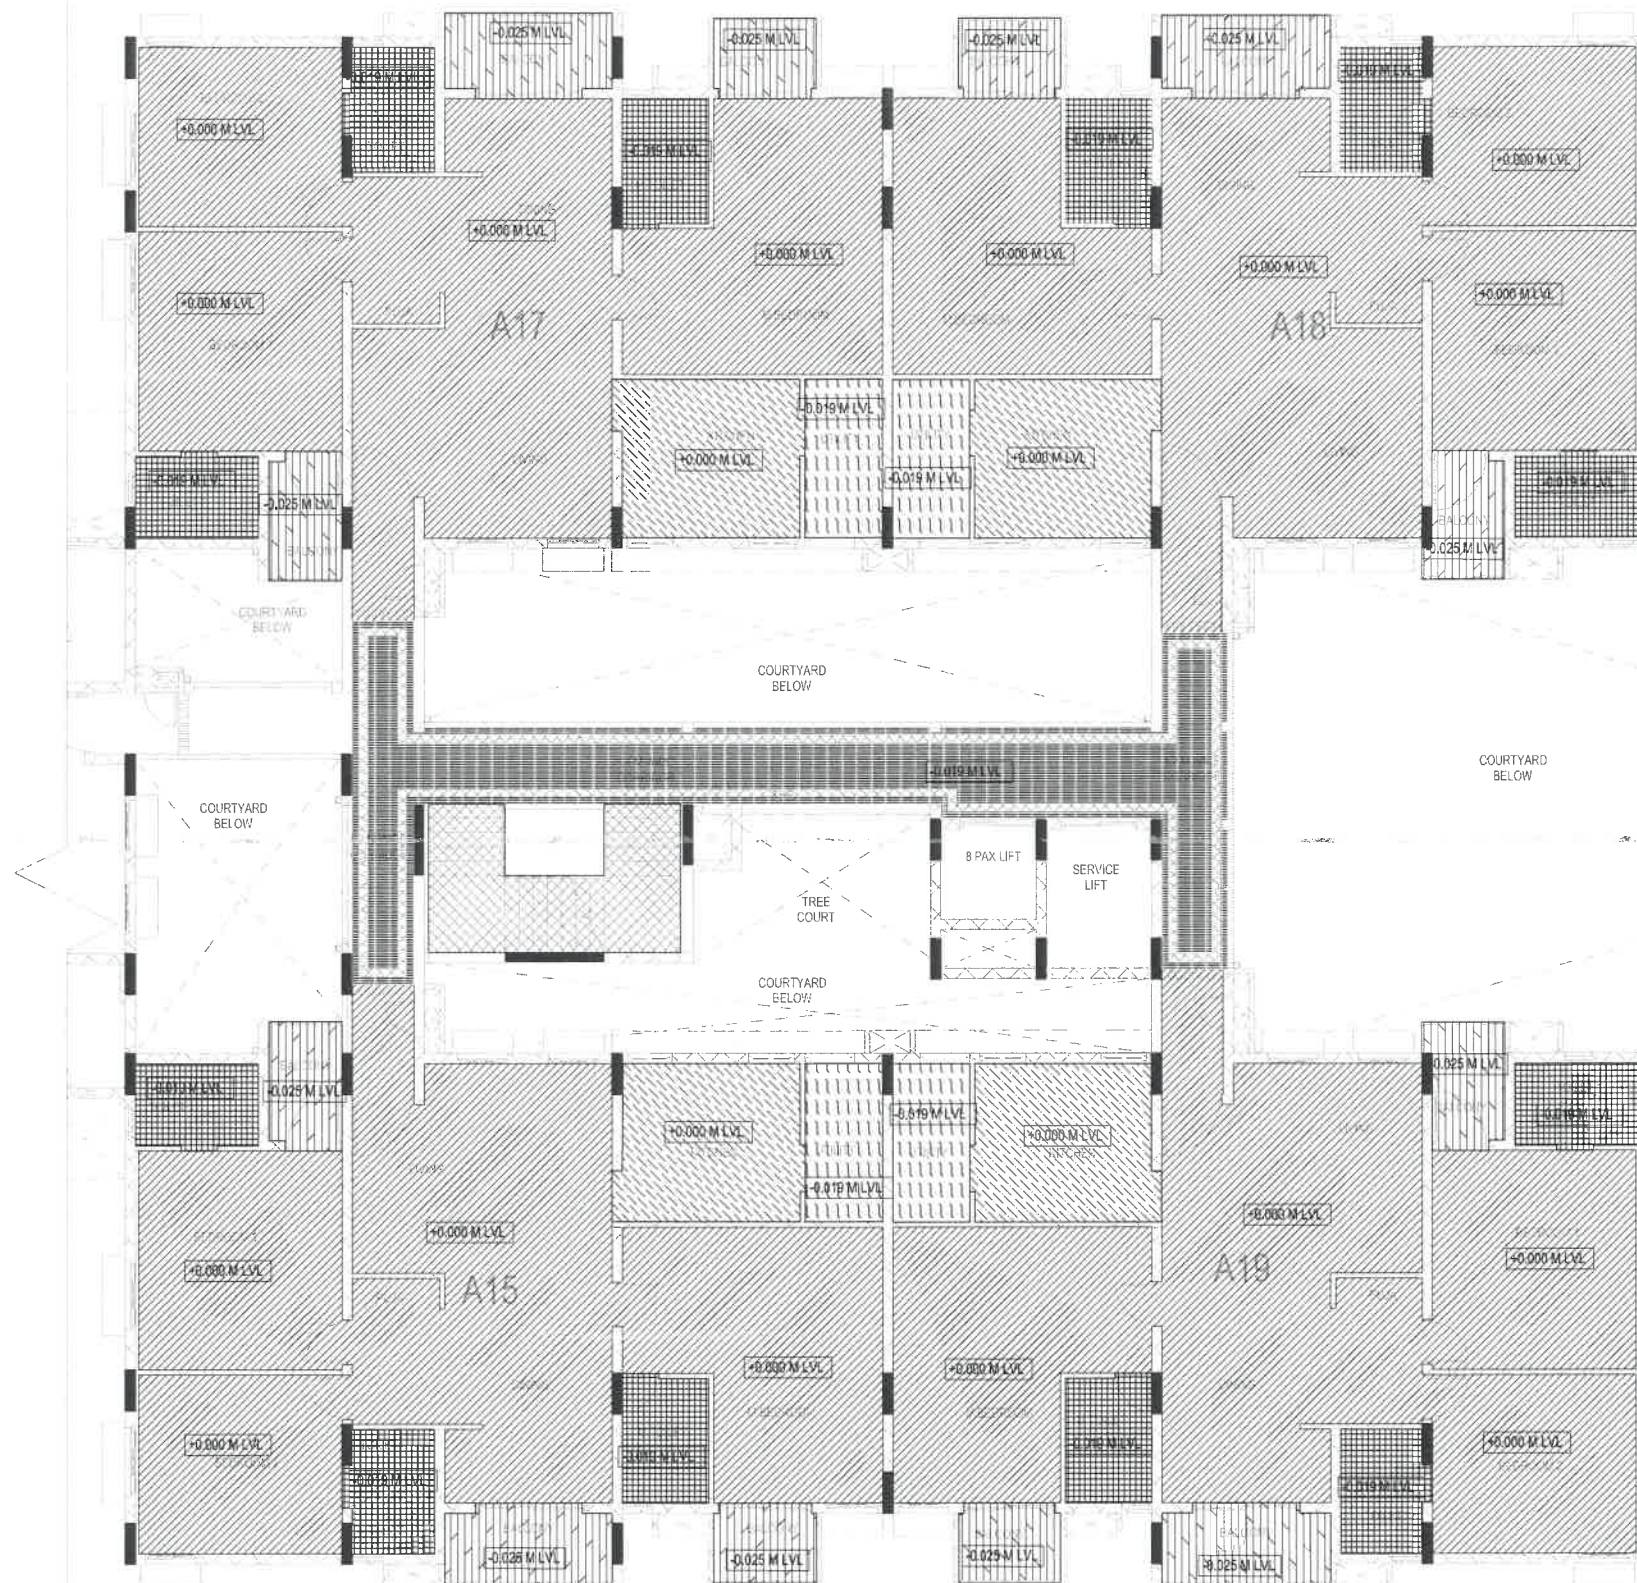

REFER
AR-351.18
FOR
BLOCK B
TYPICAL
FLOOR
PLAN

BLOCK A - TYPICAL FLOOR PLAN PART

1 2
1:75


Indian Bank Residential Building At Mylapore

Indian Bank

Mylapore



KEY PLAN

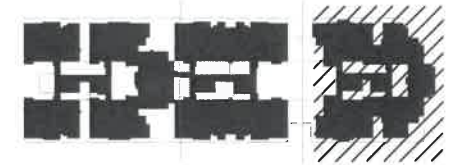

LEGEND

LEGENDS

- LIVING, DINING, BEDROOM - DOUBLE CHARGED VIRTRIFIED TILES
- KITCHEN-DOUBLE CHARGED VIRTRIFIED TILES
- TOILET- ANTI SKID TILES
- UTILITY- ANTI SKID TILES
- BALCONY-EXTERIOR GRADE ANTI SKID TILES
- CORRIDOR- KOTA STONE
- STAIRCASE AND CORRIDOR- GRANITE

NOTES

- ALL DIMENSION ARE IN M.
- THIS DRAWING IS TO BE READ AND NOT SCALED.
- THIS DRAWING IS A COPYRIGHT AND PROPERTY OF THE ARCHITECT, IS NOT TO BE PRODUCED, HANDED OVER TO THIRD PARTY OR USED FOR ANY OTHER PURPOSE OTHER THAN FOR WHICH IT IS INTENDED.

REVISION SCHEDULE

Rev No.	Date	Revisions	Rev by.
R0	21-05-23	As per client comments	SR

STRUCTURAL CONSULTANT

UNIVERSAL CONSULTANTS
New No.214, First Cross Street, Indra Nagar,
Chennai - 600 020

ELECTRICAL CONSULTANT

AIR TREATMENT ENGINEERING PVT. LTD.,
L-6, 2nd WEST STREET, KAMARAJ
NAGAR, THIRUVANMIYUR, CHENNAI-600
041.PHONE:+91 - 44 - 2441 2536, 2445 4891
FAX: +91 - 44 - 2445 4306

PLUMBING CONSULTANT

AIR TREATMENT ENGINEERING PVT. LTD.,
L-6, 2nd WEST STREET, KAMARAJ
NAGAR, THIRUVANMIYUR, CHENNAI-600
041.PHONE:+91 - 44 - 2441 2536, 2445 4891
FAX: +91 - 44 - 2445 4306

Proj.No. : 2214
Scale : As Indicated
Date : 28/04/23
Rev.No. : R0
Drawn by : DD
Checked by : SS

AR-351.18



TENDER


Block B- FLOORING LAYOUT

shilpa

ARCHITECTS PLANNERS DESIGNERS PVT. LTD.

"The Muse"
L20, Dr. VSI Estate, Thiruvanniyur, Chennai 600 041.
Phone : 044 24542162 / 43358531 / 42896536
Email : studio@shilpaarchitects.com
Web site : www.shilpaarchitects.com

REFER
AR-351.17b
For
Block A
Part-2 Typical
Floor Plan

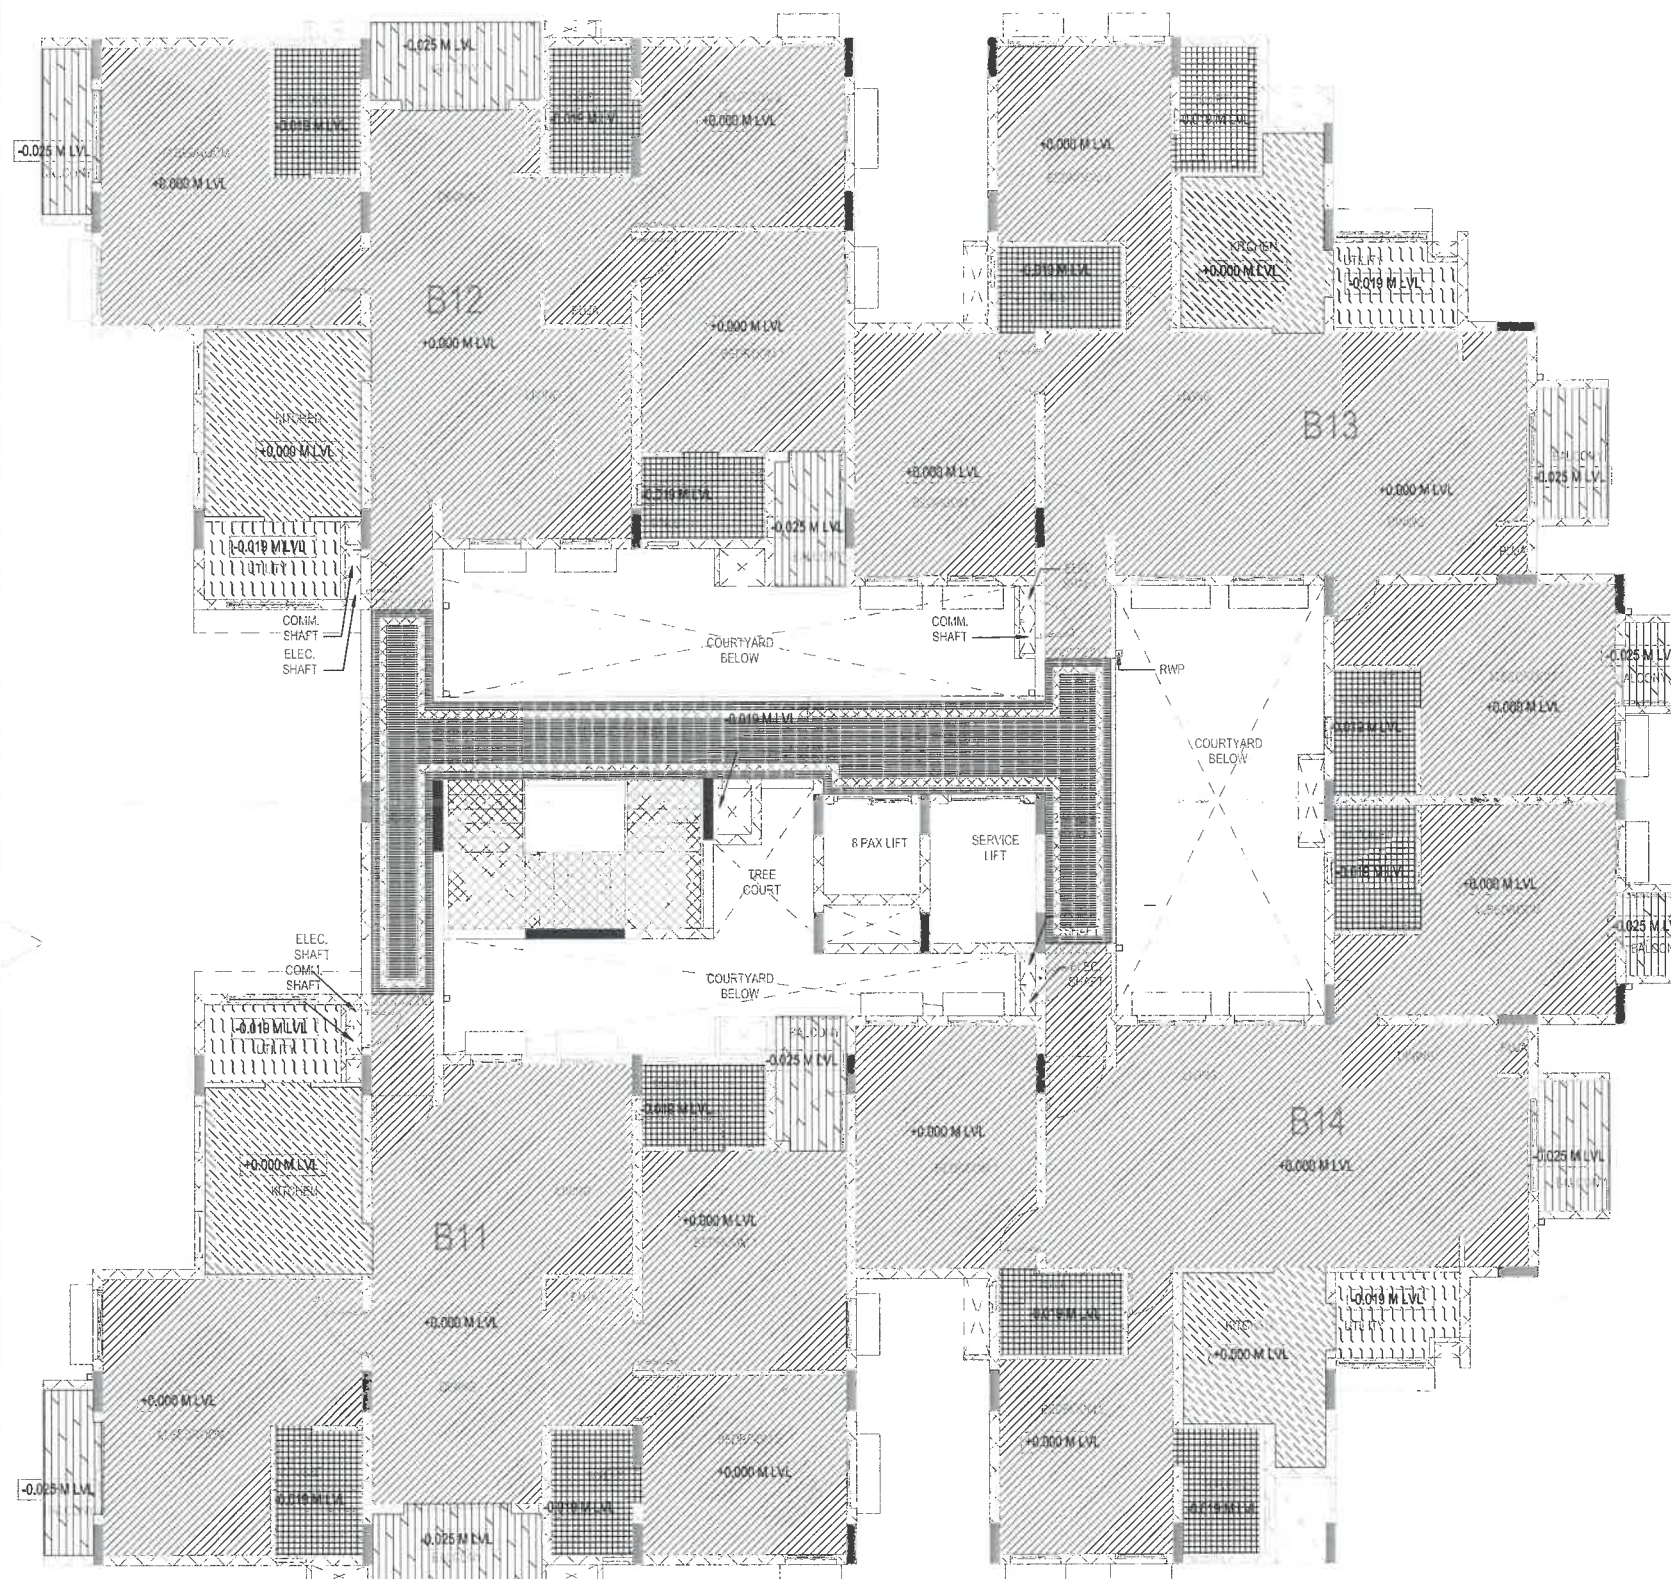

BLOCK B - TYPICAL FLOOR PLAN PART

1 3
1:75



S+5

NOTES:-


1. REFER ARCHITECTURAL DRAWING FOR CENTER LINE DIMENSION
2. ONLY MATERIAL DIMENSION TO BE FOLLOWED.
3. ALL DIMENSIONS IN THE DRAWING SHALL BE BROUGHT TO OUR NOTICE IMMEDIATELY.
4. THIS DRAWING SHOULD BE READ ALONG WITH ARCHITECTURAL DRAWINGS.
5. GRADE OF CONCRETE SHALL CONFORM TO IS 456
6. M20 FOR COLUMN & SHEAR WALL
7. M25 FOR ALL OTHER RCC WORKS
8. M20 FOR ALL OTHER RCC WORKS
9. M20 FOR ALL OTHER RCC WORKS
10. M20 FOR ALL OTHER RCC WORKS
100. M20 FOR ALL OTHER RCC WORKS

NOTES:-1:-

B1=200x700
B2=BEAM DEPTH SHOULD BE MATCH WITH LINTEL LEVEL
ALL OTHER BEAM SIZES ARE 200X600 UNLESS OTHERWISE SPECIFIED
ALL OTHER SLAB THICKNESS ARE 120TK. UNLESS OTHERWISE SPECIFIED

TOILET
BALCONY
UTILITY
OPEN TERRACE

SLAB NO.	SLAB THICKNESS
S1	120TK
S2	200TK
S3	150TK
S4	150TK
S5	150TK
S6	150TK
S7	150TK

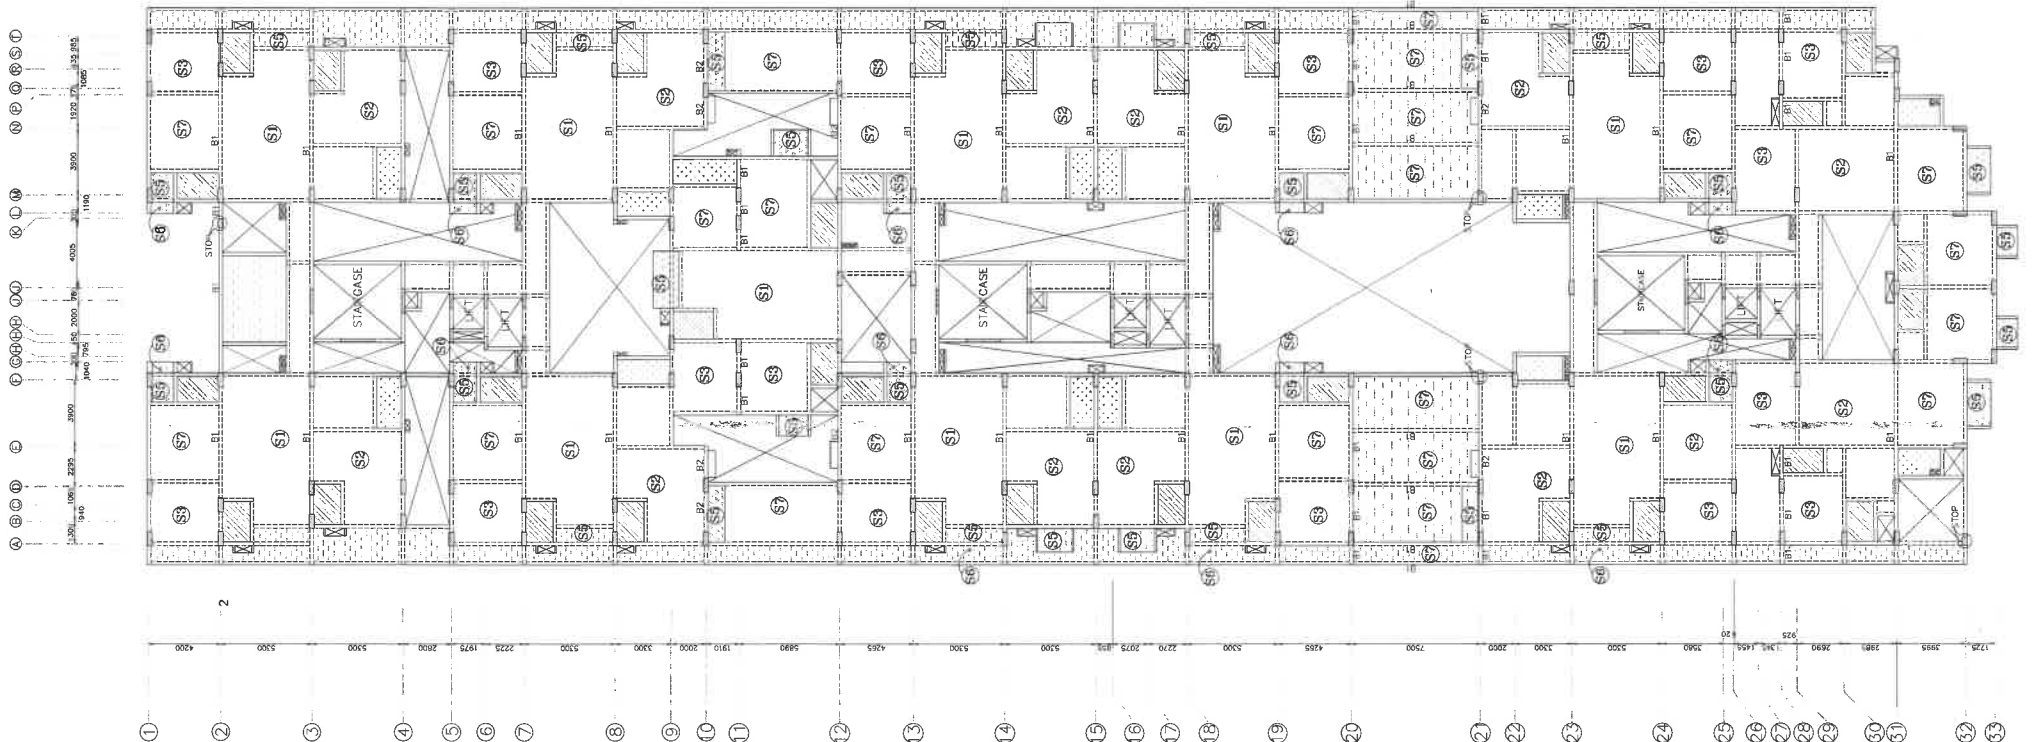

STRUCTURAL CONSULTANT

UNIVERSAL CONSULTANTS
CIVIL & STRUCTURAL CONSULTING ENGINEERS
Dr.J.SURESH.M.E., MIE., Ph.D

project@universalconsultants.net
www.universalconsultants.net

PROJECT NAME:
PROPOSED RESIDENTIAL BUILDING FOR
INDIAN BANK

DWG NO:
UC-1152-PROPOSED RESIDENTIAL BUILDING
FOR INDIAN BANK

DRAWING TITLE :
STILT FLOOR ROOF LAYOUT-
BEAM NUMERATION



S+5

NOTES:-


1. REFER ARCHITECTURAL DRAWING FOR CENTER LINE DIMENSION
2. ONLY WRITTEN DIMENSION TO BE FOLLOWED.
3. ANY DISCREPANCY NOTICED IN THE Dwg. SHALL BE REPORTED TO THE ARCHITECT IMMEDIATELY.
4. THE DRAWING SHOULD BE READ ALONG WITH ARCHITECTURAL DRAWINGS.
5. GRADE OF CONCRETE SHALL CONFORM TO IS 456
6. "Y" DENOTES HIGH STRENGTH REINFORCED BARS OF GRADE 456
7. CLEAR COVER TO THE MAIN STEEL
8. FOR FOOTINGS, -100T SLABS & RAFT BEAMS.
9. FOR BEAMS & LINTLS.
10. FOR SLAB & SUNSHADE.
11. FOR RCC WALL.
12. ALL LAPS IN REINFORCEMENT SHALL BE WELDED TO AN EXTENT OF 10 DIA OF THE BAR
13. (4 TO 10 DIA WELDED JOINT GAP AND 10 DIA WELD) OR LAPPED WITH THE WELDING.
14. BOTTOM COVER TO THE REINFORCEMENT CASE MUST BE 200mm.
15. THE REQUIRED ANCHORAGE MUST BE DONE INITIALLY.
16. SPACER BAR TO BE PROVIDED IN BETWEEN TWO LAYERS
17. OF REINFORCEMENT OF SAME DIA AT EVERY 1000 C/ C.
18. HOWEVER THE FOLLOWING MINIMUM PERIOD (AFTER FINAL POUR) SHALL BE ALLOWED BEFORE REMOVAL OF SHUTTERING AS PER CLAUSE 11.3.1.1. 6-456
19. A) VERTICAL SIZE SHUTTERING OF COLUMNS/WALLS & BEAMS- 24HOURS
20. B) BOTTOM SHUTTERING OF SLABS (KEEPING THE PROPS)- 3 DAYS
21. C) BOTTOM SHUTTERING OF BEAMS (KEEPING THE PROPS)- 7 DAYS
22. D) PROPS TO SLABS : 1. 4.5 M (15'-0") - 7 DAYS
23. 2. 4.5 M (15'-0") - 14 DAYS
24. E) PROPS TO BEAMS AND ARCHES : 1. 4.5 M (15'-0") - 7 DAYS
25. 2. 4.5 M (15'-0") - 14 DAYS
26. F) BEAMS AND ARCHES SPACING UP TO 6 M (20'-0") - 7 DAYS
27. G) BEAMS AND ARCHES SPACING OVER 6 M (20'-0") - 21 DAYS
28. H) CANTILEVER PROPS SHOULD NOT BE RELEASED UNTIL THE ROOF IS CONCRETED.
29. 10. FOR EMPLOYMENT ANALYSIS IS TAKEN AS PER IS : 1803
30. 11. LAP JOINTS FOR REINFORCEMENT BARS : (a) AT ANY CROSS SECTION OF THE MEMBER NOT MORE THAN SIZE OF THE BARS SHALL BE LAPTED.
31. (b) LAPS SHALL BE STAGGERED WITH A MINIMUM COVER TO CENTRE REINFORCE
32. (c) LAPS SHALL BE STAGGERED WITH A MINIMUM COVER TO CENTRE REINFORCE
33. (d) LAPS IN COLUMNS SHALL BE PROVIDED AT MID HEIGHT OF FLOOR AND NOT AT BEAM COLUMN JUNCTION
34. (e) LAPS IN BEAMS AND SLABS SHALL BE PROVIDED PREFERABLY AT POINT OF CONTRADICTION.
35. 12. HOOK LENGTH OF STIRRUPS 10 DIA (> 75mm)
36. 13. BEAM COLUMN JUNCTION STIRRUPS SPACING SHOULD BE 100mm (ØB) 4"
37. UNLESS OTHERWISE SPECIFIED IN THE DRAWING

NOTES-1:-

B1=200x700
B2=BEAM DEPTH SHOULD BE MATCH WITH LINTEL LEVEL
ALL OTHER BEAM SIZES ARE 200x600 UNLESS OTHERWISE SPECIFIED
ALL OTHER SLAB THICKNESS ARE 120TK. UNLESS OTHERWISE SPECIFIED

	TOILET
	BALCONY
	UTILITY

SLAB NO.	SLAB THICKNESS
S1	200TK.
S2	200TK.
S3	130TK.
S4	150TK.
S5	150TK.
S6	150TK.
S7	150TK.

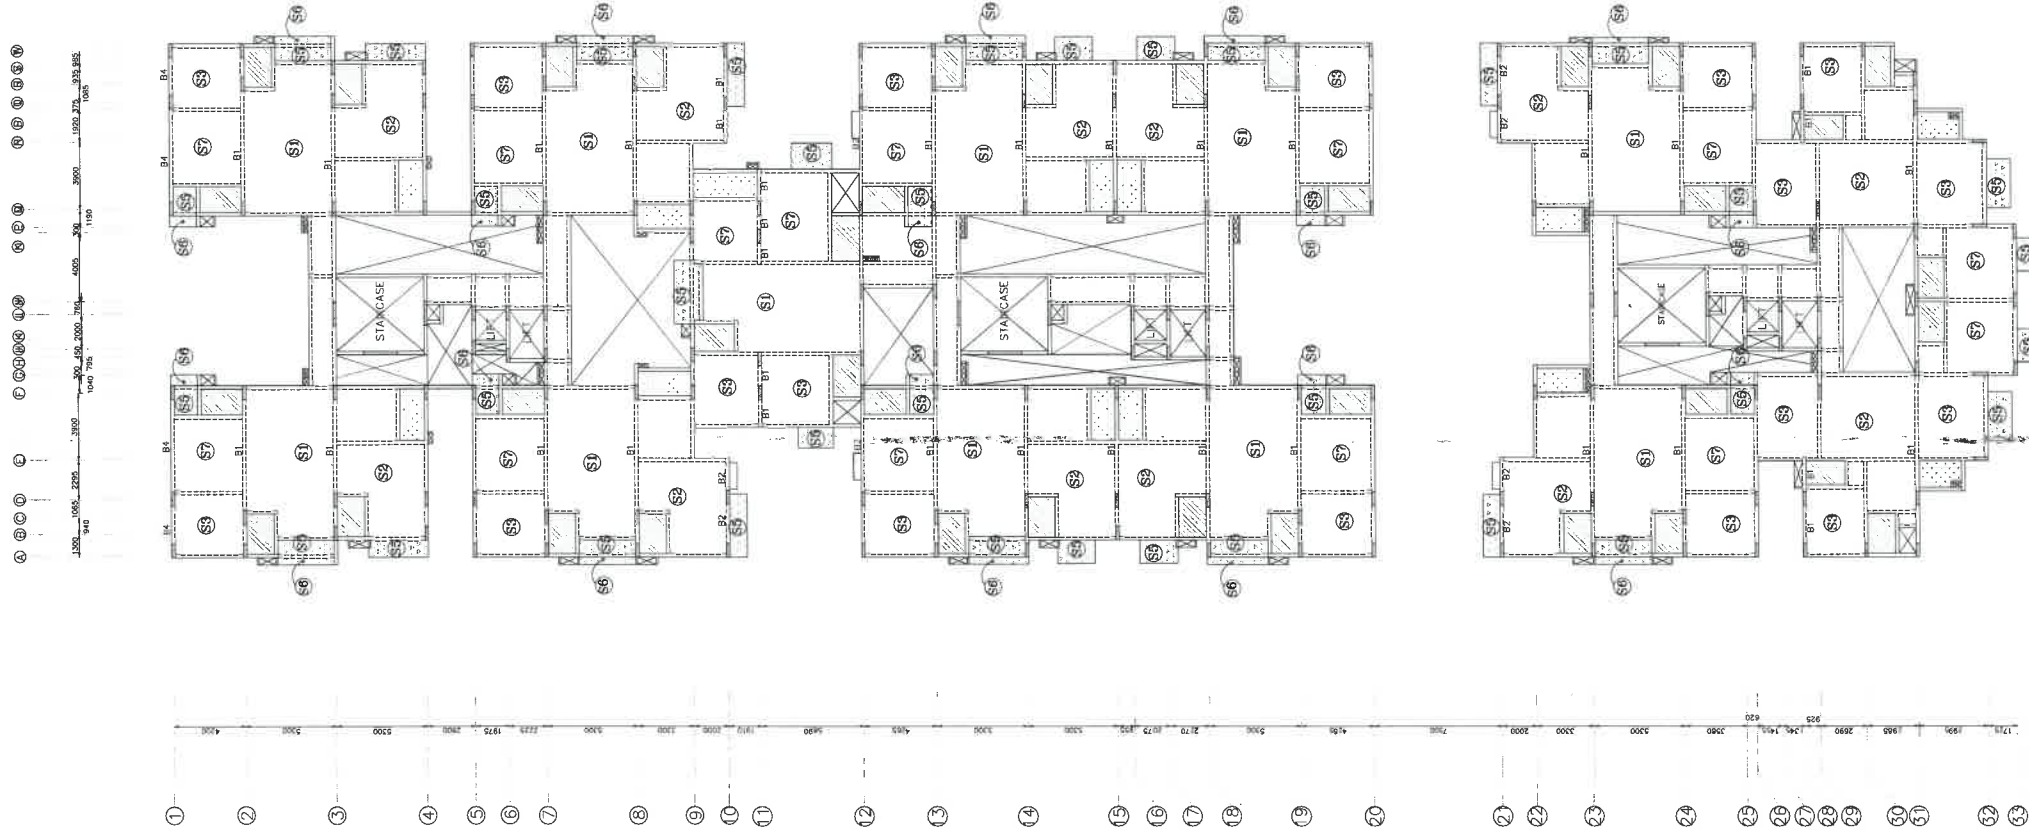

R12	REVISED AS PER INSTRUCTION	10-07-23
R11	REVISED AS PER INSTRUCTION	04-07-23
R10	REVISED AS PER INSTRUCTION	01-07-23
R9	REVISED AS PER INSTRUCTION	21-04-23
R8	REVISED AS PER INSTRUCTION	20-04-23
R7	CLOUDED AREA REVISED AS PER INST	09-03-23
R6	BEAM NUMERATION	06-03-23
R5	REVISED AS PER INSTRUCTION	22-02-23
R4	REVISED FOR UPDATED ARCH DWG.	08-02-23
R3	REVISED AS PER INSTRUCTION	15-12-22
R2	REVISED AS PER INSTRUCTION	10-12-22
R1	REVISED AS PER INSTRUCTION	08-12-22

Date: 28-11-22 Drawn By: SANKAR

CLIENT

ARCHITECT

STRUCTURAL CONSULTANT

UNIVERSAL CONSULTANTS
CIVIL & STRUCTURAL CONSULTING ENGINEERS
Dr.J.SURESH.M.E., MIE., Ph.D

project@universalconsultants.com
www.universalconsultants.net





LANDLINE-044-24455865, 8938397579.

PROJECT NAME:
PROPOSED RESIDENTIAL BUILDING FOR
INDIAN BANK

DWG NO:
UC-1152-PROPOSED RESIDENTIAL BUILDING
FOR INDIAN BANK

DRAWING TITLE :

TYPICAL FLOOR ROOF LAYOUT-
BEAM NUMERATION

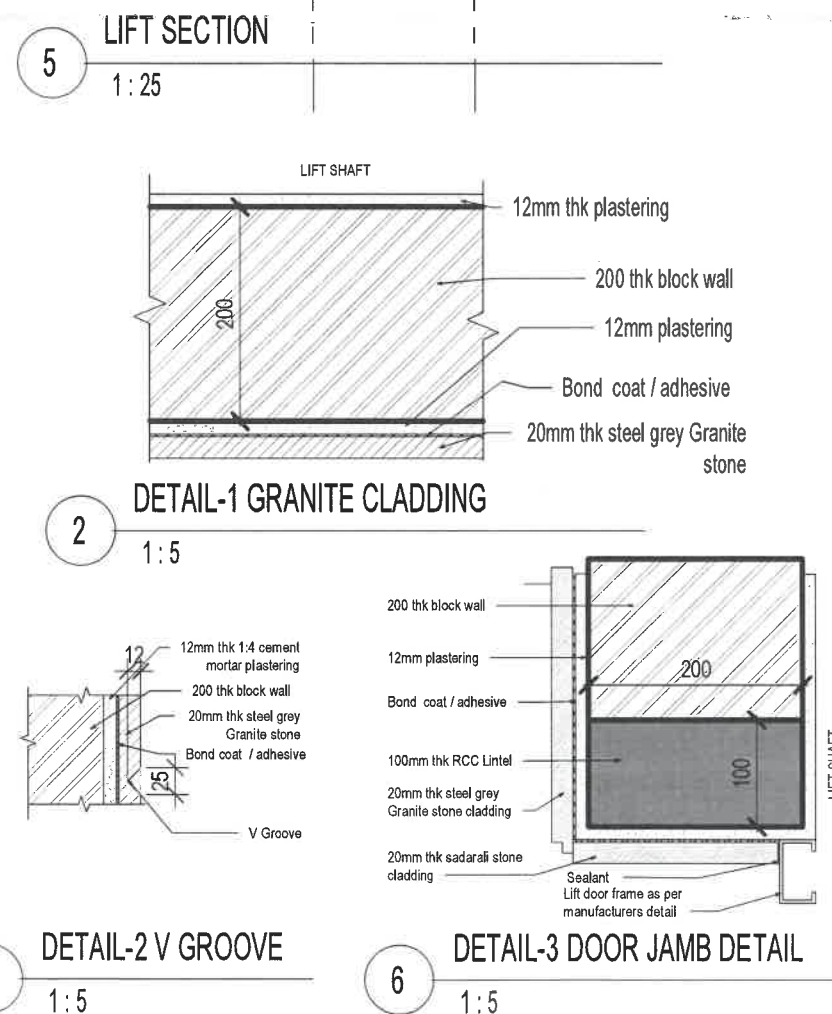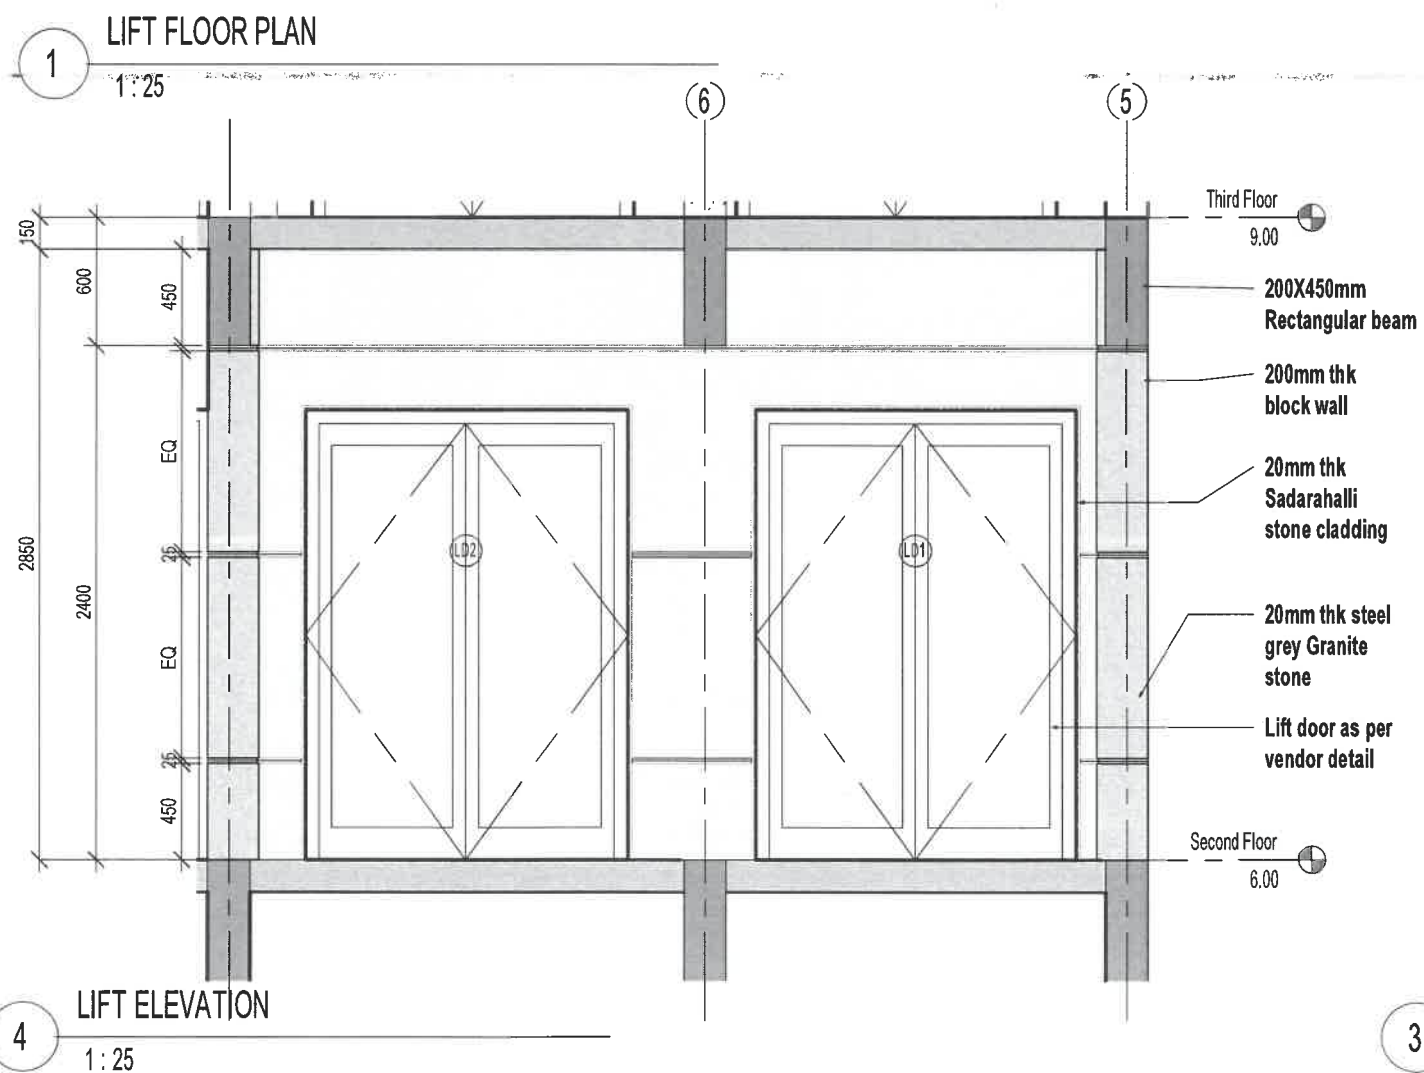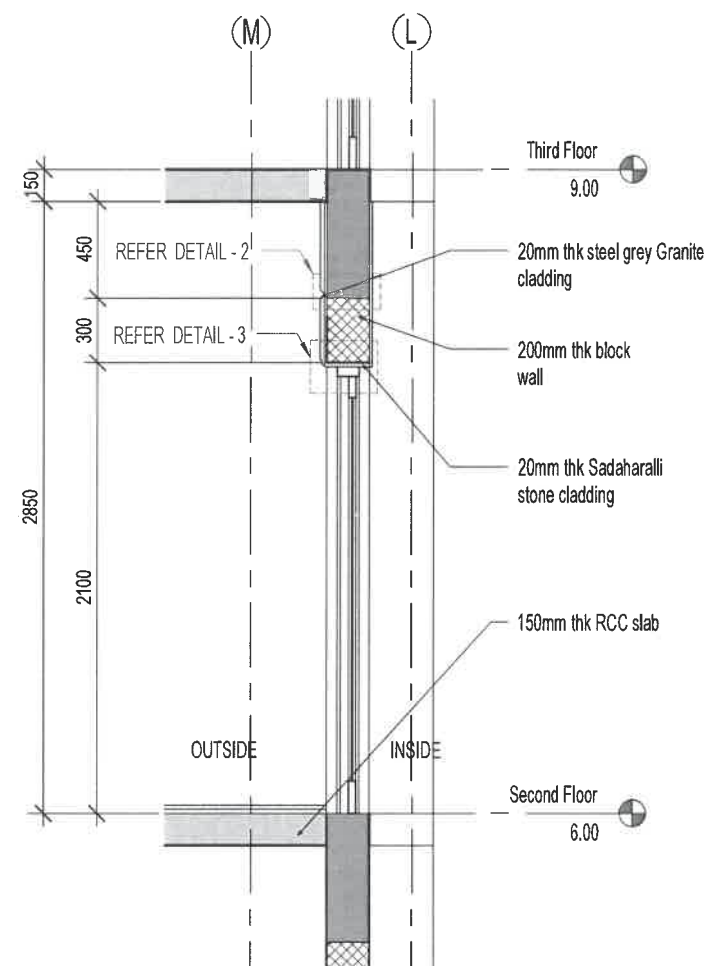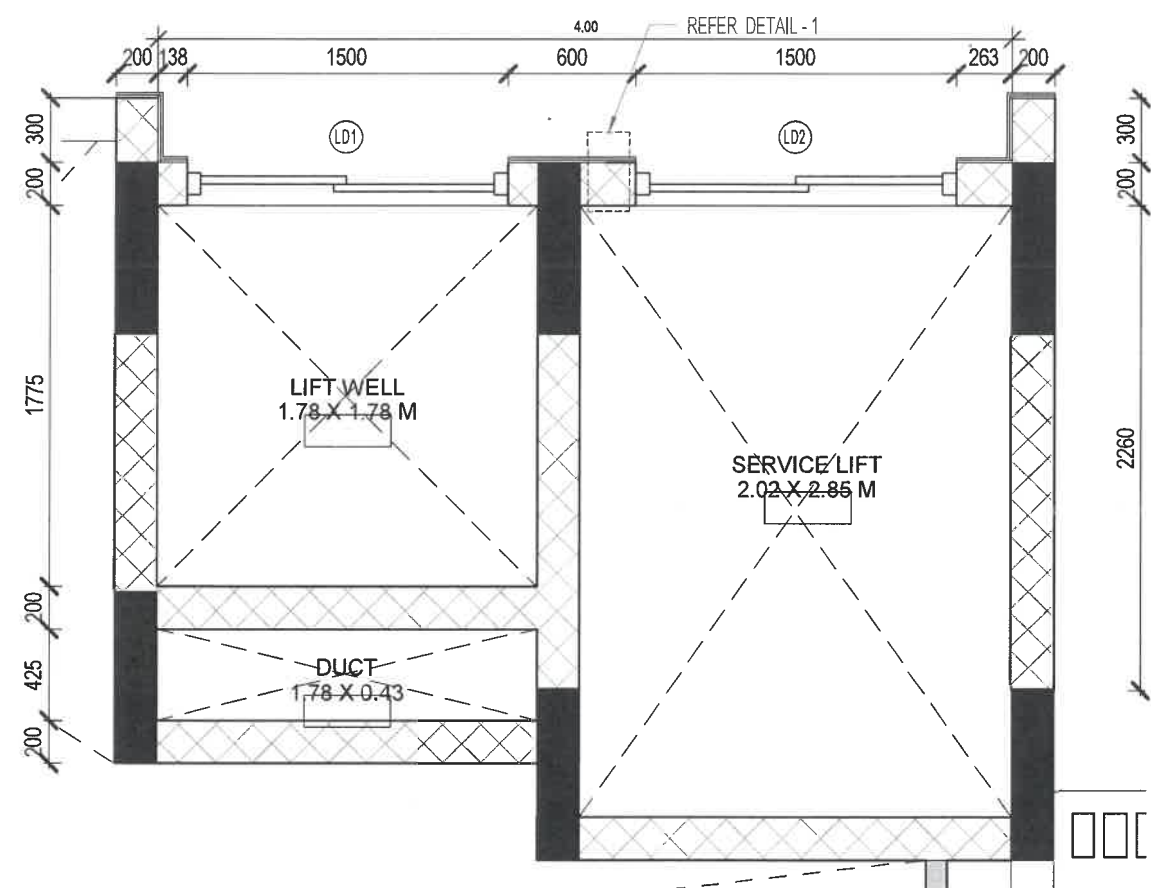


Indian Bank Residential Building At Mylapore

Mylapore



KEY PLAN

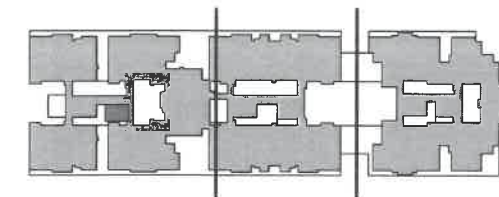

SCHEDULE OF OPENINGS

Proj.No.	: 2214
Scale	: As indicated
Date	: 04/07/23
Rev.No.	: R0
Drawn by	: Author
Checked by	: Checker

AR-351.21

TENDER DRAWING-
ARCHITECTURAL

LIFT CLADDING DETAIL

shilpa
ARCHITECTS PLANNERS DESIGNERS PVT. LTD.

"The Muse"
L20, Dr. VSI Estate, Thiruvannmiyur, Chennai 600 041.
Phone : 044 24542162 / 43358531 / 42696536
Email : studio@shilpaarchitects.com
Web site : www.shilpaarchitects.com

C:\Users\tarak\Desktop\SHILPA\INDIAN
BANK\2214_30June23 Tender_FF To Headroom V1 R2 V1 R0.rvt

Indian Bank Residential Building At Mylapore

Indian Bank

Mylapore



KEY PLAN

SCHEDULE OF OPENINGS

Door Schedules - Typical Floor				
Type Mark	Description	Width	Height	Lintel
D1	DOOR WITH OPENABLE MOSQUITO MESH	1.20	2.10	2.10
D2	DOOR	0.90	2.10	2.10
D3	DOOR	0.75	2.10	2.10

NOTES

- ALL DIMENSION ARE IN MM.
- THIS DRAWING IS TO BE READ AND NOT SCALED.
- THIS DRAWING IS A COPYRIGHT AND PROPERTY OF THE ARCHITECT. IT IS NOT TO BE PRODUCED, HANDED OVER TO THIRD PARTY OR USED FOR ANY OTHER PURPOSE OTHER THAN FOR WHICH IT IS INTENDED.

REVISION SCHEDULE

Rev No.	Date	Revision	Rev by.
01	04/07/23	Based on client's remarks	DD

STRUCTURAL CONSULTANT

UNIVERSAL CONSULTANTS
New No.2/4, First Cross Street, Indira Nagar,
Chennai - 600 020

MEP CONSULTANT

AIR TREATMENT ENGINEERING PVT. LTD.,
L-6, 2nd WEST STREET, KAMARAJ
NAGAR, THIRUVANMIYUR, CHENNAI-600
041. PHONE: +91 - 44 - 2441 2536, 2445 4891
FAX: +91 - 44 - 2445 4306

Proj.No. : 2214
Scale : As indicated
Date : 04/07/23
Rev.No. : R0
Drawn by : DD
Checked by : SS

AR-351.20



TENDER DRAWING- ARCHITECTURAL


JOINERY DETAIL - DOOR DETAIL

shilpa

ARCHITECTS PLANNERS DESIGNERS PVT. LTD.


"The Muse"
L20, Dr. VSI Estate, Thiruvanniyur, Chennai 600 041.
Phone : 044 24542162 / 43358531 / 42696536
Email : studio@shilpaarchitects.com
Web site : www.shilpaarchitects.com

C:\Users\jorah\Desktop\SHILPA\PROJECTS\2214_10 Line 23_10m-ar_FF to 10m-room_V1.rvt
V1 R0.rvt

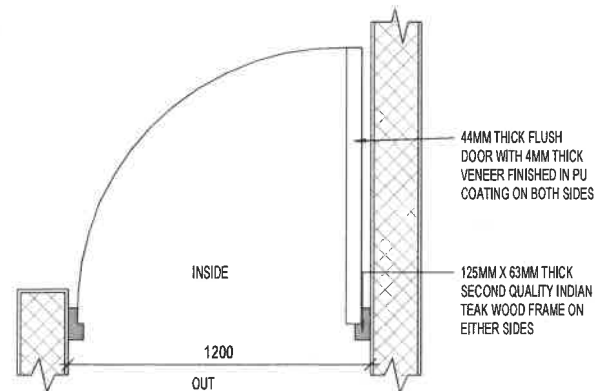


D1- MAIN DOOR PLAN VIEW

1:15

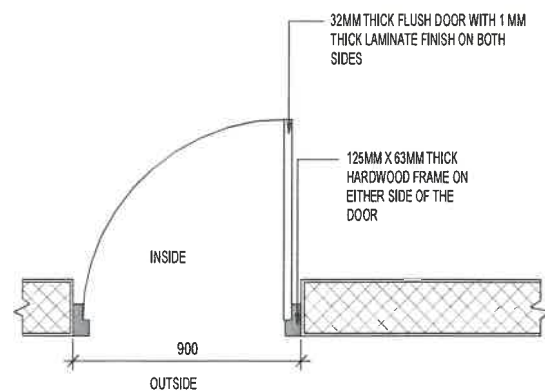


D2- BEDROOM DOOR PLAN

1:15

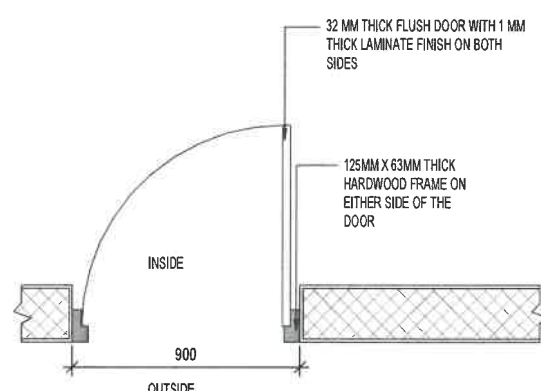


D2- KITCHEN DOOR PLAN

1:15

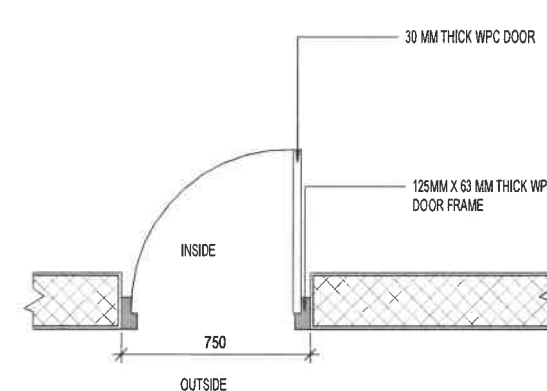


D3- TOILET DOOR PLAN

1:15

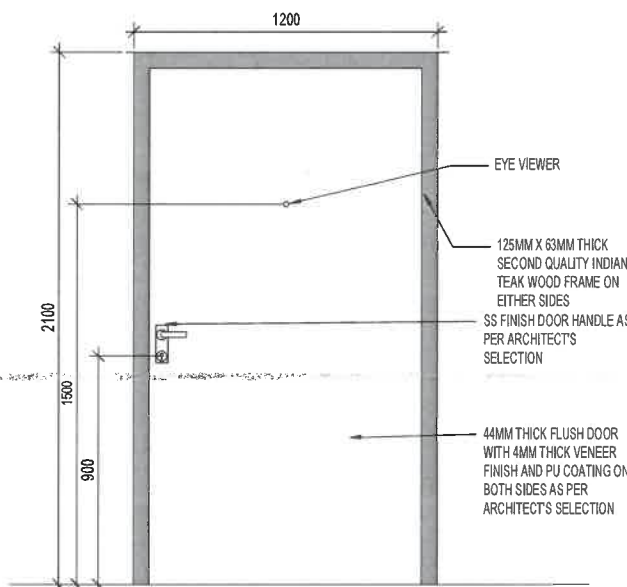


D1- MAIN DOOR ELEVATION

1:15

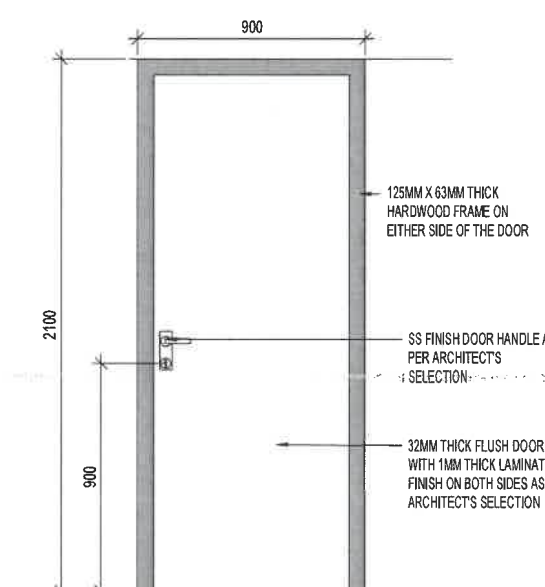


D2- BEDROOM DOOR ELEVATION

1:15

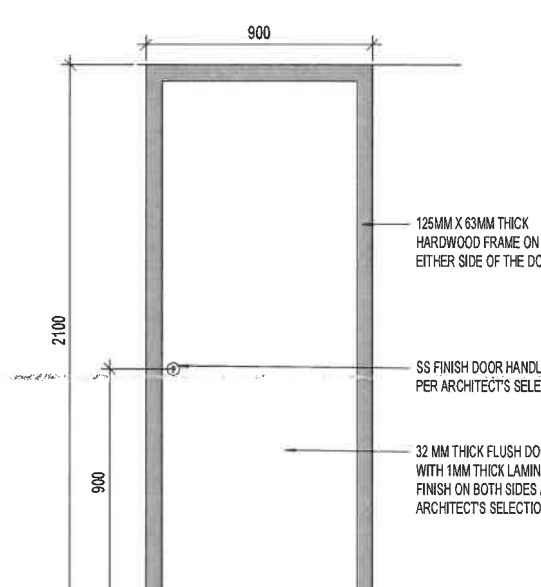

D2- KITCHEN DOOR ELEVATION

1:15

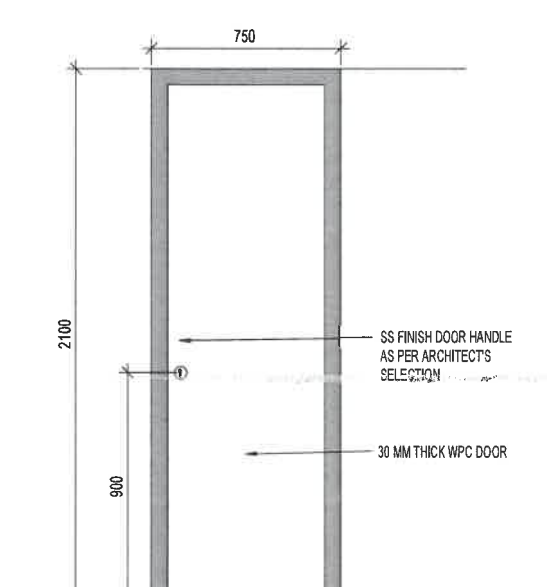

D3- TOILET DOOR ELEVATION


1:15

S.NO	DESCRIPTION	SPECIFICATION	QUANTITY
1	LOCK	Bright Finished Brass 100 Mm Mortice Latch And Lock With 6 Levers And A Pair Of Lever Handles Of Approved Quality With Necessary Screws	1 SET
2	HANDLES	Bright Finished Brass Handles With Screws	1 SET
3	HINGE	35 mm thick including ISI marked Stainless Steel butt hinges with necessary screws	3 SET
4	TOWER BOLTS	Bright Finished Brass Tower Bolts (barrel type) with necessary screws	2 SET
5	DOOR STOPPER	Bright Finished Brass Hanging Type Floor Door Stopper With Necessary Screws	1 SET
6	DOOR CHAIN	Brass Door Chain	1 SET
7	EYE VIEWER	Door viewer glass Lens for Main Door, 180 Degree Brass Finish Door Eye Viewer	1 SET

S.NO	DESCRIPTION	SPECIFICATION	QUANTITY
1	LOCK	Stainless Steel Mortice Baby Latch With Lever (Only for 1 bedroom door)	1 SET
2	HANDLE	Stainless Steel Fancy Handle Of Approved Make Fixed With Ss Screws	1 SET
3	HINGE	30 mm thick including ISI marked Stainless Steel butt hinges with necessary screws	3 SET
4	TOWER BOLTS	Bright Finished Stainless Steel Tower Bolts (Barrel Type) With Necessary Screws	2 SET
5	DOOR STOPPER	Stainless Steel Hanging Type Floor Door Stopper With Necessary Screws	1 SET

S.NO	DESCRIPTION	SPECIFICATION	QUANTITY
1	HANDLE	Stainless Steel Fancy Handle Of Approved Make Fixed With SS Screws 200 mm (for internal doors)	1 SET
2	HINGE	30 mm thick including ISI marked Stainless Steel butt hinges with necessary screws	3 SET
3	DOOR STOPPER	Stainless Steel Hanging Type Floor Door Stopper With Necessary Screws	1 SET
4	LOCK	Stainless Steel Mortice Baby Latch With Lever	1 SET

S.NO	DESCRIPTION	SPECIFICATION	QUANTITY
1	HANDLE	Stainless Steel Fancy Handle Of Approved Make Fixed With SS Screws 100 mm (for toilet doors)	1 SET
2	HINGE	30 mm thick including ISI marked Stainless Steel butt hinges with necessary screws	3 SET
3	TOWER BOLTS	Bright Finished Stainless Steel Tower Bolts (Barrel Type) With Necessary Screws	2 SET

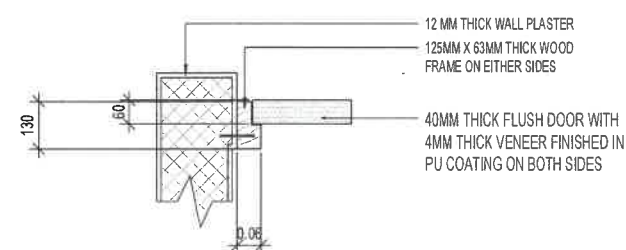


DETAIL- JAMB

1:10

Indian Bank Residential Building At Mylapore Indian Bank

Mylapore
Chennai-14.
ESTATE DEPT.

KEY PLAN

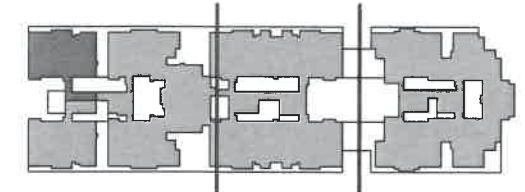

SCHEDULE OF OPENINGS

Door Schedule					
Type Mark	Description	Width	Height	Lintel	
SD1	SLIDING DOOR-3 TRACK WITH MOSQUITO MESH	2.10	2.10	2.10	
SD2	SLIDING DOOR-3 TRACK WITH MOSQUITO MESH	1.80	2.10	2.10	
LD1	LIFT DOOR	1.50	2.10	2.10	
LD2	LIFT DOOR	1.50	2.10	2.10	
D1	DOOR WITH OPENABLE MOSQUITO MESH	1.20	2.10	2.10	
GD1	GLASS DOOR WITH OPENABLE MOSQUITO MESH	1.00	2.10	2.10	
D2	DOOR	0.90	2.10	2.10	
OP	OPENING	0.90	2.10	2.10	
D3	DOOR	0.75	2.10	2.10	
SF1	DOOR	0.75	1.20		
FD	2 HOUR FIRE RATED DOOR	0.60	1.20	2.10	

Window Schedule					
Type Mark	Description	Width	Height	Lintel	Still Height
W2	WINDOW- 3 TRACK WITH MOSQUITO MESH	1.35	1.60		
W5	WINDOW- 3 TRACK WITH MOSQUITO MESH	1.35	1.60	2.10	0.50
W1	WINDOW-3 TRACK WITH MOSQUITO MESH	1.00	1.60	2.10	0.50
W3	WINDOW-3 TRACK WITH MOSQUITO MESH	1.80	0.90	2.10	1.20
W4	WINDOW-3 TRACK WITH MOSQUITO MESH	1.00	0.90	2.10	1.20
KW	WINDOW-3 TRACK WITH MOSQUITO MESH	0.90	0.90	2.10	1.20
V	VENTILATOR WITH OPENABLE MOSQUITO MESH	0.60	0.90	2.10	1.20

Proj.No. : 2214
Scale : As indicated
Date : 04/07/23
Rev.No. : R0
Drawn by : Author
Checked by : Checker

AR-351.19




TENDER DRAWING- ARCHITECTURAL

UNIT FLOORING LAYOUT


shilpa
ARCHITECTS PLANNERS DESIGNERS PVT. LTD.

"The Muse"
L20, Dr. VSI Estate, Thiruvanniyur, Chennai 600 041.
Phone : 044 24542162 / 43358531 / 42696536
Email : studio@shilpaarchitects.com
Web site : www.shilpaarchitects.com

C:\Users\arav\Desktop\SHILPA\INDIAN
BANK\2214_30June23_Tender FF To Headroom_V1 R2 V1 R0.rvt

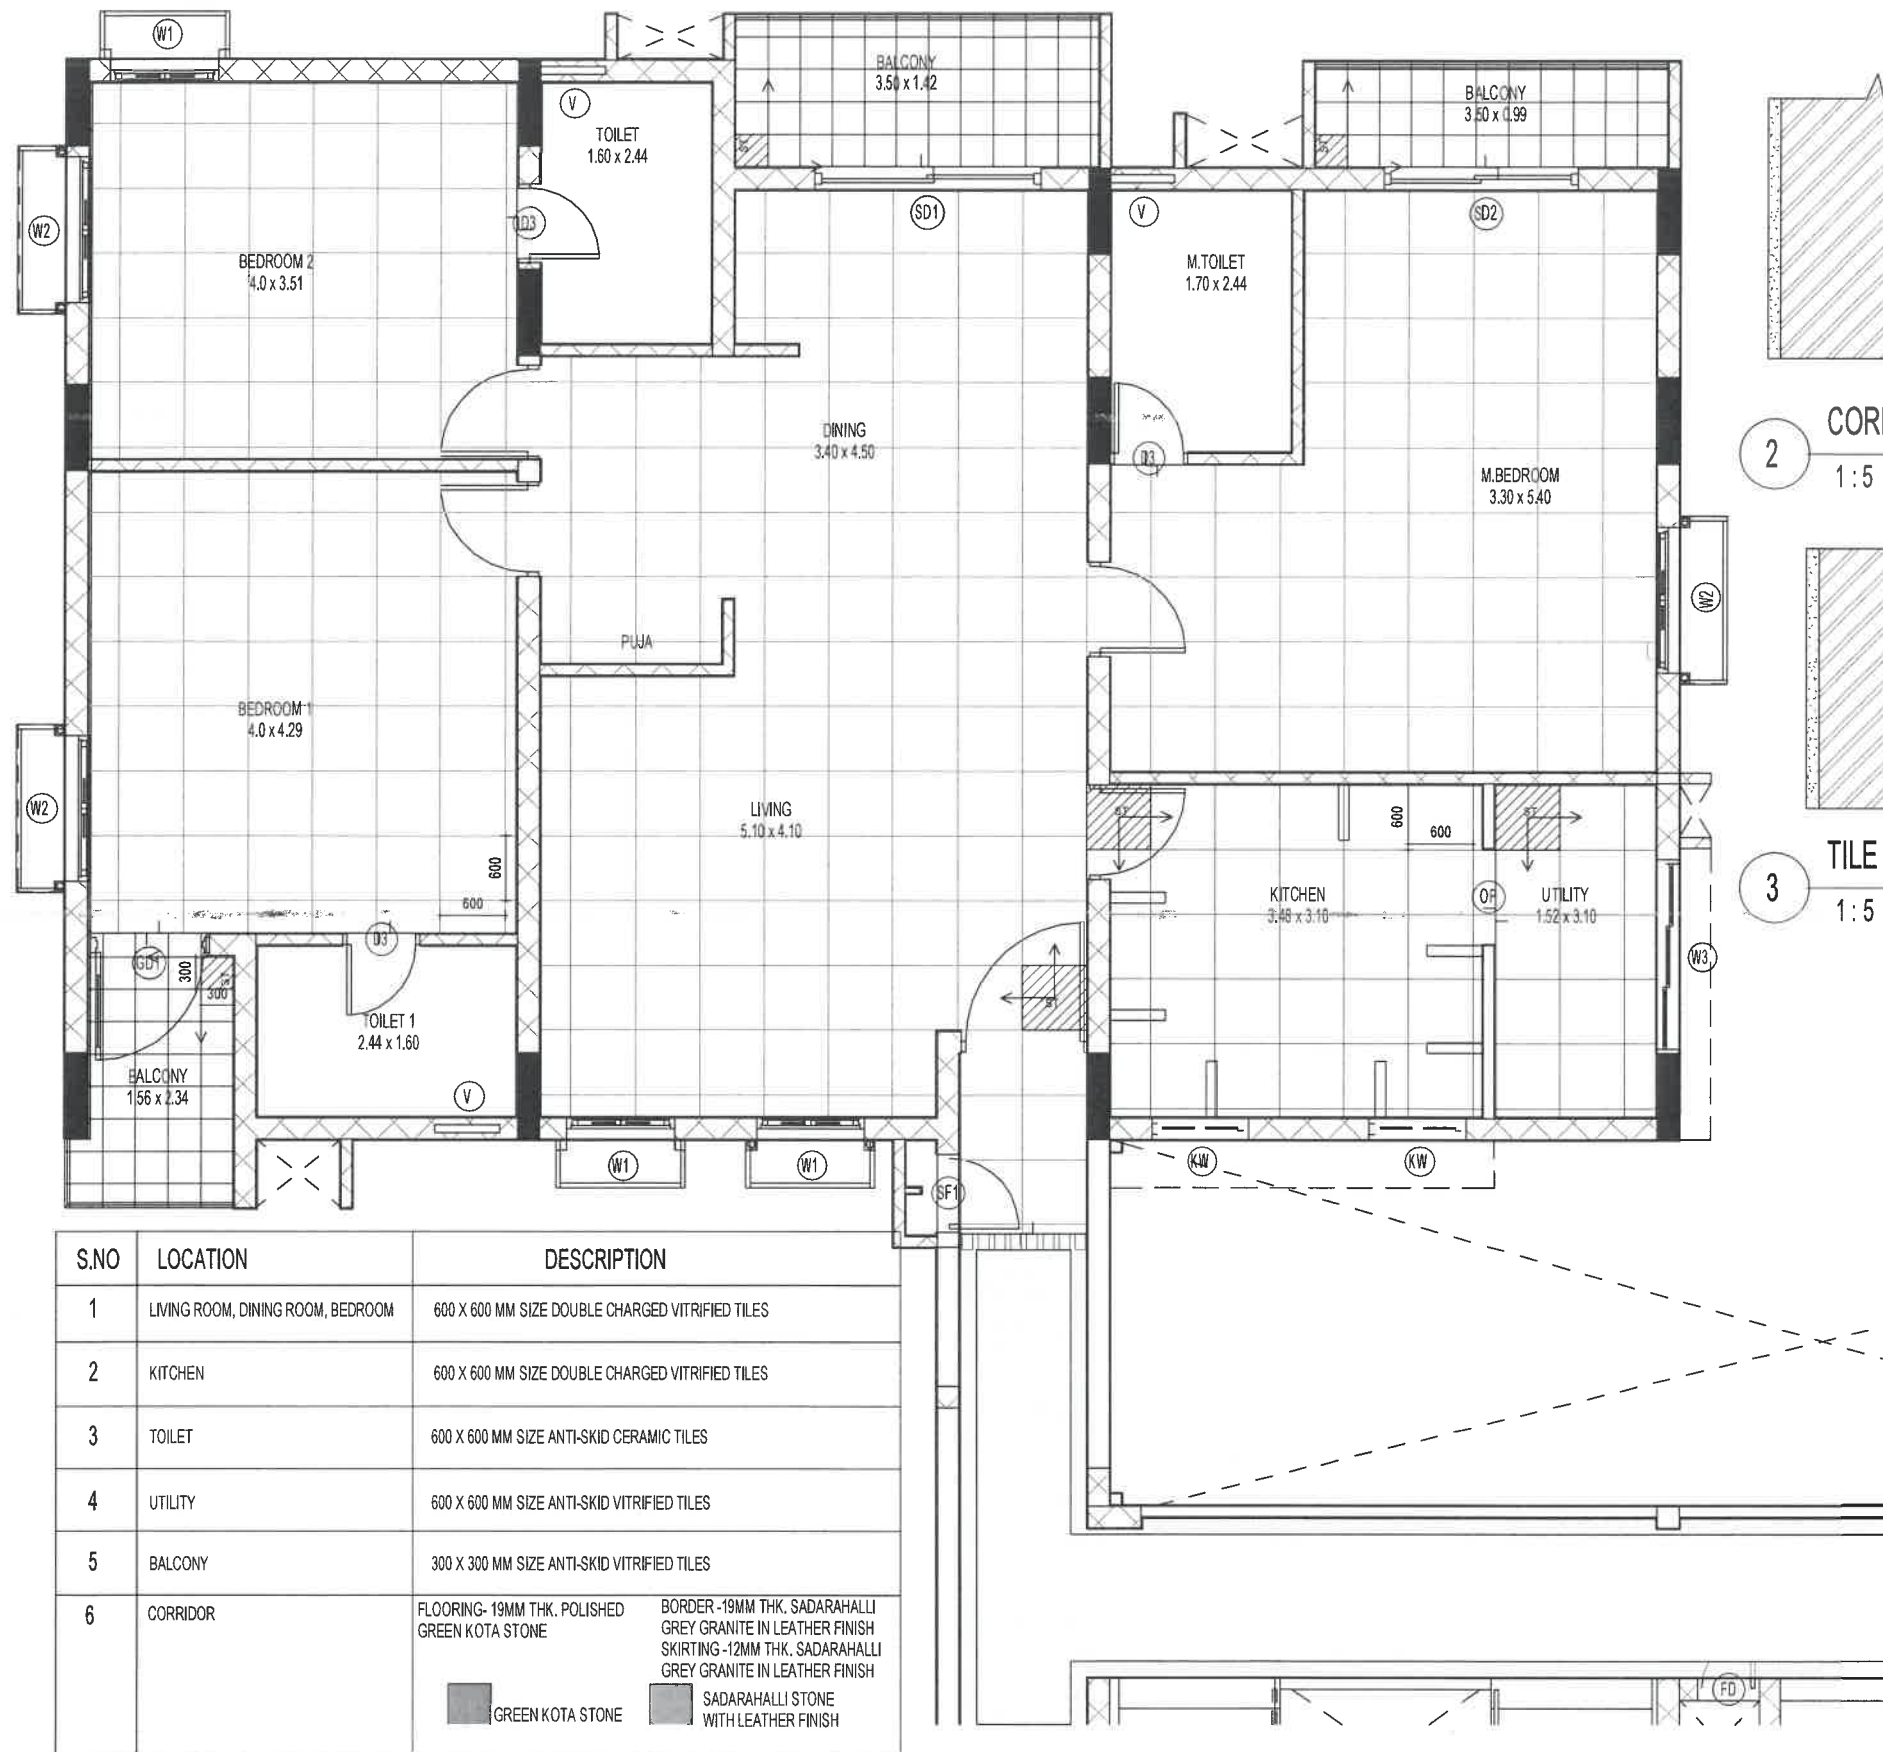

CORRIDOR SKIRTING DETAIL 1:5

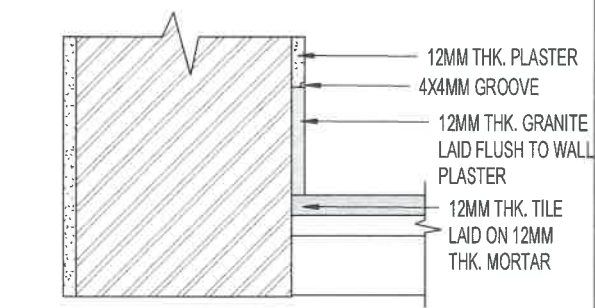

TILE SKIRTING DETAIL 1:5



S.NO	LOCATION	DESCRIPTION
1	LIVING ROOM, DINING ROOM, BEDROOM	600 X 600 MM SIZE DOUBLE CHARGED VITRIFIED TILES
2	KITCHEN	600 X 600 MM SIZE DOUBLE CHARGED VITRIFIED TILES
3	TOILET	600 X 600 MM SIZE ANTI-SKID CERAMIC TILES
4	UTILITY	600 X 600 MM SIZE ANTI-SKID VITRIFIED TILES
5	BALCONY	300 X 300 MM SIZE ANTI-SKID VITRIFIED TILES
6	CORRIDOR	FLOORING- 19MM THK. POLISHED GREEN KOTA STONE BORDER -19MM THK. SADARAHALLI GREY GRANITE IN LEATHER FINISH SKIRTING -12MM THK. SADARAHALLI GREY GRANITE IN LEATHER FINISH

GREEN KOTA STONE
SADARAHALLI STONE WITH LEATHER FINISH

FLOORING LAYOUT- UNIT A12, BLOCK A - TYPICAL FLOOR PLAN 1:50



LEGEND:

SYMBOL	DESCRIPTION
BE	BODY EARTH ELECTRODE WITH HEAVY DUTY COVER
NE	NEUTRAL EARTH ELECTRODE ELECTRODE WITH HEAVY DUTY COVER
-----	25x3mm. GI FLAT
-----	25x6mm. GI FLAT
-----	1C 4Sqm Cu Wire
-----	50x6mm. GI FLAT
-----	25x6mm. Cu FLAT
-----	25x3mm. Cu FLAT
-----	40x6mm. Cu FLAT

All measurements must be verified on project on site, before final detailing and fabrication, the drawing must be verified and approved. This drawing is the property of AIR TREATMENT ENGINEERING PVT. LTD., and no part of sum of the entirety of this document is to be copied or reproduced. It is to be used for the project and site only, specifically herein, and is not to be used on any other project. It is also to be returned upon request.

R0	05-01-2023	PRELIMINARY SUBMISSION
NO	DATE	REVISION

MEP CONSULTANT:
AIR TREATMENT ENGINEERING PVT. LTD.
MEP, E.L.V, Noise Control & Acoustics, Green Buildings
Design for CDM, Drafts for PC
42ND WEST STREET, KANAKA NAGAR,
THIRUVANMIYUR, CHENNAI-600 041.

PROJECT TITLE:
INDIAN BANK APARTMENTS

CLIENT:
INDIAN BANK

ARCHITECT:

PMC:

DRAWING TITLE:
EARTHING SINGLE LINE DIAGRAM

DRAWN BY:	RBJ
CHECKED BY:	KSB
APPROVED BY:	KSB
DATE	29-04-2023
SCALE	NIL
REVISION	R0

DRAWING NUMBER:
ATE-IB-ELE-ESLD-001

PURPOSE:
FOR APPROVAL

■ AIR TREATMENT ENGINEERING PVT. LTD. ■ MEP, E.L.V, NOISE CONTROL & ACOUSTICS, GREEN BUILDINGS, DESIGN FOR CDM, DESIGN FOR PC, #42ND WEST STREET, KANAKA NAGAR, THIRUVANMIYUR, CHENNAI-600 041. ■

