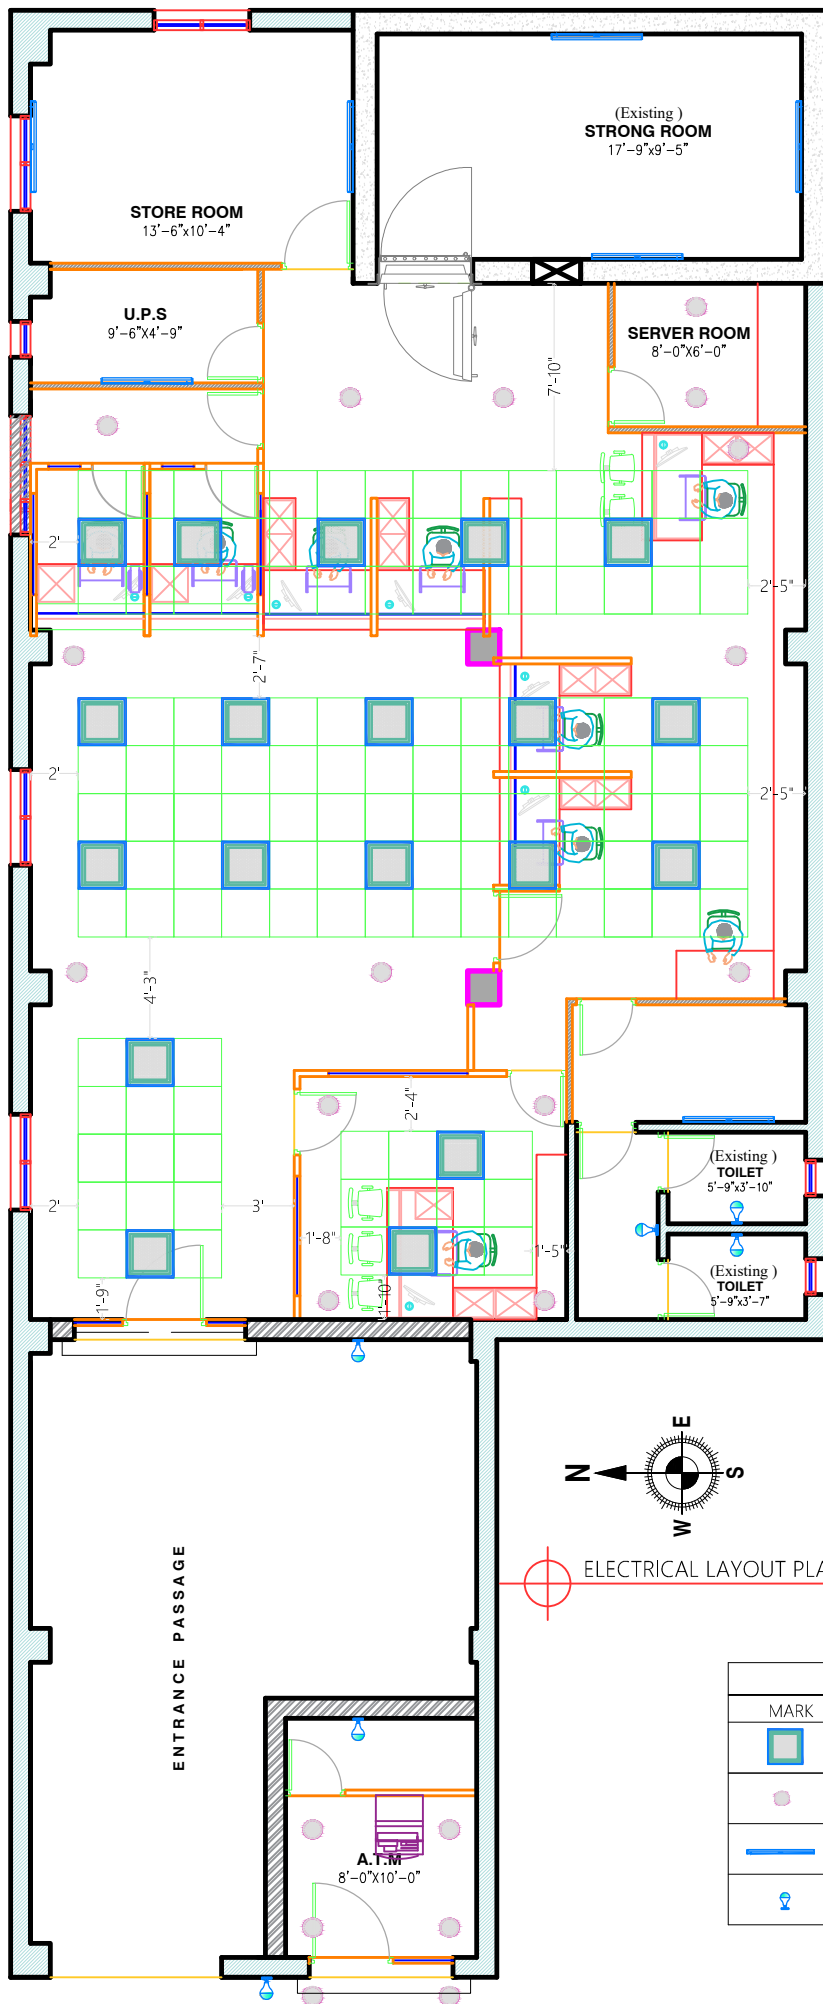


ELECTRICAL LAYOUT PLAN

LEGEND OF LIGHT		
MARK	DESCRIPTION	NOS
	36W RECESS TYPE LED	19
	12 W RECESS TYPE LED	14+6
	1x18W WALL MOUNTED T5 LED LIGHT	7
	ANGLE HOLDER WITH 9 W LED LIGHT	5+1

Clint Name.

INDIAN BANK

Location.

BALESWAR

Drg. Title.

ELECTRICAL LAYOUT PLAN(Ceiling & light)

Rev. No.

Drg. No. **1**

Drawn by.SSA

Date. **17/10/2023**



Techno Arch

Plot No.- 71/7, Jadupur, Near Ranasinghpur Moo Bus stand.
Bhubaneswar Ph. 0674-2551479 Mobile. 9437189632