



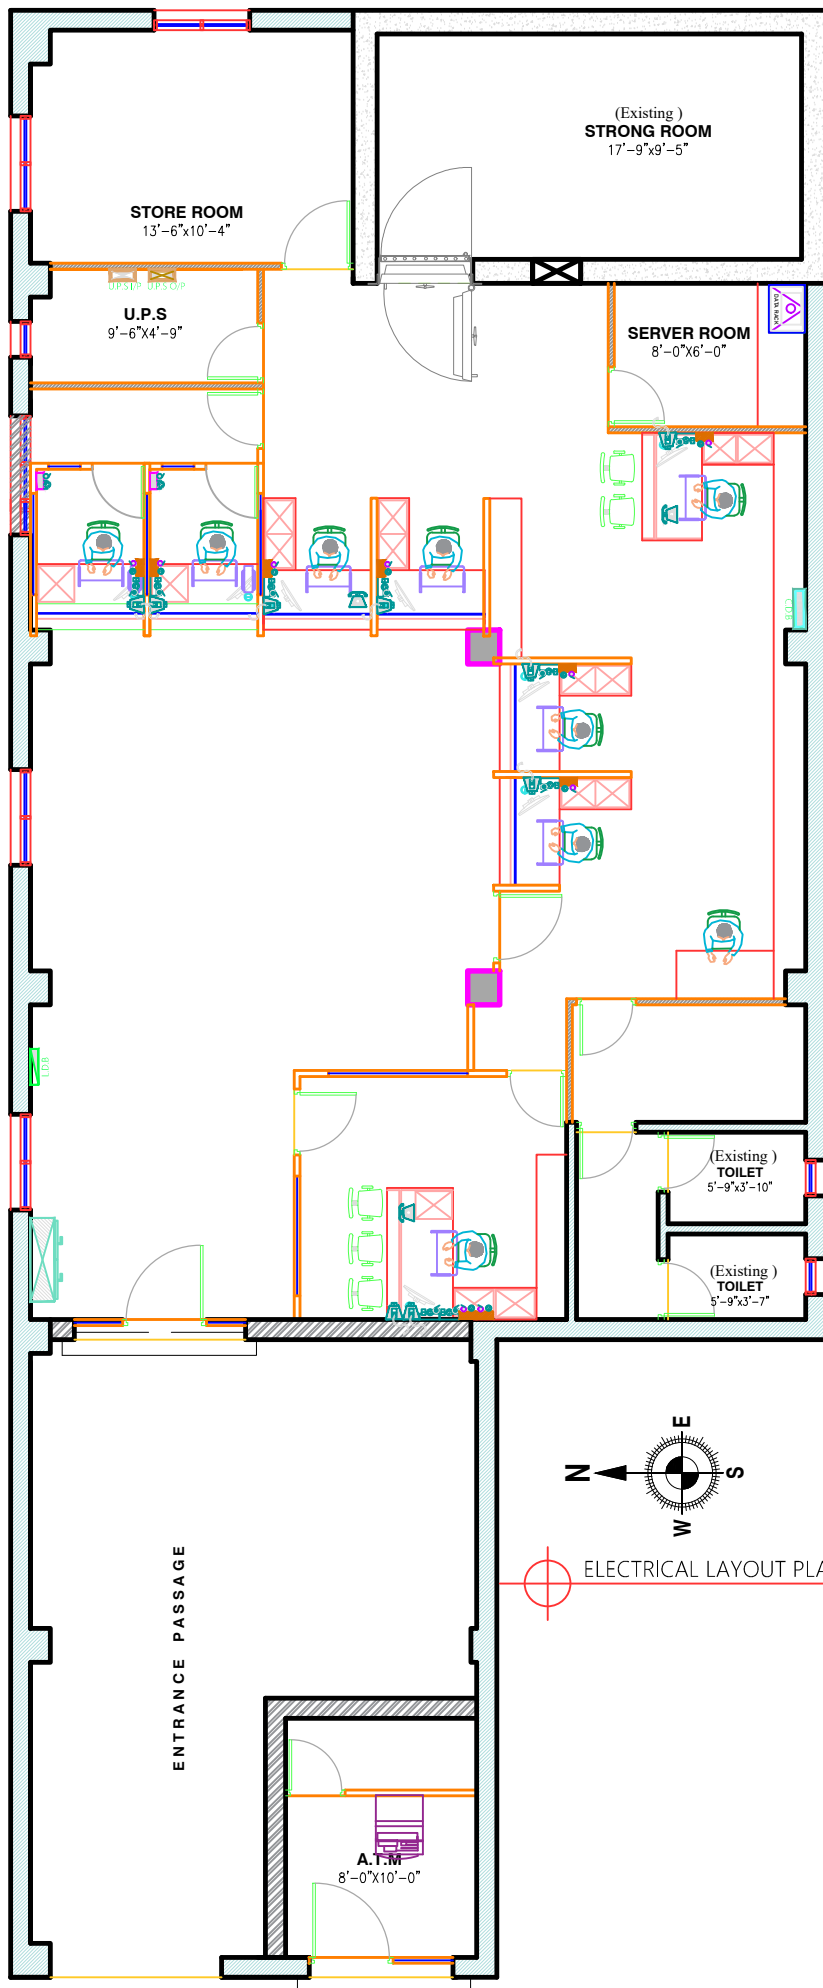

LEGEND OF DATA	
MARK	DESCRIPTION
	4nos 6A SOCKET WITH 1nos 16A SWITCH
	5 NO OF 6/16A SOCKET + 2 No of 16 A SWITCH
	COMPUTER TERMINAL (CAT 6 I.O BOX)
	TELEPHONE TERMINAL (CAT 6 I.O BOX)
	MAIN PANEL BOARD
	L.D.B
	C.D.B
	U.P.S INPUT & U.P.S OUTPUT
	6 A SOCKET WITH 6 A SWITCH. IN SEPARATE BOARD
	16 A SOCKET WITH 16A SWITCH. IN SEPARATE BOARD
	SWICH BOARD WITH 5A. SOCKET
	SWICH BOARD
	DATA RACK

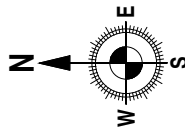

ELECTRICAL LAYOUT PLAN

Clint Name.

INDIAN BANK

Location.

BALESWAR

Drg. Title.

ELECTRICAL LAYOUT PLAN(data)

Rev. No.

0

Drg. No. **1**

Drawn by.SSA

Date. **02/06/2023**



Techno Arch

Plot No.- 71/7, Jadupur, Near Ranasinghpur Moo Bus stand.
Bhubaneswar Ph. 0674-2551479 Mobile. 9437189632