



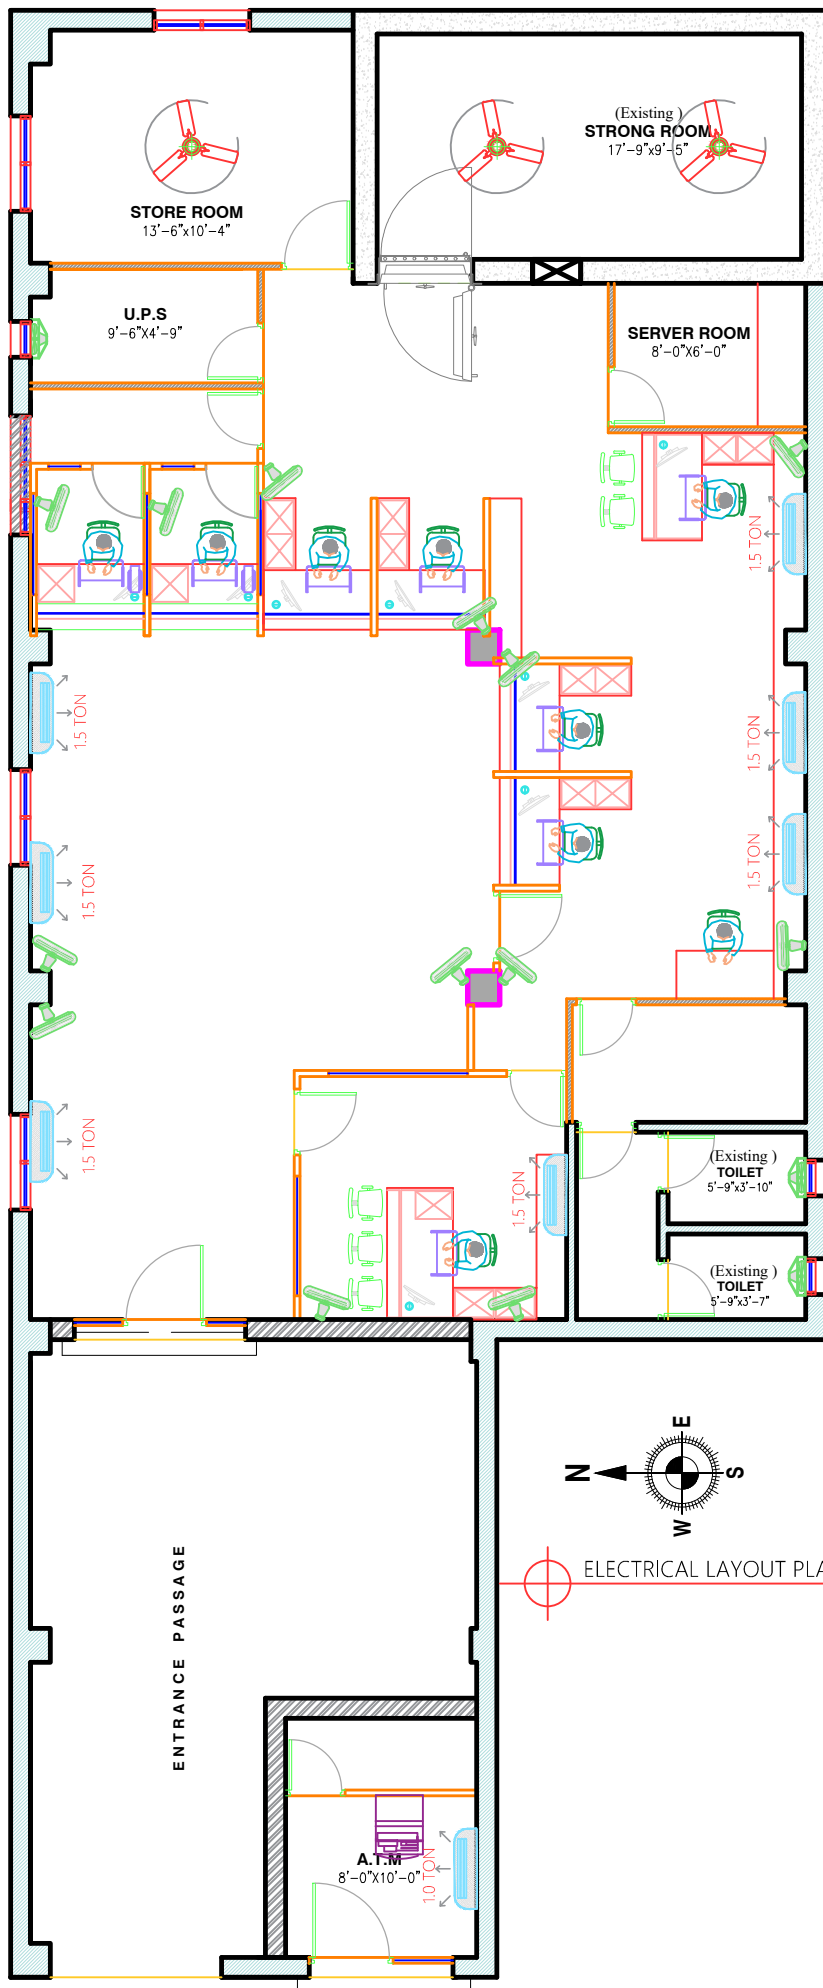

LEGEND OF FAN		
MARK	DESCRIPTION	NOS
	1200 MM. CEILING FAN	3
	400 MM. WALL FAN	13
	225 MM. EXHUST FAN	3

SCHEDULE OF A.C.		
MARK	DESCRIPTION	No.
	1.5 TON	7
	1.0 TON	1

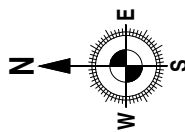

ELECTRICAL LAYOUT PLAN

Client Name.

INDIAN BANK

Location.

BALESWAR

Drg. Title.

ELECTRICAL LAYOUT PLAN(A.C & Fan)

Rev. No.

0

Drg. No. **1**

Drawn by.SSA

Date. **02/06/2023**



Techno Arch

Plot No.- 71/7, Jadupur, Near Ranasinghpur Moo Bus stand.
Bhubaneswar Ph. 0674-2551479 Mobile. 9437189632