


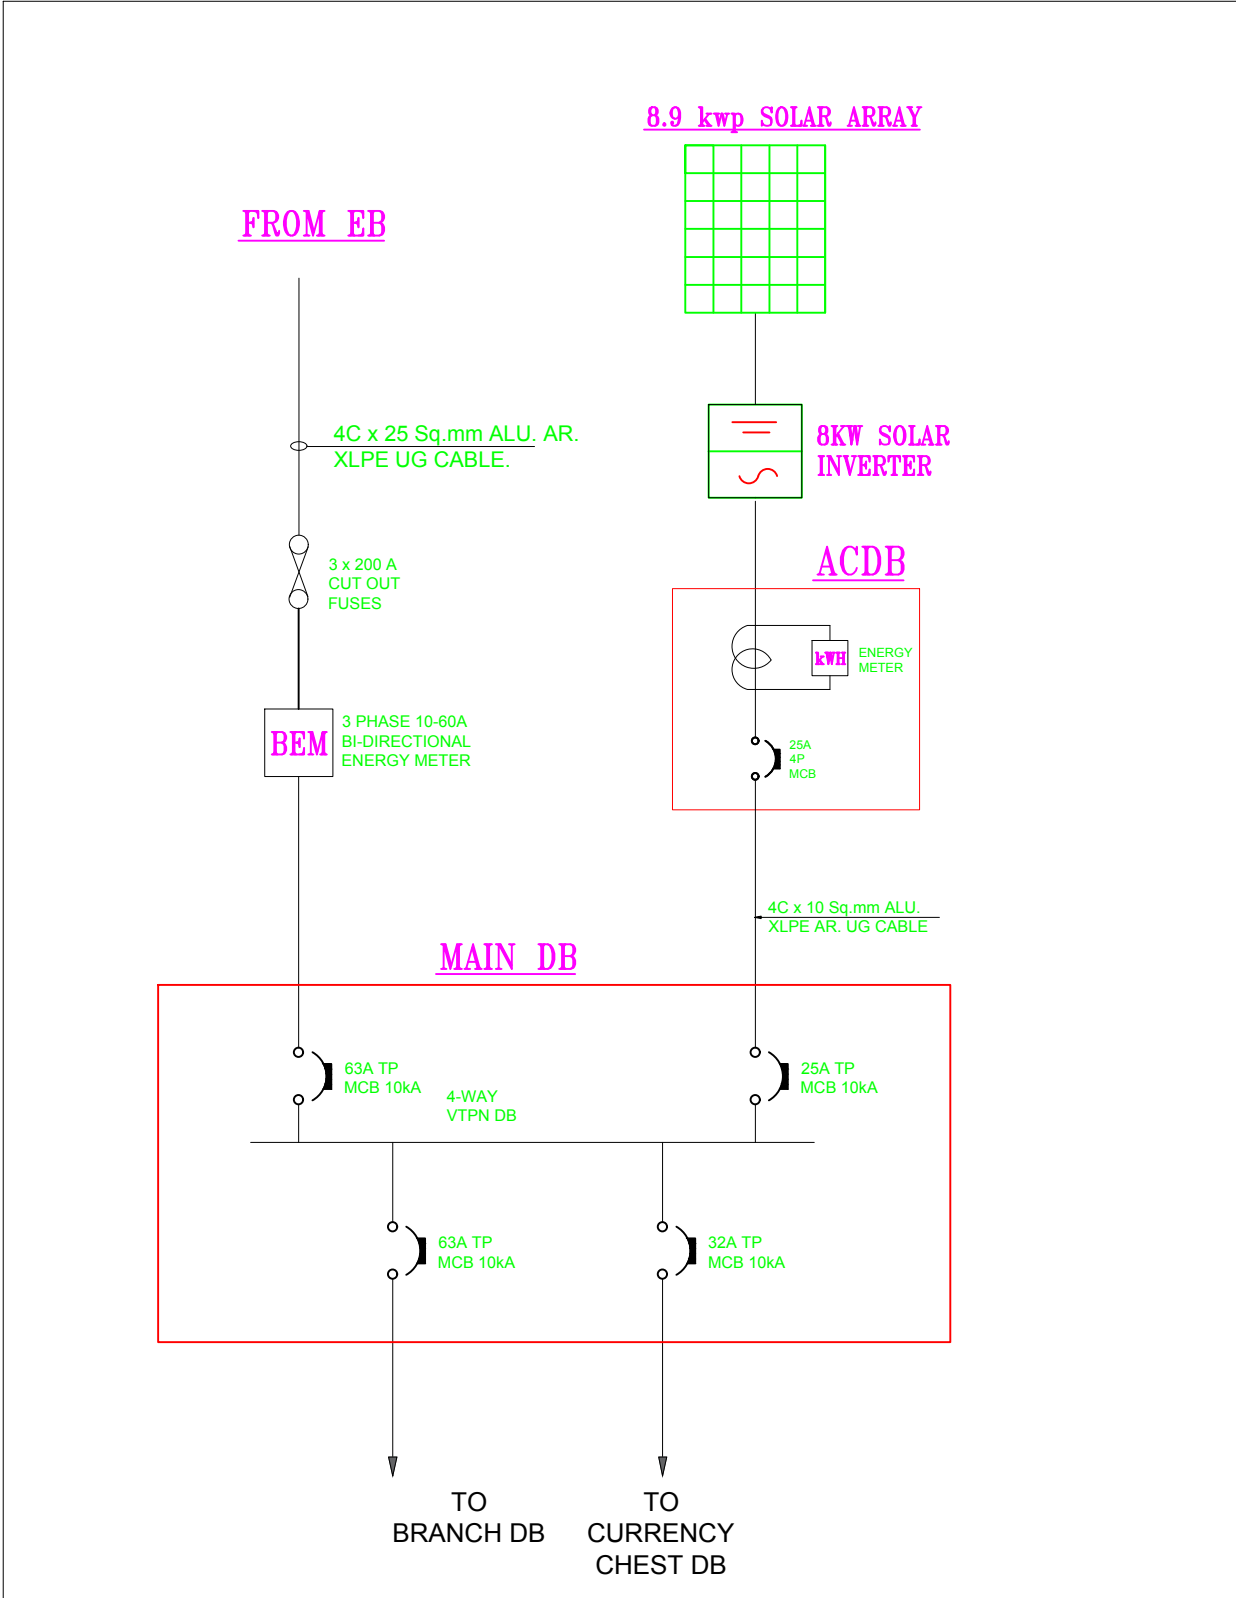

TITLE:- SINGLE LINE DIAGRAM FOR INDIAN BANK, RANIPET BRANCH

ELECTRICAL CONSULTANT:- M/s. ENERGY MULTIPLES Er. K.P.MURALIDHARAN.	DRAWN BY:	SNJ
	DATE	14.12.2023