


INDIAN BANK

KARIKUDI BRANCH (EXISTING PREMISES)

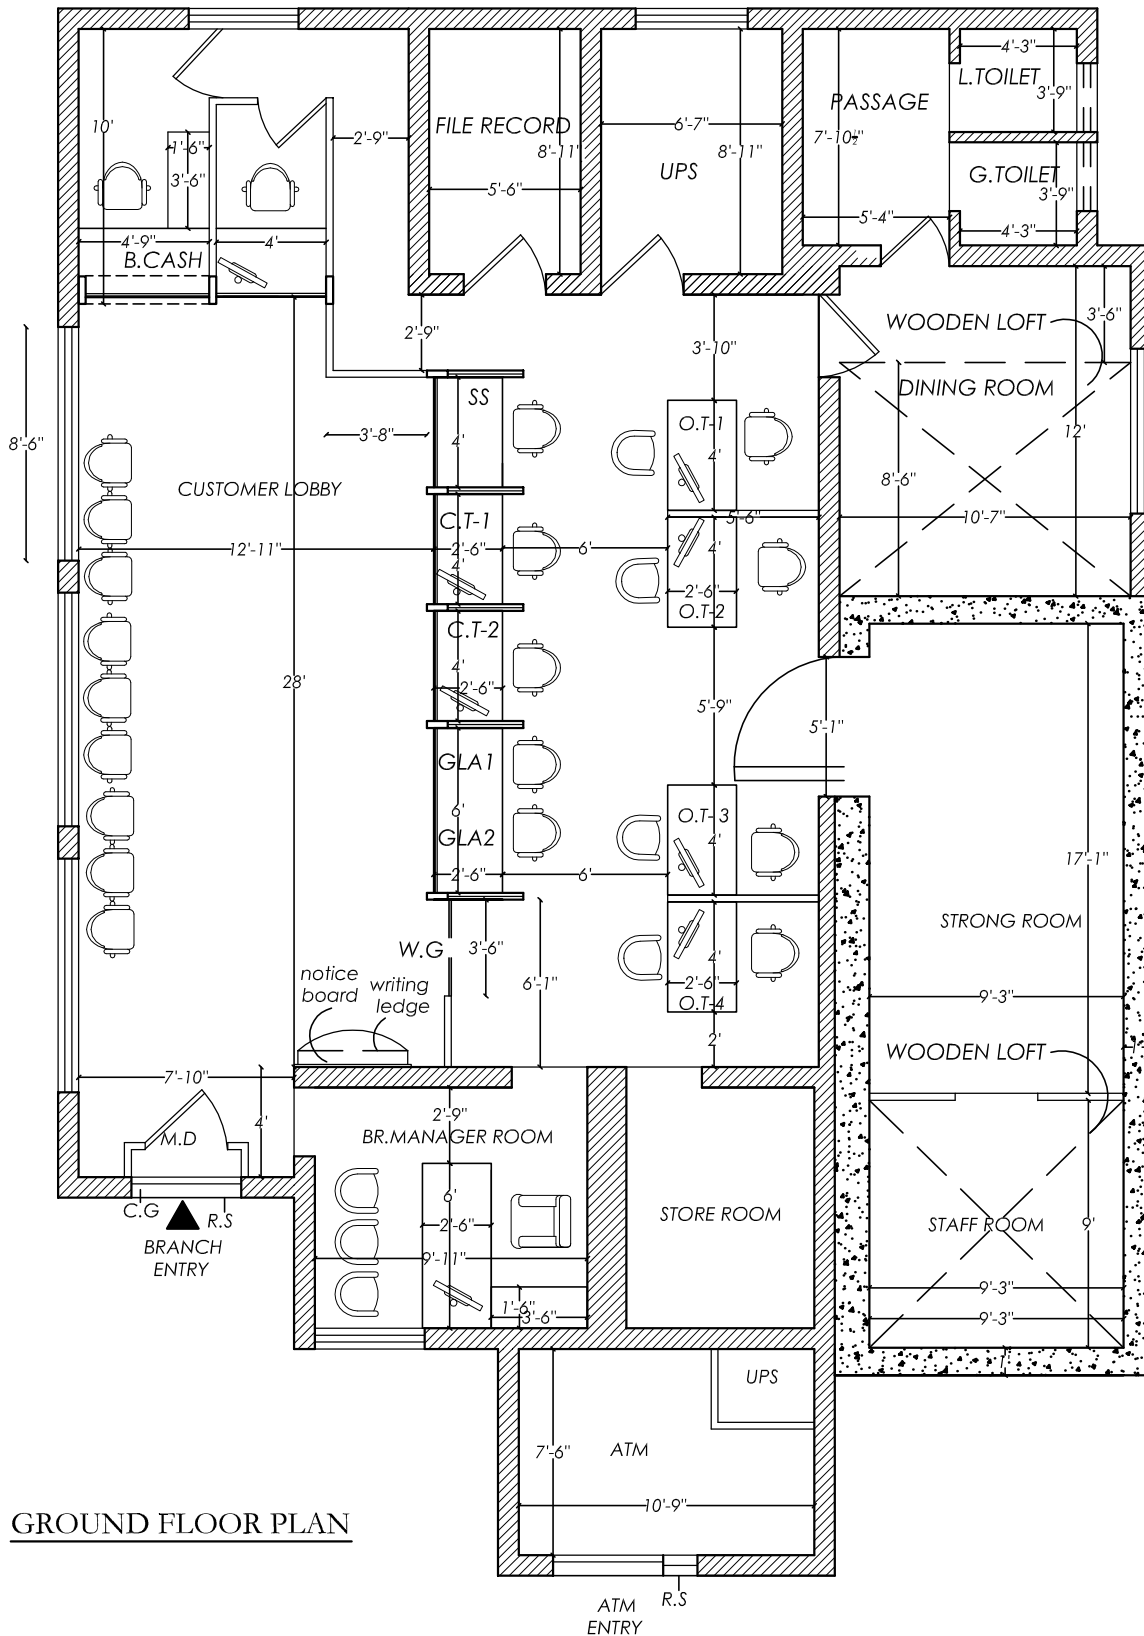

GROUND FLOOR PLAN

REFERENCE:

FHGP- FULL HEIGHT GLAZED PARTITION
FHP - FULL HEIGHT PARTITION
LHP - LOW HEIGHT PARTITION
F.H.S - FULL HEIGHT STORAGE
G.L.A -GOLD LOAN APPRAISER
O.T -OFFICER'S TABLE
C.T -CLERICAL TABLE
R.S - ROLLING SHUTTER
C.G - COLLAPSIBLE GATE
W.G - WICKET GATE
M.D - MAIN DOOR (4'0"X7'0")

D - DOOR (3'0"X7'0")
D1 - DOOR (2'6"X7'0")

NOTE:

WINDOW SILL HEIGHT - 3'0"
LINTEL HEIGHT - 7'0" & 8'0"
ROOF HEIGHT LVL - 11'9"
ROOF BEAM BOTTOM LVL - 10'6"

CARPET AREA DETAILS:

FOR BRANCH : 1632.00 sq.ft
BRANCH A/C AREA : 1000.00 sq.ft
FOR ATM : 81.00 sq.ft

TITLE

TENDER CONCEPT

DRAWN - R.M

JOB NO - 15-22

DATE - 29.12.2023

SCALE - N.T.S.

SHEET NO - 01

MATHURA ASSOCIATES

ARCHITECTURAL & STRUCTURAL CONSULTANT
INTERIOR DESIGNS - VALUERS - LANDSCAPE



Contact :
99658-81704
96006-31864

Proprietor :

Ar.D.MADHUKANNAN B.Arch.,AIIA.,FIV.,Mem.C.A.

REGISTERED ARCHITECT - COA


EMPANELLED ARCHITECT - INDIAN BANK

GOVT. REGISTERED VALUER - INCOME TAX

47-B Town Hall Road, 1st Floor, Madurai-625001.

INDIAN BANK

KARIKUDI BRANCH (EXISTING PREMISES)

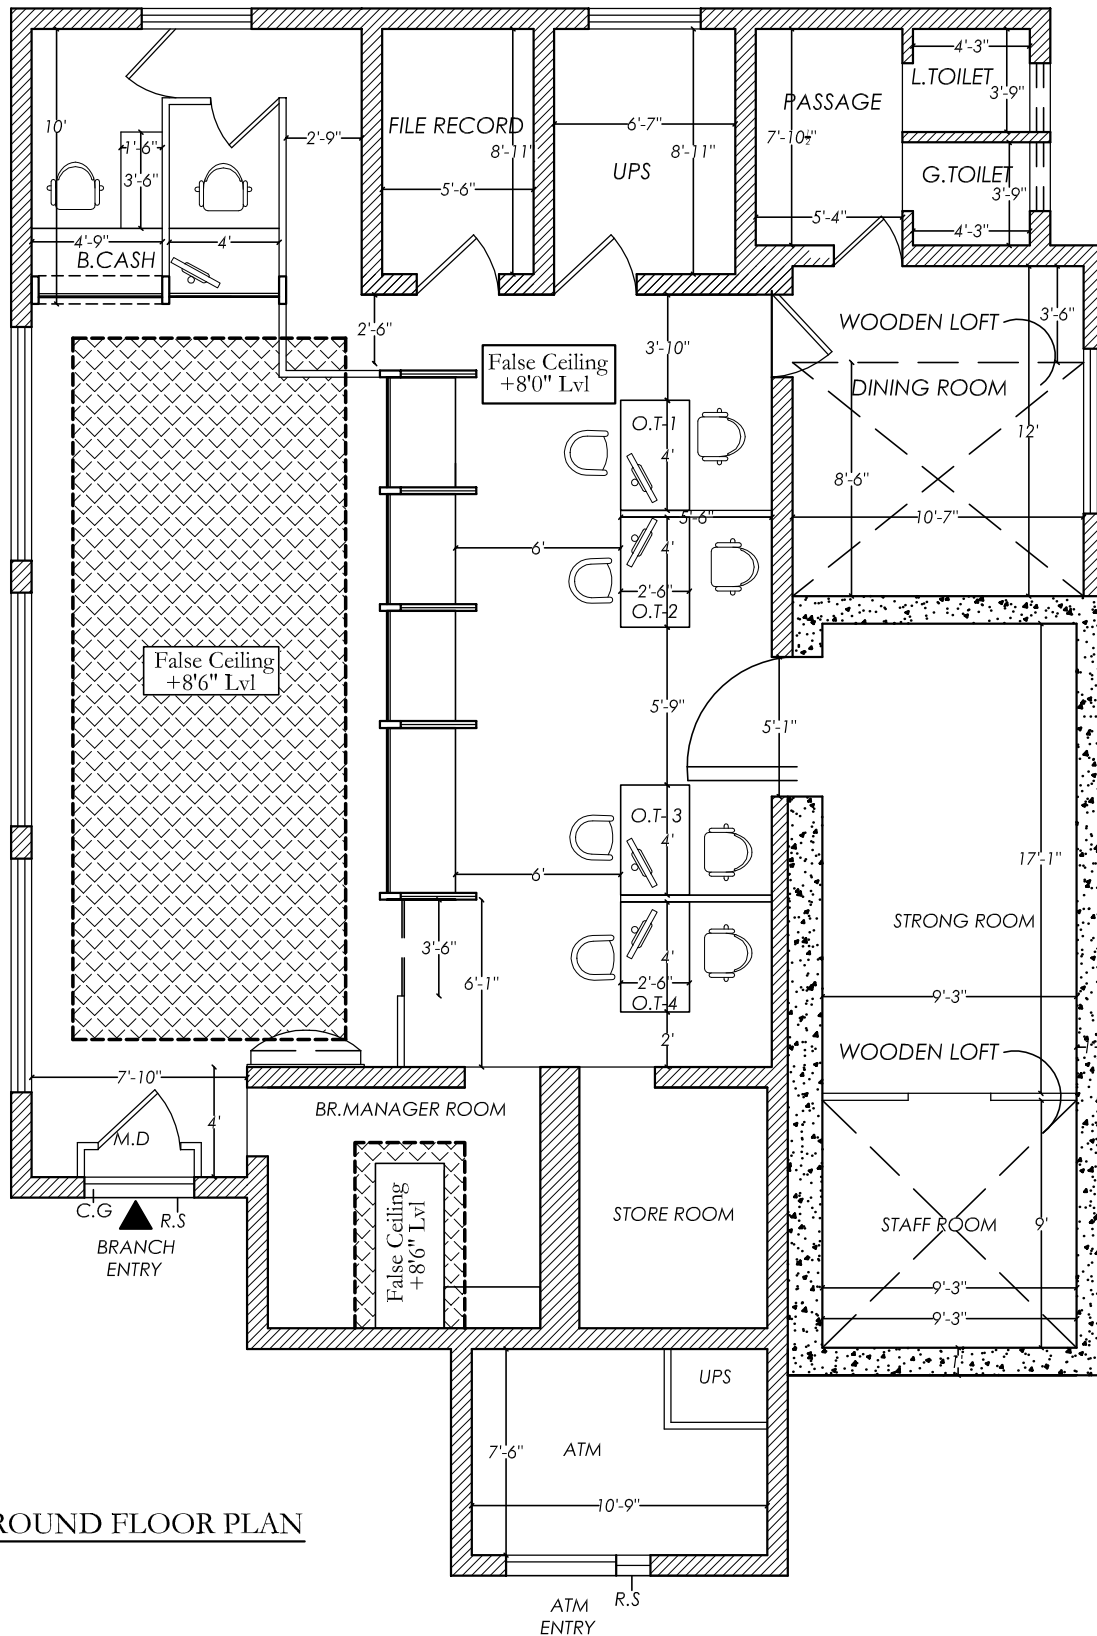

GROUND FLOOR PLAN

REFERENCE:

FHGP- FULL HEIGHT GLAZED PARTITION
FHP - FULL HEIGHT PARTITION
LHP - LOW HEIGHT PARTITION
F.H.S - FULL HEIGHT STORAGE
G.L.A -GOLD LOAN APPRAISER
O.T -OFFICER'S TABLE
C.T -CLERICAL TABLE
R.S - ROLLING SHUTTER
C.G - COLLAPSIBLE GATE
W.G - WICKET GATE
M.D - MAIN DOOR (4'0"X7'0")

D - DOOR (3'0"X7'0")
D1 - DOOR (2'6"X7'0")

NOTE:

WINDOW SILL HEIGHT - 3'0"
LINTEL HEIGHT - 7'0" & 8'0"
ROOF HEIGHT LVL - 11'9"
ROOF BEAM BOTTOM LVL - 10'6"

CARPET AREA DETAILS:

FOR BRANCH : 1632.00 sq.ft
BRANCH A/C AREA : 1000.00 sq.ft
FOR ATM : 81.00 sq.ft

TITLE

FALSE CEILING

DRAWN - R.M

JOB NO - 15-22

DATE - 29.12.2023

SCALE - N.T.S.

SHEET NO - 02

MATHURA ASSOCIATES

ARCHITECTURAL & STRUCTURAL CONSULTANT
INTERIOR DESIGNS - VALUERS - LANDSCAPE

Contact :
99658-81704
96006-31864



Proprietor :

Ar.D.MADHUKANNAN B.Arch.,AIIA.,FIV.,Mem.C.A.

REGISTERED ARCHITECT - COA


EMPANELLED ARCHITECT - INDIAN BANK

GOVT. REGISTERED VALUER - INCOME TAX

47-B Town Hall Road, 1st Floor, Madurai-625001.

INDIAN BANK

KARIKUDI BRANCH (EXISTING PREMISES)

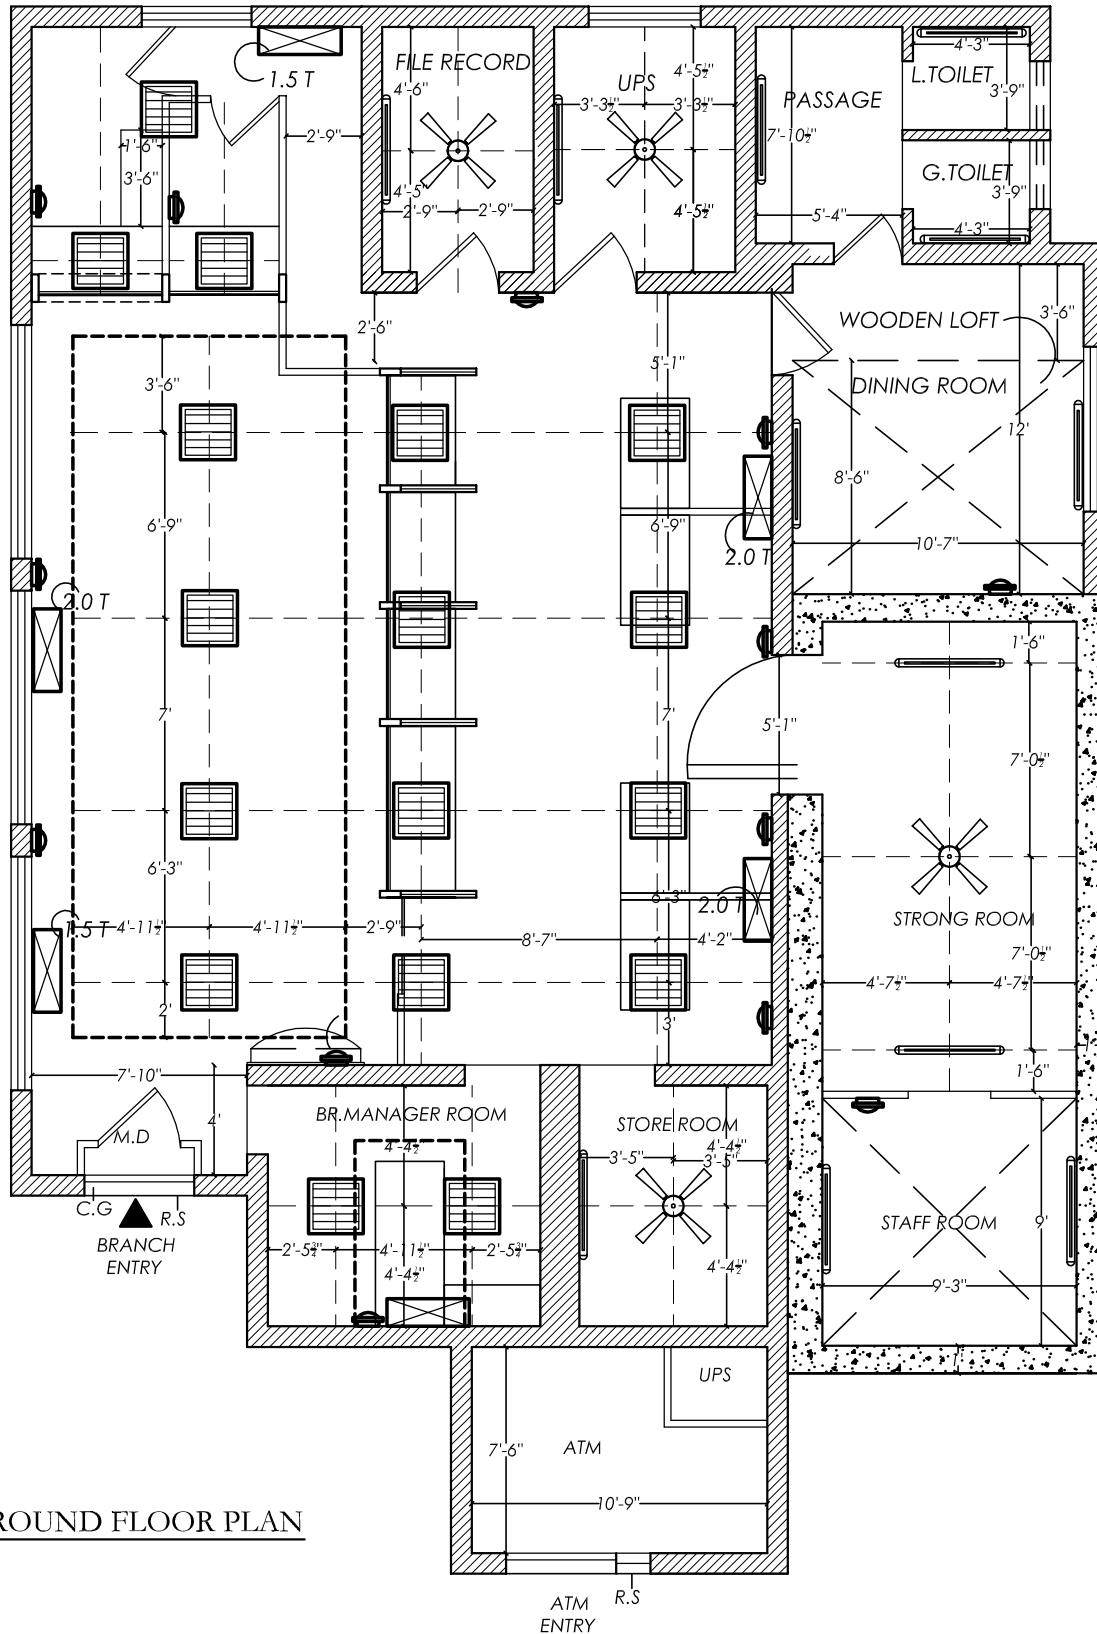

REFERENCE:

- A/C - 2 Ton - 3 Nos.
- A/C - 1.5 Ton - 2 Nos.
- A/C - 1 Ton - 1 Nos.
- Wall mounted fan - 13 Nos
- Exhaust fan - 3 Nos
- 4' Ceiling fan - 4 Nos
- Tubelight - 12 Nos



2'0" x 2'0" - 17 Nos LED Recessed

NOTE:

WINDOW SILL HEIGHT - 3'0"
 LINTEL HEIGHT - 7'0" & 8'0"
 ROOF HEIGHT LVL - 11'9"
 ROOF BEAM BOTTOM LVL - 10'6"

CARPET AREA DETAILS:

FOR BRANCH : 1632.00 sq.ft
 BRANCH A/C AREA : 1000.00 sq.ft
 FOR ATM : 81.00 sq.ft

TITLE

ELECTRICAL LAYOUT

DRAWN - R.M
 JOB NO - 15-22
 DATE - 29.12.2023
 SCALE - N.T.S.
 SHEET NO - 03

MATHURA ASSOCIATES

ARCHITECTURAL & STRUCTURAL CONSULTANT
 INTERIOR DESIGNS - VALUERS - LANDSCAPE



Contact :

99658-81704

96006-31864

Proprietor :

Ar. D. MADHUKANNAN B. Arch., AIAA., FIV., Mem. C.A.

REGISTERED ARCHITECT - COA

EMPANELLED ARCHITECT - INDIAN BANK

GOVT. REGISTERED VALUER - INCOME TAX

47-B Town Hall Road, 1st Floor, Madurai-625001.