


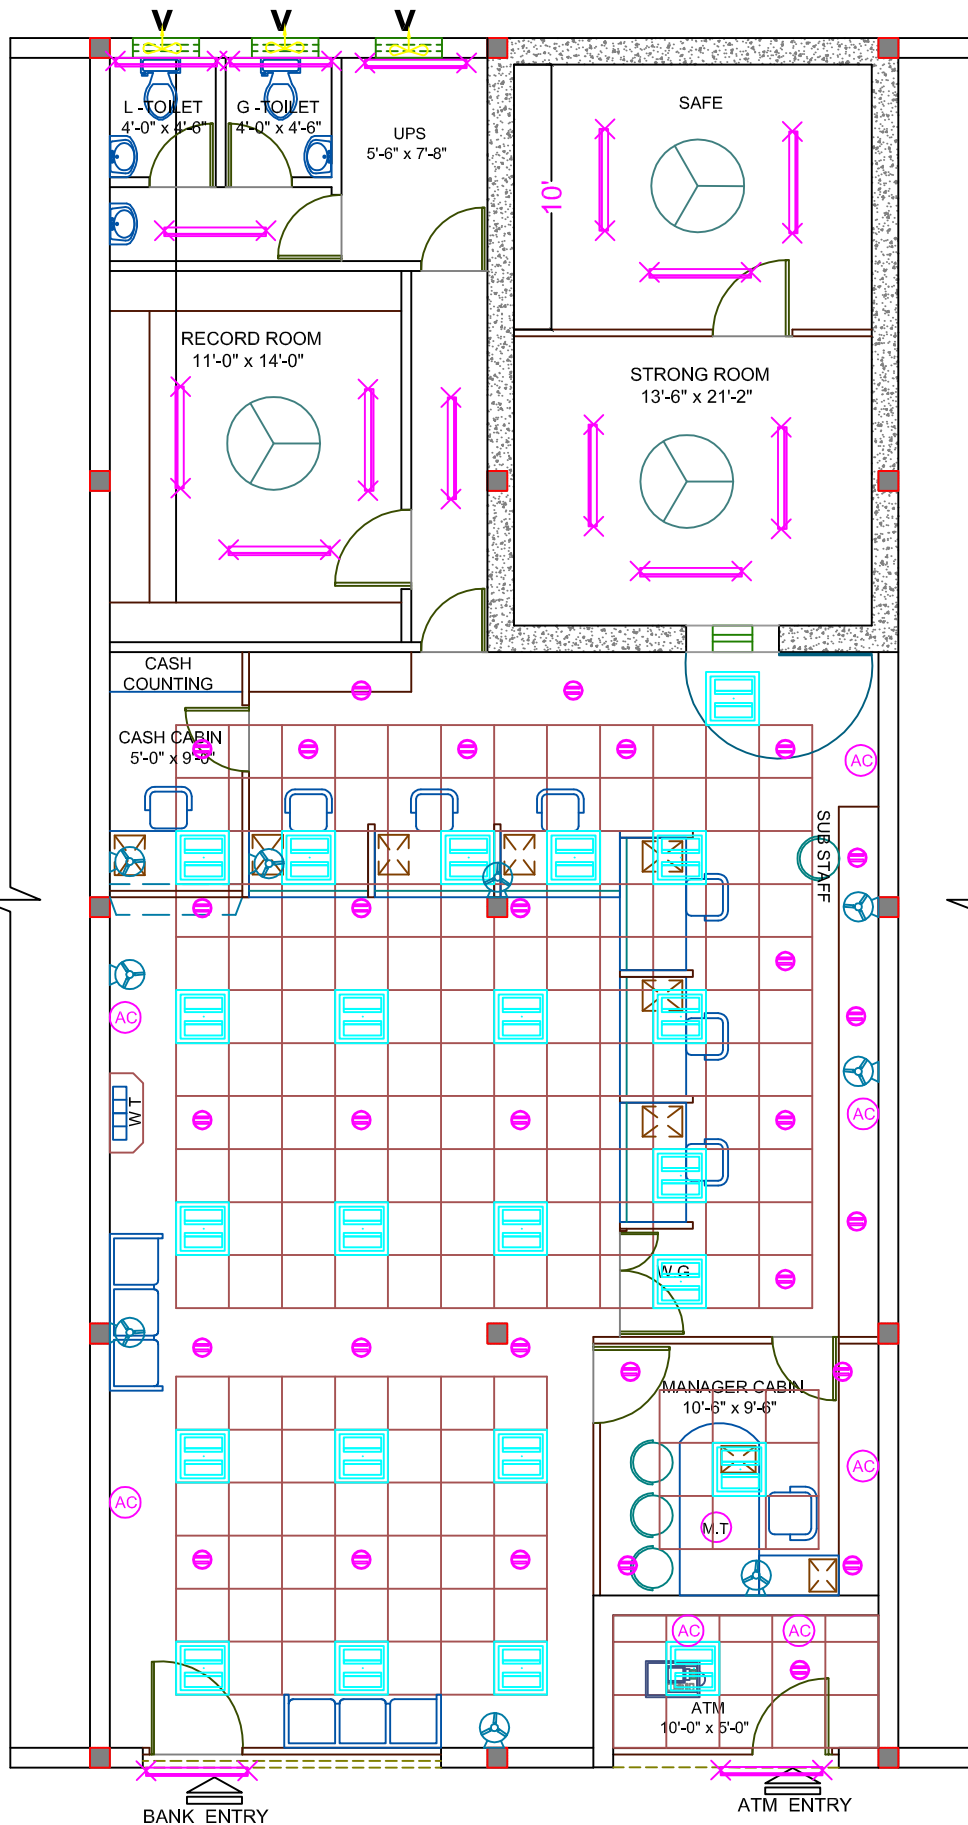

NOTE :

1. THIS DRAWINGS IS THE PROPERTY OF THE ARCHITECT AND SHALL NOT BE COPIED WITHOUT HIS PERMISSION.
2. DISCREPANCIES FOUND IN THE DRAWING SHALL BE BROUGHT TO THE ARCHITECT'S NOTICE IMMEDIATELY.
3. DRAWINGS SHALL BE READ AND SHOULD NOT BE SCALED.

PROJECT :


PROPOSED ELECTRICAL FOR
INDIAN BANK
KALAKADA BRANCH
TIRUPATI (R.O)

TITLE BLOCK :

DESIGNED BY: FA
DRAWN BY: MASTAN
CHECKED BY : FA
DATE : 22-04-2025
SCALE : NTS

ELECTRICAL LAYOUT PLAN GROUND FLOOR

NORTH :

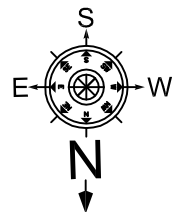

ARCHITECT:

FIROZ AHMED, M.Arch.,

H.NO:13-6-436/A/33, LAKSHMI-
APARTMENT, 2nd FLOOR, 301,
LAKSHMI NAGAR, PILLAR NO.68,
MEHIDIPATNAM, HYDERABAD.
CELL: 98481 49737

OPTION-02

CARPET AREA : 1736 SFT

NORTH ROAD