


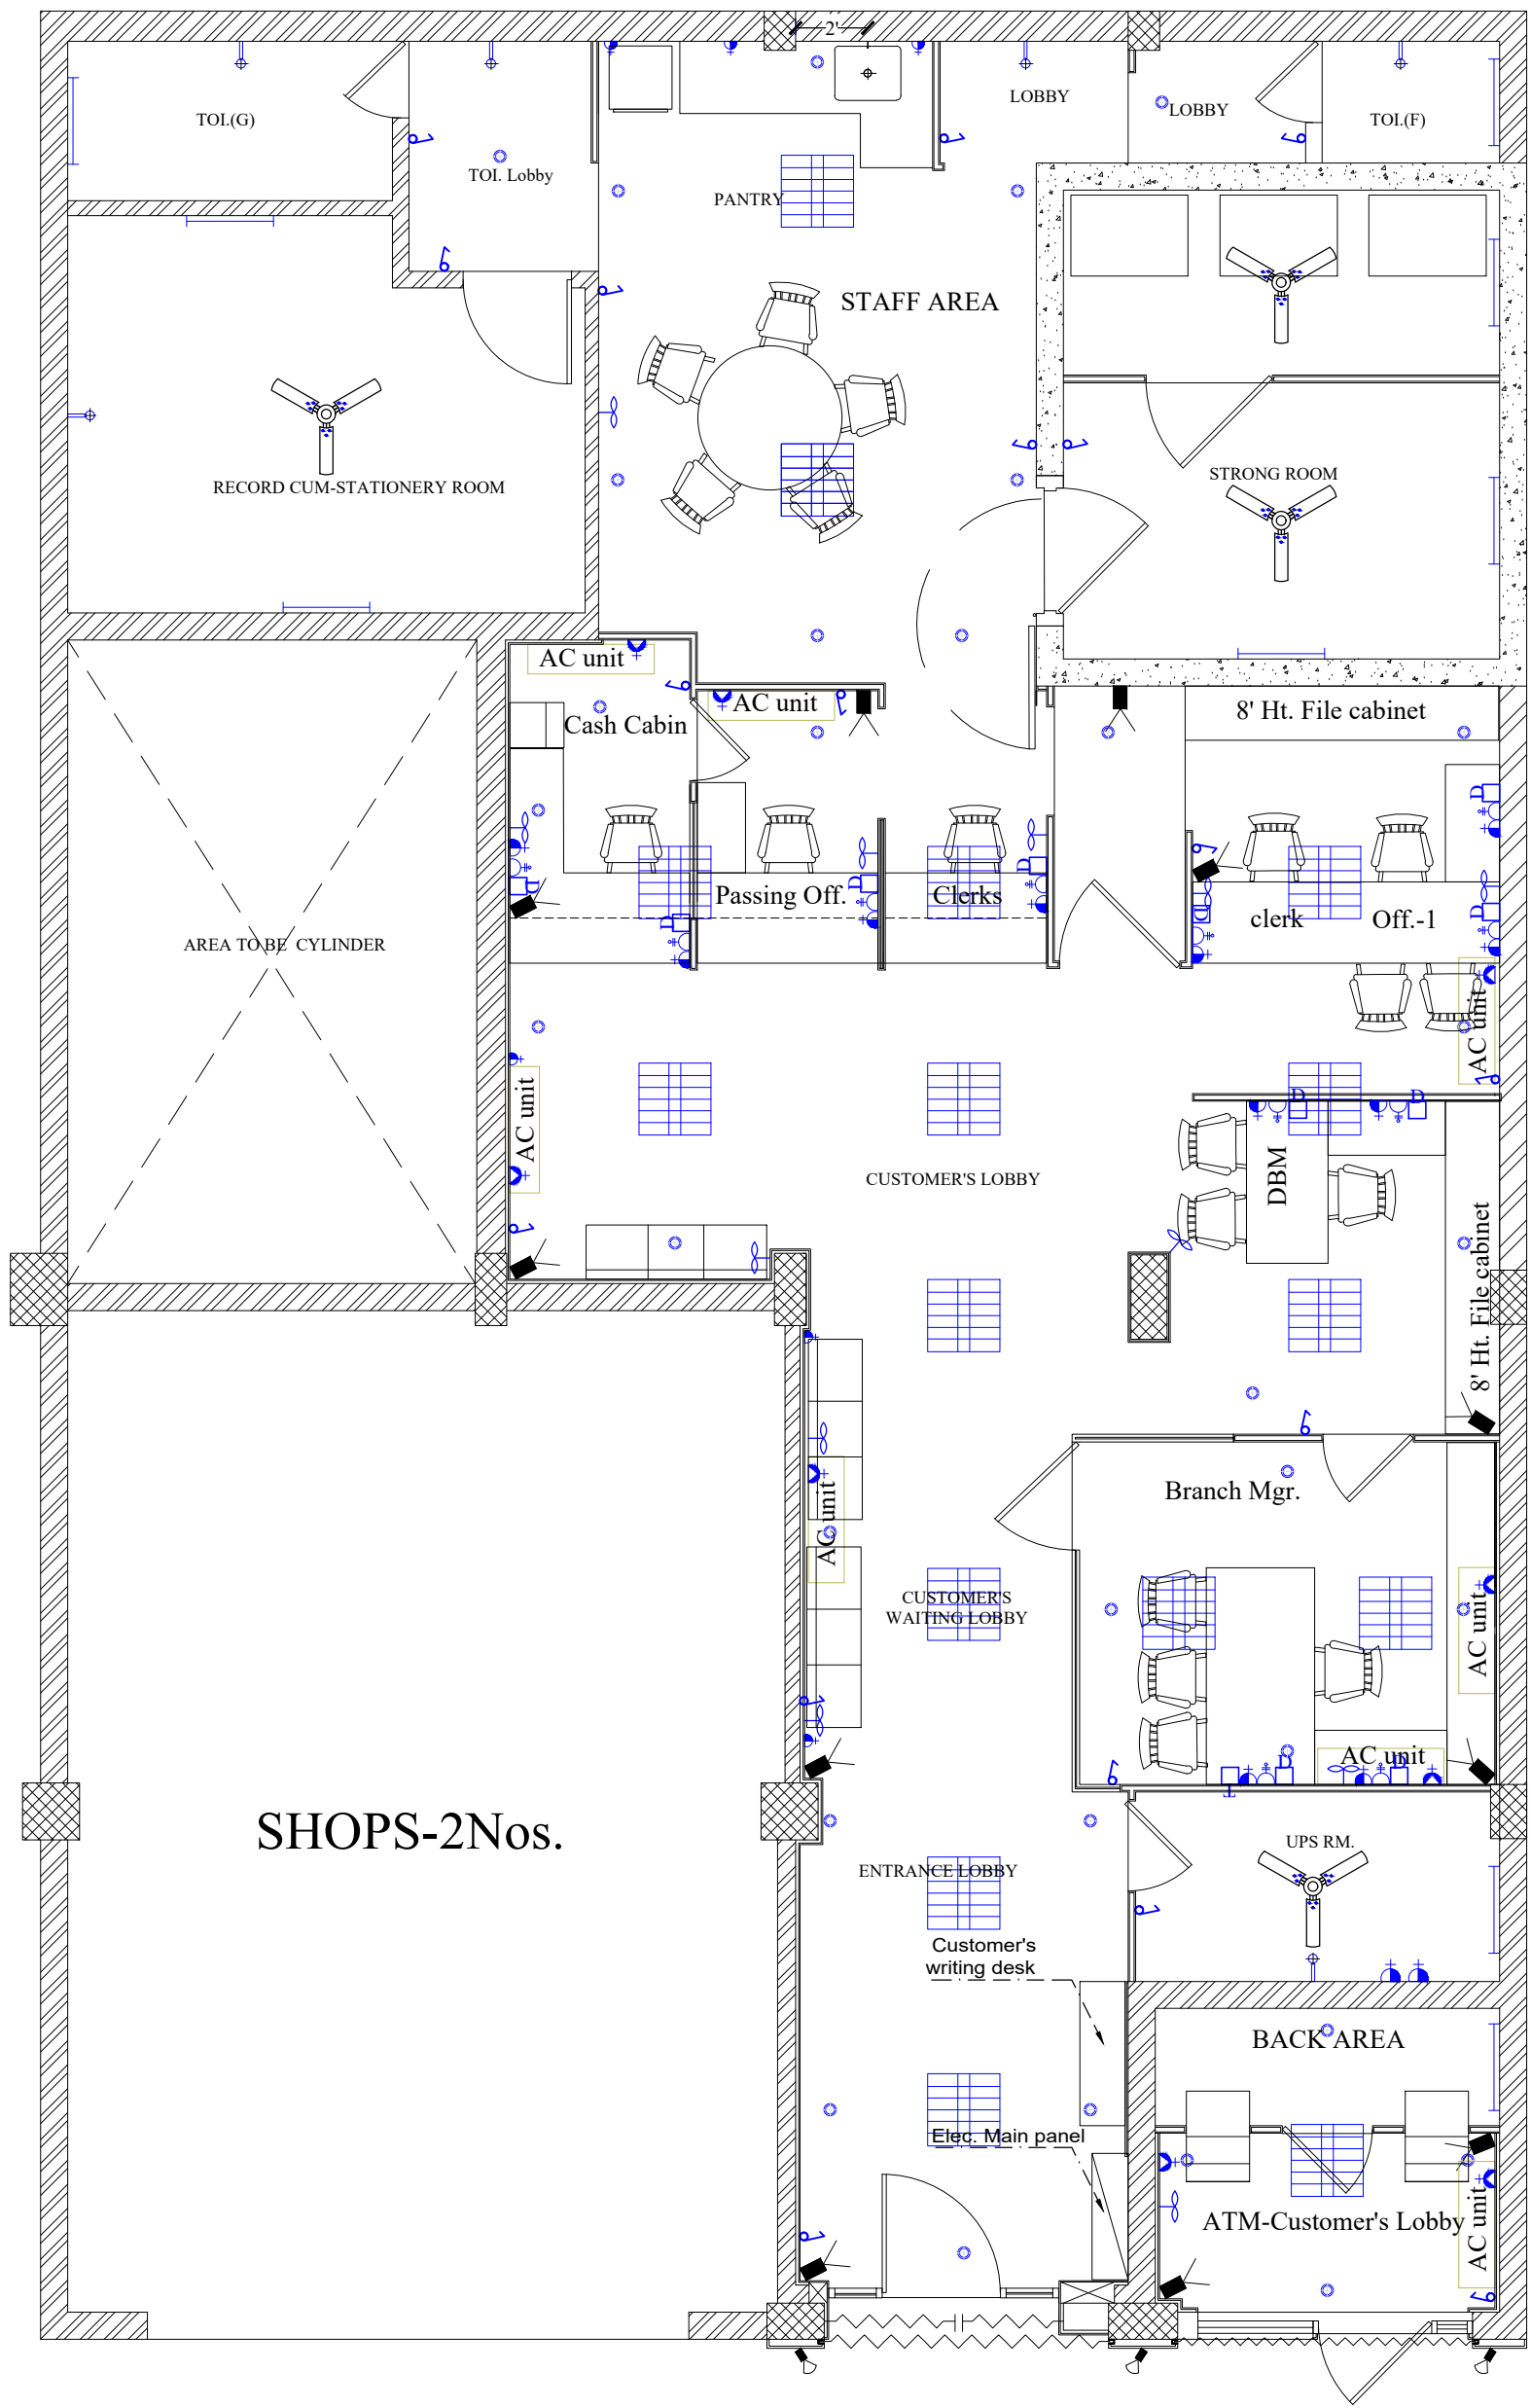

LEGENDS:-

QTY	SYM	DESCRIPTION
01	SW	SWITCH
02	SW	SWITCH
03	SW	SWITCH
100	SW	SWITCH

QTY	SYM	DESCRIPTION
01	SW	SWITCH
02	SW	SWITCH
03	SW	SWITCH
100	SW	SWITCH

PROJECT TITLE:

INDIAN BANK, RISHIKESH BRANCH, HARIDWAR

DRG. STATUS WORKING

DRG. TITLE:

PROPOSED ELECTRICAL LAYOUT

DRG. NO.: L-01 OF 01

DRG. DATE: Nove. 13, 2025

APPRD. BY

APPRD. DATE:

ARCHITECTS:

M. S. NEGI & ASSOCIATES



ARCHITECTS, INTERIOR DESIGNERS, PLANNERS,
GOVT. APPRD. VALUERS, VAASTU CONSULTANTS,
AND PROJECT MANAGEMENT
SUBHASH CHOWK, RAM NAGAR,
DISTT. NAINITAL, UTTARAKHAND,
PH. 0-9837203193

