
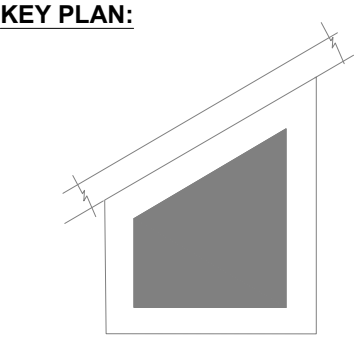


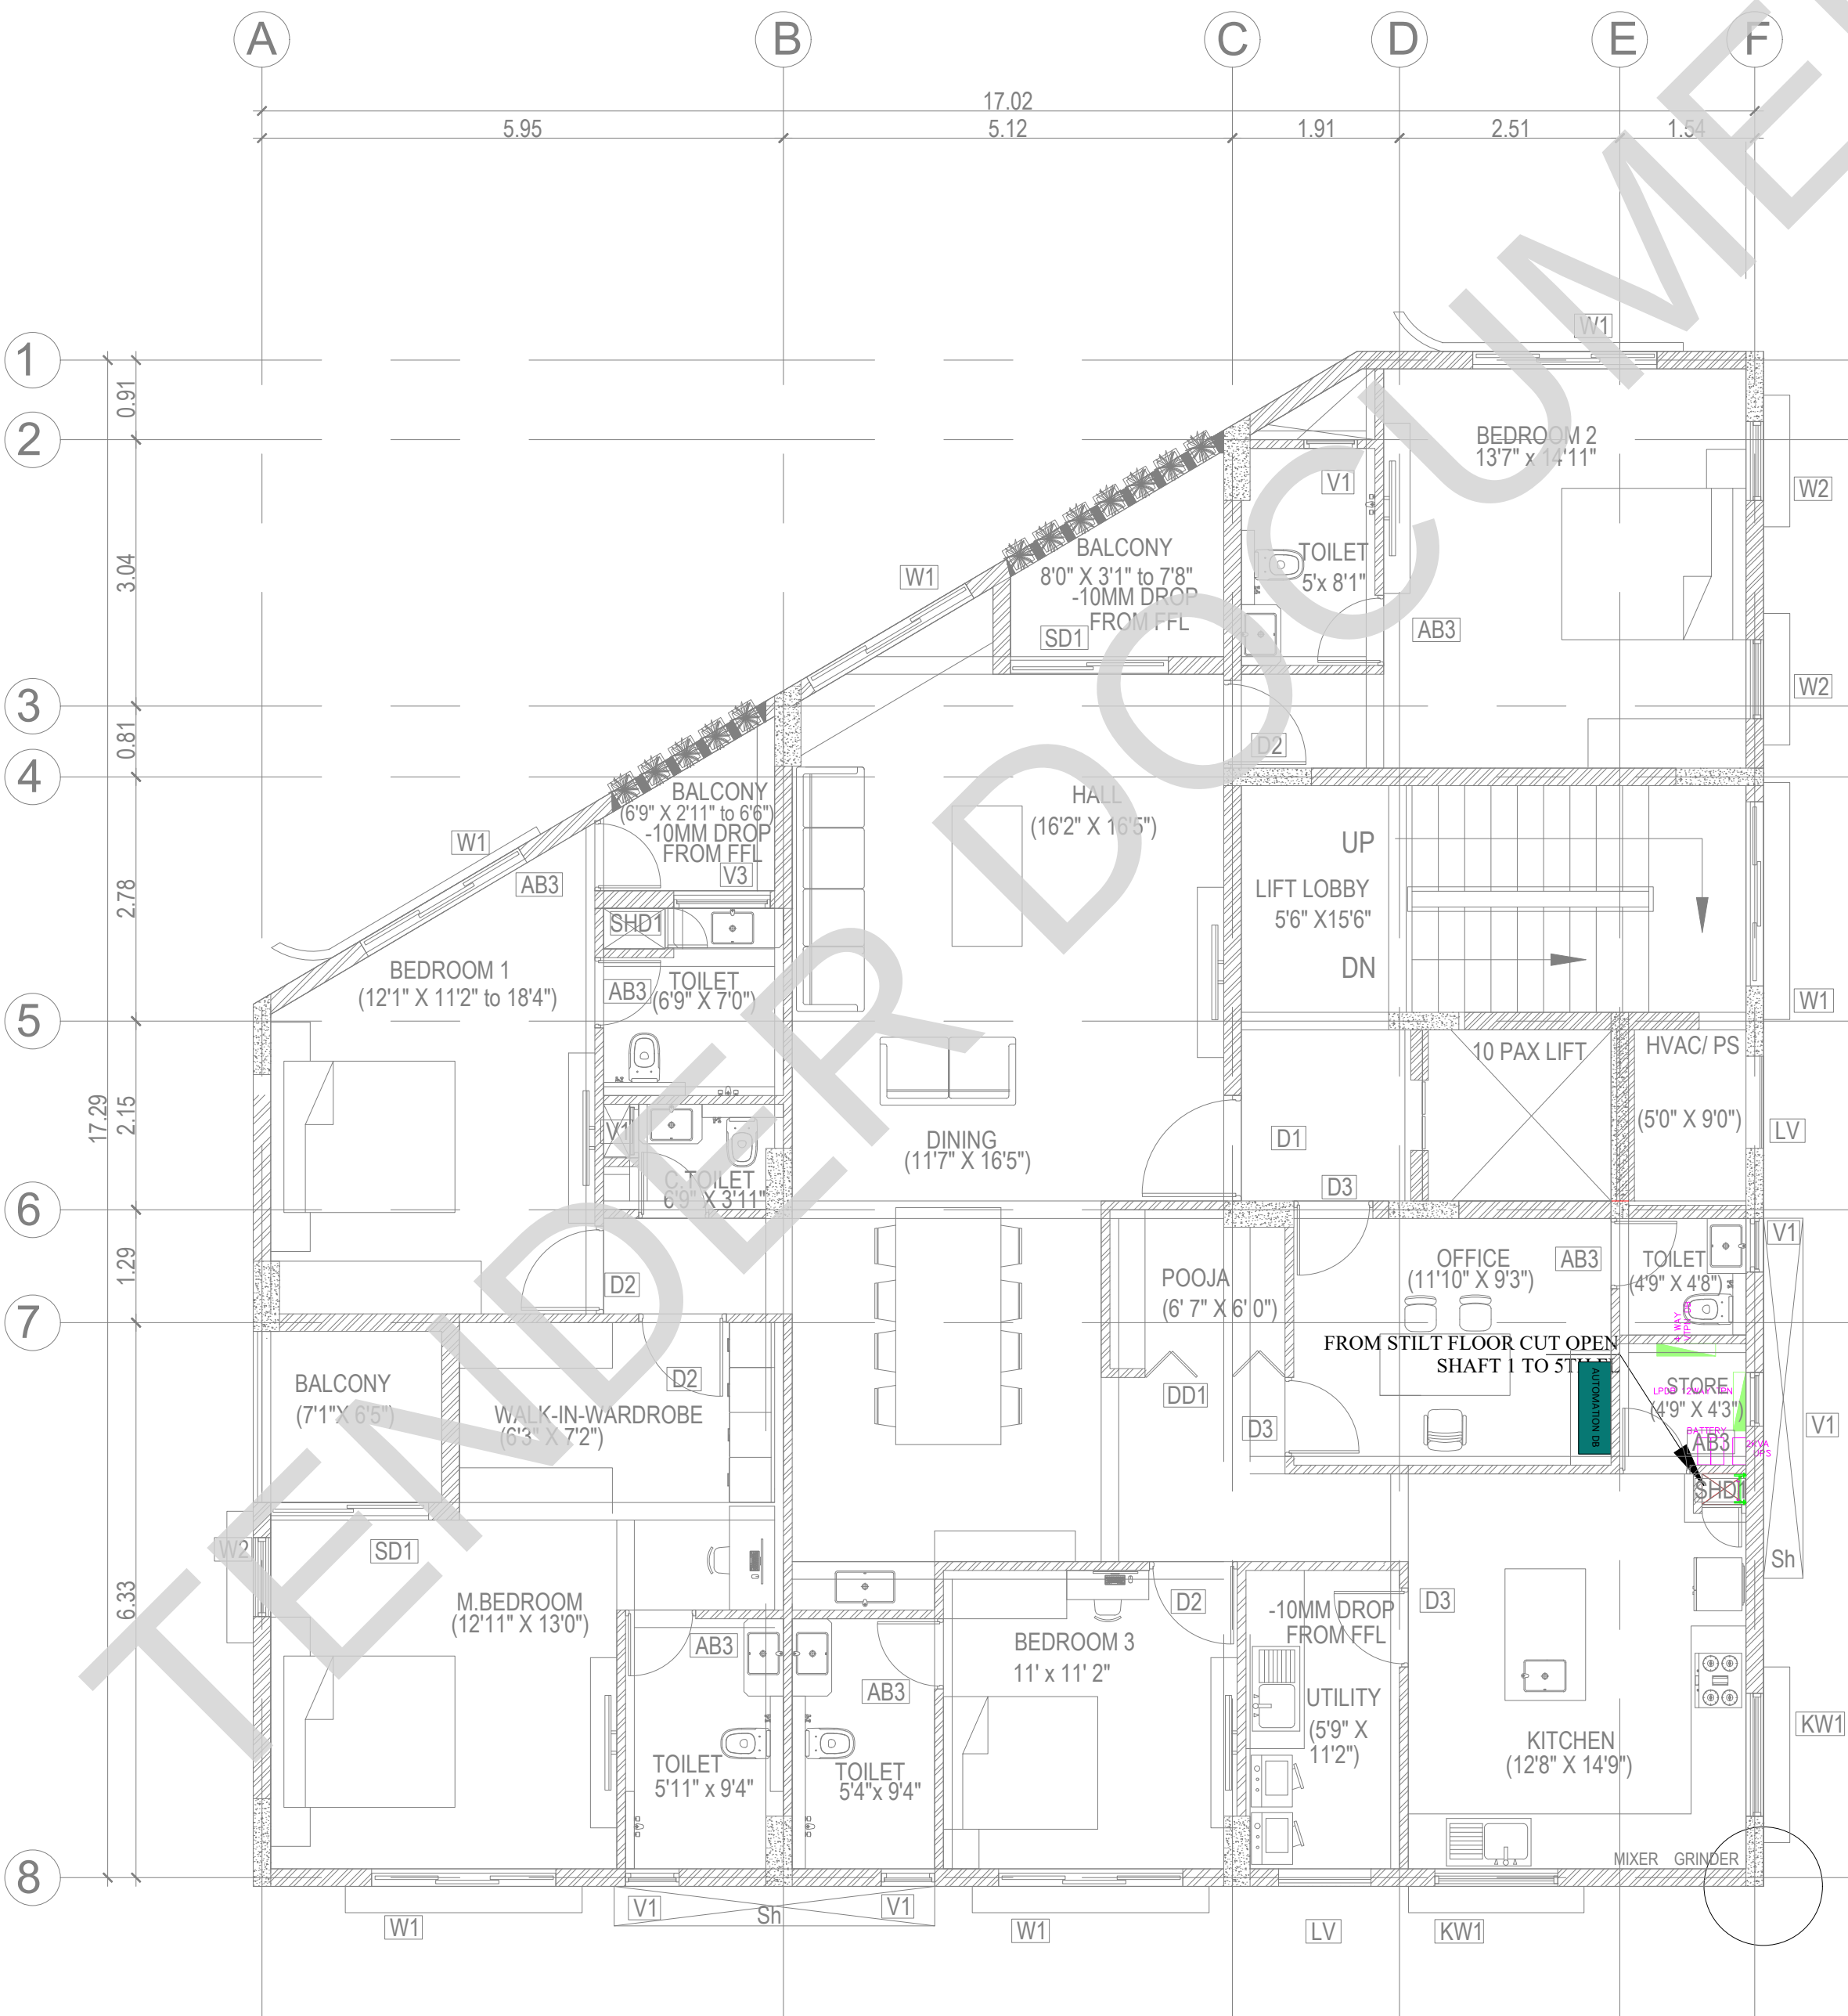

| LEGENDS: |                                                               |
|----------|---------------------------------------------------------------|
| SYMBOL   | DESCRIPTION                                                   |
|          | 1X45W LED STREET LIGHT FITTING<br>SINGLE ARM SMTR HEIGHT POLE |
|          | LED FLOOD LIGHT                                               |
|          | ELECTRICAL-HUME PIPE-300MM                                    |
|          | ELECTRICAL -HDPE PIPE-110MM                                   |
|          | ELV-HDPE PIPE-110MM                                           |
|          | 150mm (W) x 50mm (H) Ladder Type Cable Tray                   |
|          | 300mm (W) x 50mm (H) Ladder Type Cable Tray                   |
|          | 600mm (W) x 50mm (H) Ladder Type Cable Tray                   |
|          | ELECTRICAL MAN HOLE-1250X1250X1000MM                          |

| ABBREVIATIONS: |                  |
|----------------|------------------|
| ES -           | ELECTRICAL SHAFT |
| PS -           | PLUMBING SHAFT   |
| AC -           | AIR CONDITIONING |
| FS -           | FIRE SHAFT       |
| TS -           | TELEPHONE SHAFT  |

| REVISION |      |             |
|----------|------|-------------|
| NO.      | DATE | DESCRIPTION |
|          |      |             |
|          |      |             |
|          |      |             |
|          |      |             |
|          |      |             |
|          |      |             |

NOTE:  
ALL DIMENSIONS ARE IN METERS.  
ALL DIMENSIONS TO BE CHKD. AT SITE.  
DO NOT SCALE THE DRAWING  
IN THE EVENT OF ANY DISCREPANCIES OR DIFFERENCES BETWEEN  
ARCHITECT DRAWINGS,STRUCTURAL DRAWING AND SITE CONDITIONS,  
IMMEDIATE REFERENCE IS TO BE MADE TO THE ARCHITECT PRIOR TO THE  
EXECUTION OF WORK AT THE SITE.

**ARCHITECTS & EP CONSTRUCTION:**



**Taamaesek Engineering Consortium**  
New no. 5, Old no.2a, Bishop Wallers  
Avenue west, Mylapore,  
Chennai - 600 004. Ph:044-24671157/1139.  
Fax : 044-24672237.  
url:www.taamaesek.com  
e-mail: info@taamaesek.com

**CLIENT:**




**Indian Bank**  
M/s. INDIAN BANK  
254-260, INDIAN BANK CORPORATE OFFICE,  
AVVAI SHANMUGAM SALAI, ROYAPETTAH, CHENNAI - 4.

**PROJECT:**  
Tender ID: CO-EST-TNDR-MBG-001-2023-24  
PROPOSED CONSTRUCTION OF RESIDENTIAL BUILDING  
(Stilt + 5 Floors) @MUSIRI SUBRAMANIAM SALAI, CHENNAI – 600 004.

| DRAWING STAGE: INFORMATION COPY |            |                                                                                       |                  |  |
|---------------------------------|------------|---------------------------------------------------------------------------------------|------------------|--|
| DRAWN BY :                      | PS         |  | SHEET SIZE<br>A2 |  |
| CHECKED BY :                    | AK         |                                                                                       |                  |  |
| SCALE :                         | 1:1000     |                                                                                       |                  |  |
| DATE :                          | 19.09.2024 |                                                                                       |                  |  |

**DRAWING TITLE:**  
INTERNAL EECR TYPICAL FLOOR PLAN

|                                              |              |                       |                 |                |          |
|----------------------------------------------|--------------|-----------------------|-----------------|----------------|----------|
| Drawing number: TMA/292/1B/ELE & ELE /ELE-04 |              |                       |                 |                |          |
| Project code number                          | Project name | Stage of Construction | Type of Drawing | Drawing number | Revision |
| TMA-292                                      | IB           | IFC                   | ELECTRICAL      | ELE-04         | R1       |

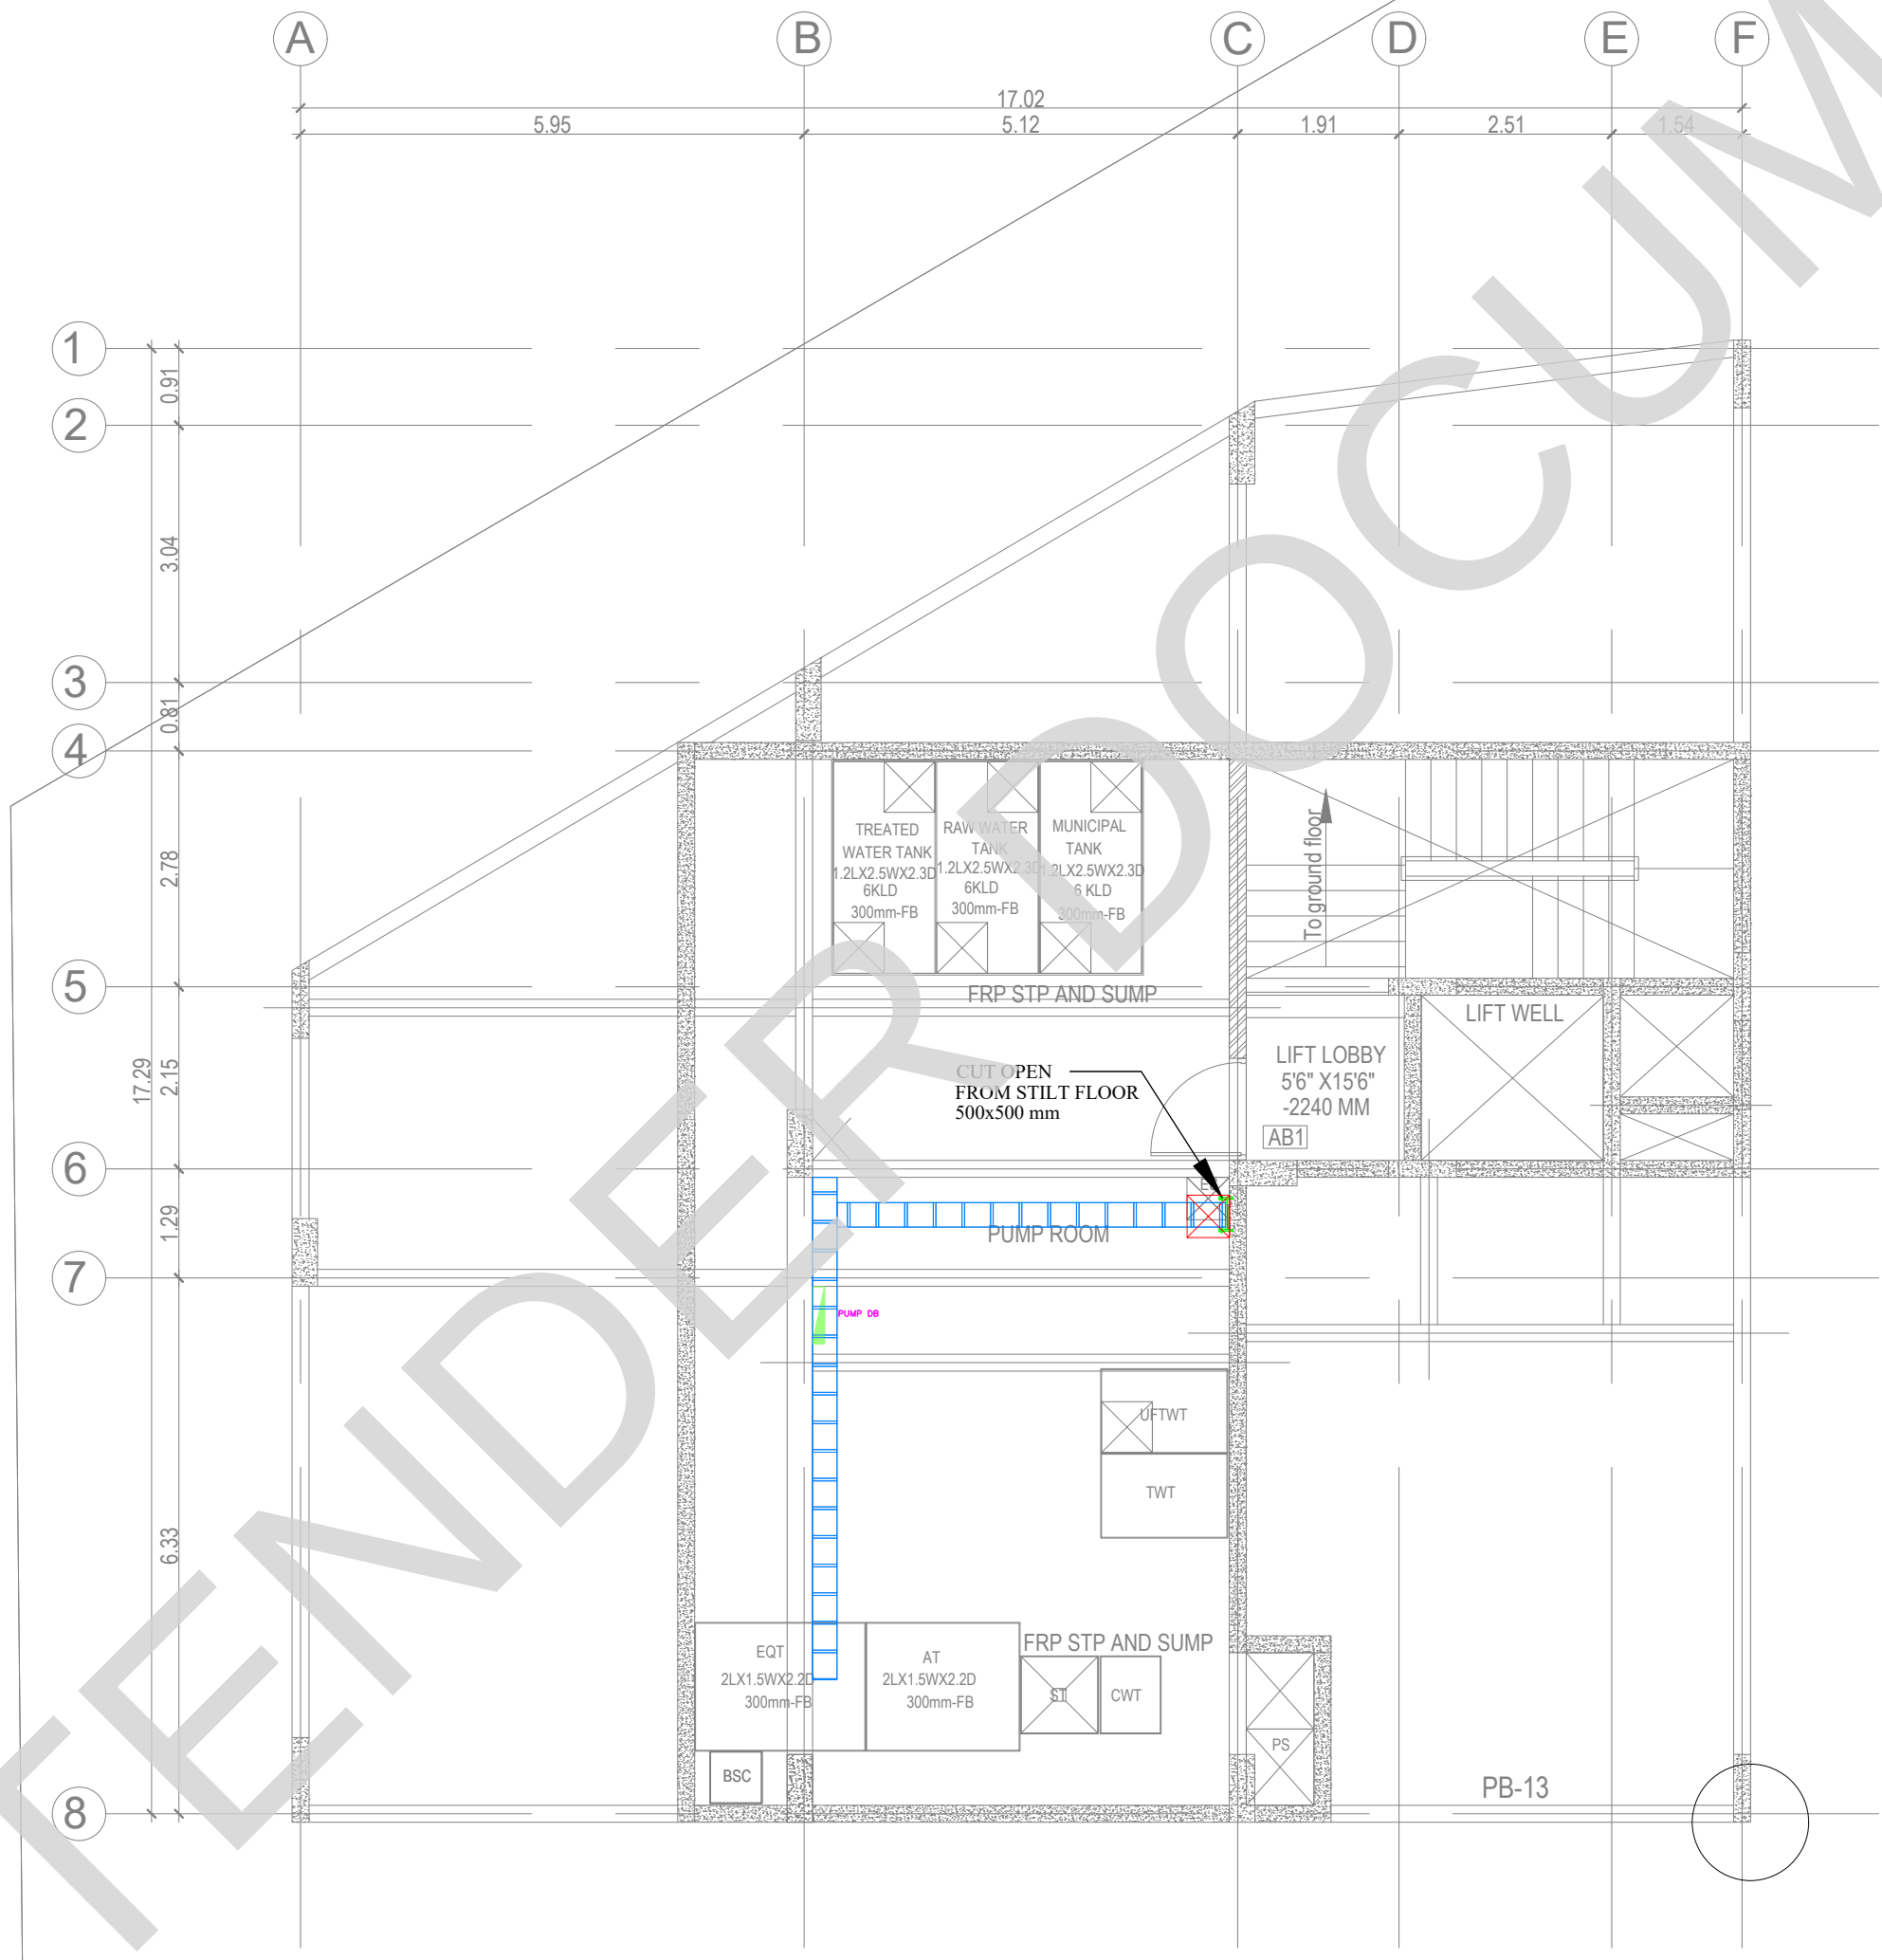

**KEY PLAN:**

**LEGENDS:**

| SYMBOL | DESCRIPTION                                                |
|--------|------------------------------------------------------------|
|        | 1X45W LED STREET LIGHT FITTING SINGLE ARM 8MTR HEIGHT POLE |
|        | LED FLOOD LIGHT                                            |
|        | ELECTRICAL-HUME PIPE-300MM                                 |
|        | ELECTRICAL-HDPE PIPE-110MM                                 |
|        | ELV-HDPE PIPE-110MM                                        |
|        | 150mm (W) x 50mm (H) Ladder Type Cable Tray                |
|        | 300mm (W) x 50mm (H) Ladder Type Cable Tray                |
|        | 600mm (W) x 50mm (H) Ladder Type Cable Tray                |
|        | ELECTRICAL MAN HOLE-1250X1250X1000MM                       |

- ABBREVIATIONS:**
- ES - ELECTRICAL SHAFT
  - PS - PLUMBING SHAFT
  - AC - AIR CONDITIONING
  - FS - FIRE SHAFT
  - TS - TELEPHONE SHAFT

| REVISION | NO. | DATE | DESCRIPTION |
|----------|-----|------|-------------|
|          |     |      |             |
|          |     |      |             |
|          |     |      |             |
|          |     |      |             |

NOTE:  
ALL DIMENSIONS ARE IN METERS.  
ALL DIMENSIONS TO BE CHKD. AT SITE.  
DO NOT SCALE THE DRAWING  
IN THE EVENT OF ANY DISCREPANCIES OR DIFFERENCES BETWEEN ARCHITECT DRAWINGS, STRUCTURAL DRAWING AND SITE CONDITIONS, IMMEDIATE REFERENCE IS TO BE MADE TO THE ARCHITECT PRIOR TO THE EXECUTION OF WORK AT THE SITE.

**ARCHITECTS & EP CONSTRUCTION:**

Taamaesek Engineering Consortium  
New no. 5, Old no.2a, Bishop Wallers  
Avenue west, Mylapore,  
Chennai - 600 004. Ph:044-24671157/1139.  
Fax : 044-24672237.  
url:www.taamaesek.com  
e-mail: info@taamaesek.com

**CLIENT:**

M/s. INDIAN BANK  
254-260, INDIAN BANK CORPORATE OFFICE,  
AVVAI SHANMUGAM SALAI, ROYAPETTAH, CHENNAI - 4.

**PROJECT:**

Tender ID: CO-EST-TNDR-MBG-001-2023-24  
PROPOSED CONSTRUCTION OF RESIDENTIAL BUILDING  
(Stilt + 5 Floors) @MUSIRI SUBRAMANIAM SALAI, CHENNAI – 600 004.

| DRAWING STAGE: INFORMATION COPY |            |                                                                                       |            |    |
|---------------------------------|------------|---------------------------------------------------------------------------------------|------------|----|
| DRAWN BY :                      | PS         |  | SHEET SIZE | A2 |
| CHECKED BY:                     | AK         |                                                                                       |            |    |
| SCALE :                         | 1:1000     |                                                                                       |            |    |
| DATE :                          | 19.09.2024 |                                                                                       |            |    |

**DRAWING TITLE:**


INTERNAL EECR BASEMENT FLOOR PLAN

| Drawing number: TMA/292/1B/ELE & ELE /ELE-02 |              |                       |                 |                |
|----------------------------------------------|--------------|-----------------------|-----------------|----------------|
| Project code number                          | Project name | Stage of Construction | Type of Drawing | Drawing number |
| TMA-292                                      | IB           | IFC                   | ELECTRICAL      | ELE-02         |





KEY PLAN:

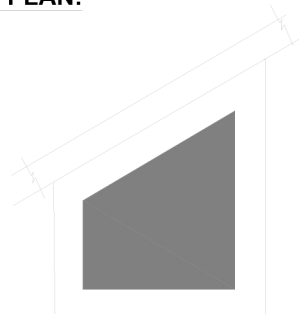

LEGENDS:

| SYMBOL | DESCRIPTION                                                   |
|--------|---------------------------------------------------------------|
|        | 1X45W LED STREET LIGHT FITTING<br>SINGLE ARM 8MTR HEIGHT POLE |
|        | LED FLOOD LIGHT                                               |
|        | ELECTRICAL-HUME PIPE-300MM                                    |
|        | ELECTRICAL -HDPE PIPE-110MM                                   |
|        | ELV-HDPE PIPE-110MM                                           |
|        | 150mm (W) x 50mm (H) Ladder Type Cable Tray                   |
|        | 300mm (W) x 50mm (H) Ladder Type Cable Tray                   |
|        | 450mm (W) x 50mm (H) Ladder Type Cable Tray                   |
|        | P1 ELECTRICAL MAN HOLE-1250X1250X1000MM                       |

ABBREVIATIONS:

|      |                  |
|------|------------------|
| ES - | ELECTRICAL SHAFT |
| PS - | PLUMBING SHAFT   |
| AC - | AIR CONDITIONING |
| FS - | FIRE SHAFT       |
| TS - | TELEPHONE SHAFT  |

REVISION

| NO. | DATE | DESCRIPTION. |
|-----|------|--------------|
|-----|------|--------------|

NOTE:  
ALL DIMENSIONS ARE IN METERS.  
ALL DIMENSIONS TO BE CHKD. AT SITE.  
DO NOT SCALE THE DRAWING  
IN THE EVENT OF ANY DISCREPANCIES OR DIFFERENCES BETWEEN  
ARCHITECT DRAWINGS,STRUCTURAL DRAWING AND SITE CONDITIONS,  
IMMEDIATE REFERENCE IS TO BE MADE TO THE ARCHITECT PRIOR TO THE  
EXECUTION OF WORK AT THE SITE.

ARCHITECTS & EP CONSTRUCTION:



Taamaesek Engineering Consortium  
New no. 5, Old no.2a, Bishop Wallers  
Avenue west, Mylapore,  
Chennai - 600 004. Ph:044-24671157/1139.  
Fax : 044-24672237.  
url:www.taamaesek.com  
e-mail: info@taamaesek.com

CLIENT:



Ms. INDIAN BANK  
254-280, INDIAN BANK CORPORATE OFFICE,  
AVVAI SHANMUGAM SALAI, ROYAPETTAH, CHENNAI - 4.

PROJECT:

Tender ID: CO.EST.TNDR.MBG.001.2023-24  
PROPOSED CONSTRUCTION OF RESIDENTIAL BUILDING  
(Still + 5 Floors) @MUSIRI SUBRAMANIAM SALAI, CHENNAI – 600 004.

DRAWING STAGE:INFORMATION COPY

|             |            |
|-------------|------------|
| DRAWN BY :  | PS         |
| CHECKED BY: | AK         |
| SCALE :     | 1:1000     |
| DATE :      | 19.09.2024 |





DRAWING TITLE:

INTERNAL EECR GROUND FLOOR PLAN

Drawing number: TMA/292/IB/ELE & ELE /ELE-03

| Project code number | Project name | Stage of Construction | Type of Drawing | Drawing number | Revision |
|---------------------|--------------|-----------------------|-----------------|----------------|----------|
| TMA-292             | IB           | IFC                   | ELECTRICAL      | ELE-03         | R1       |



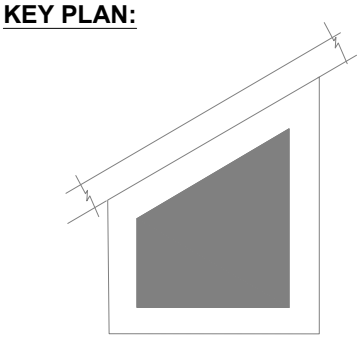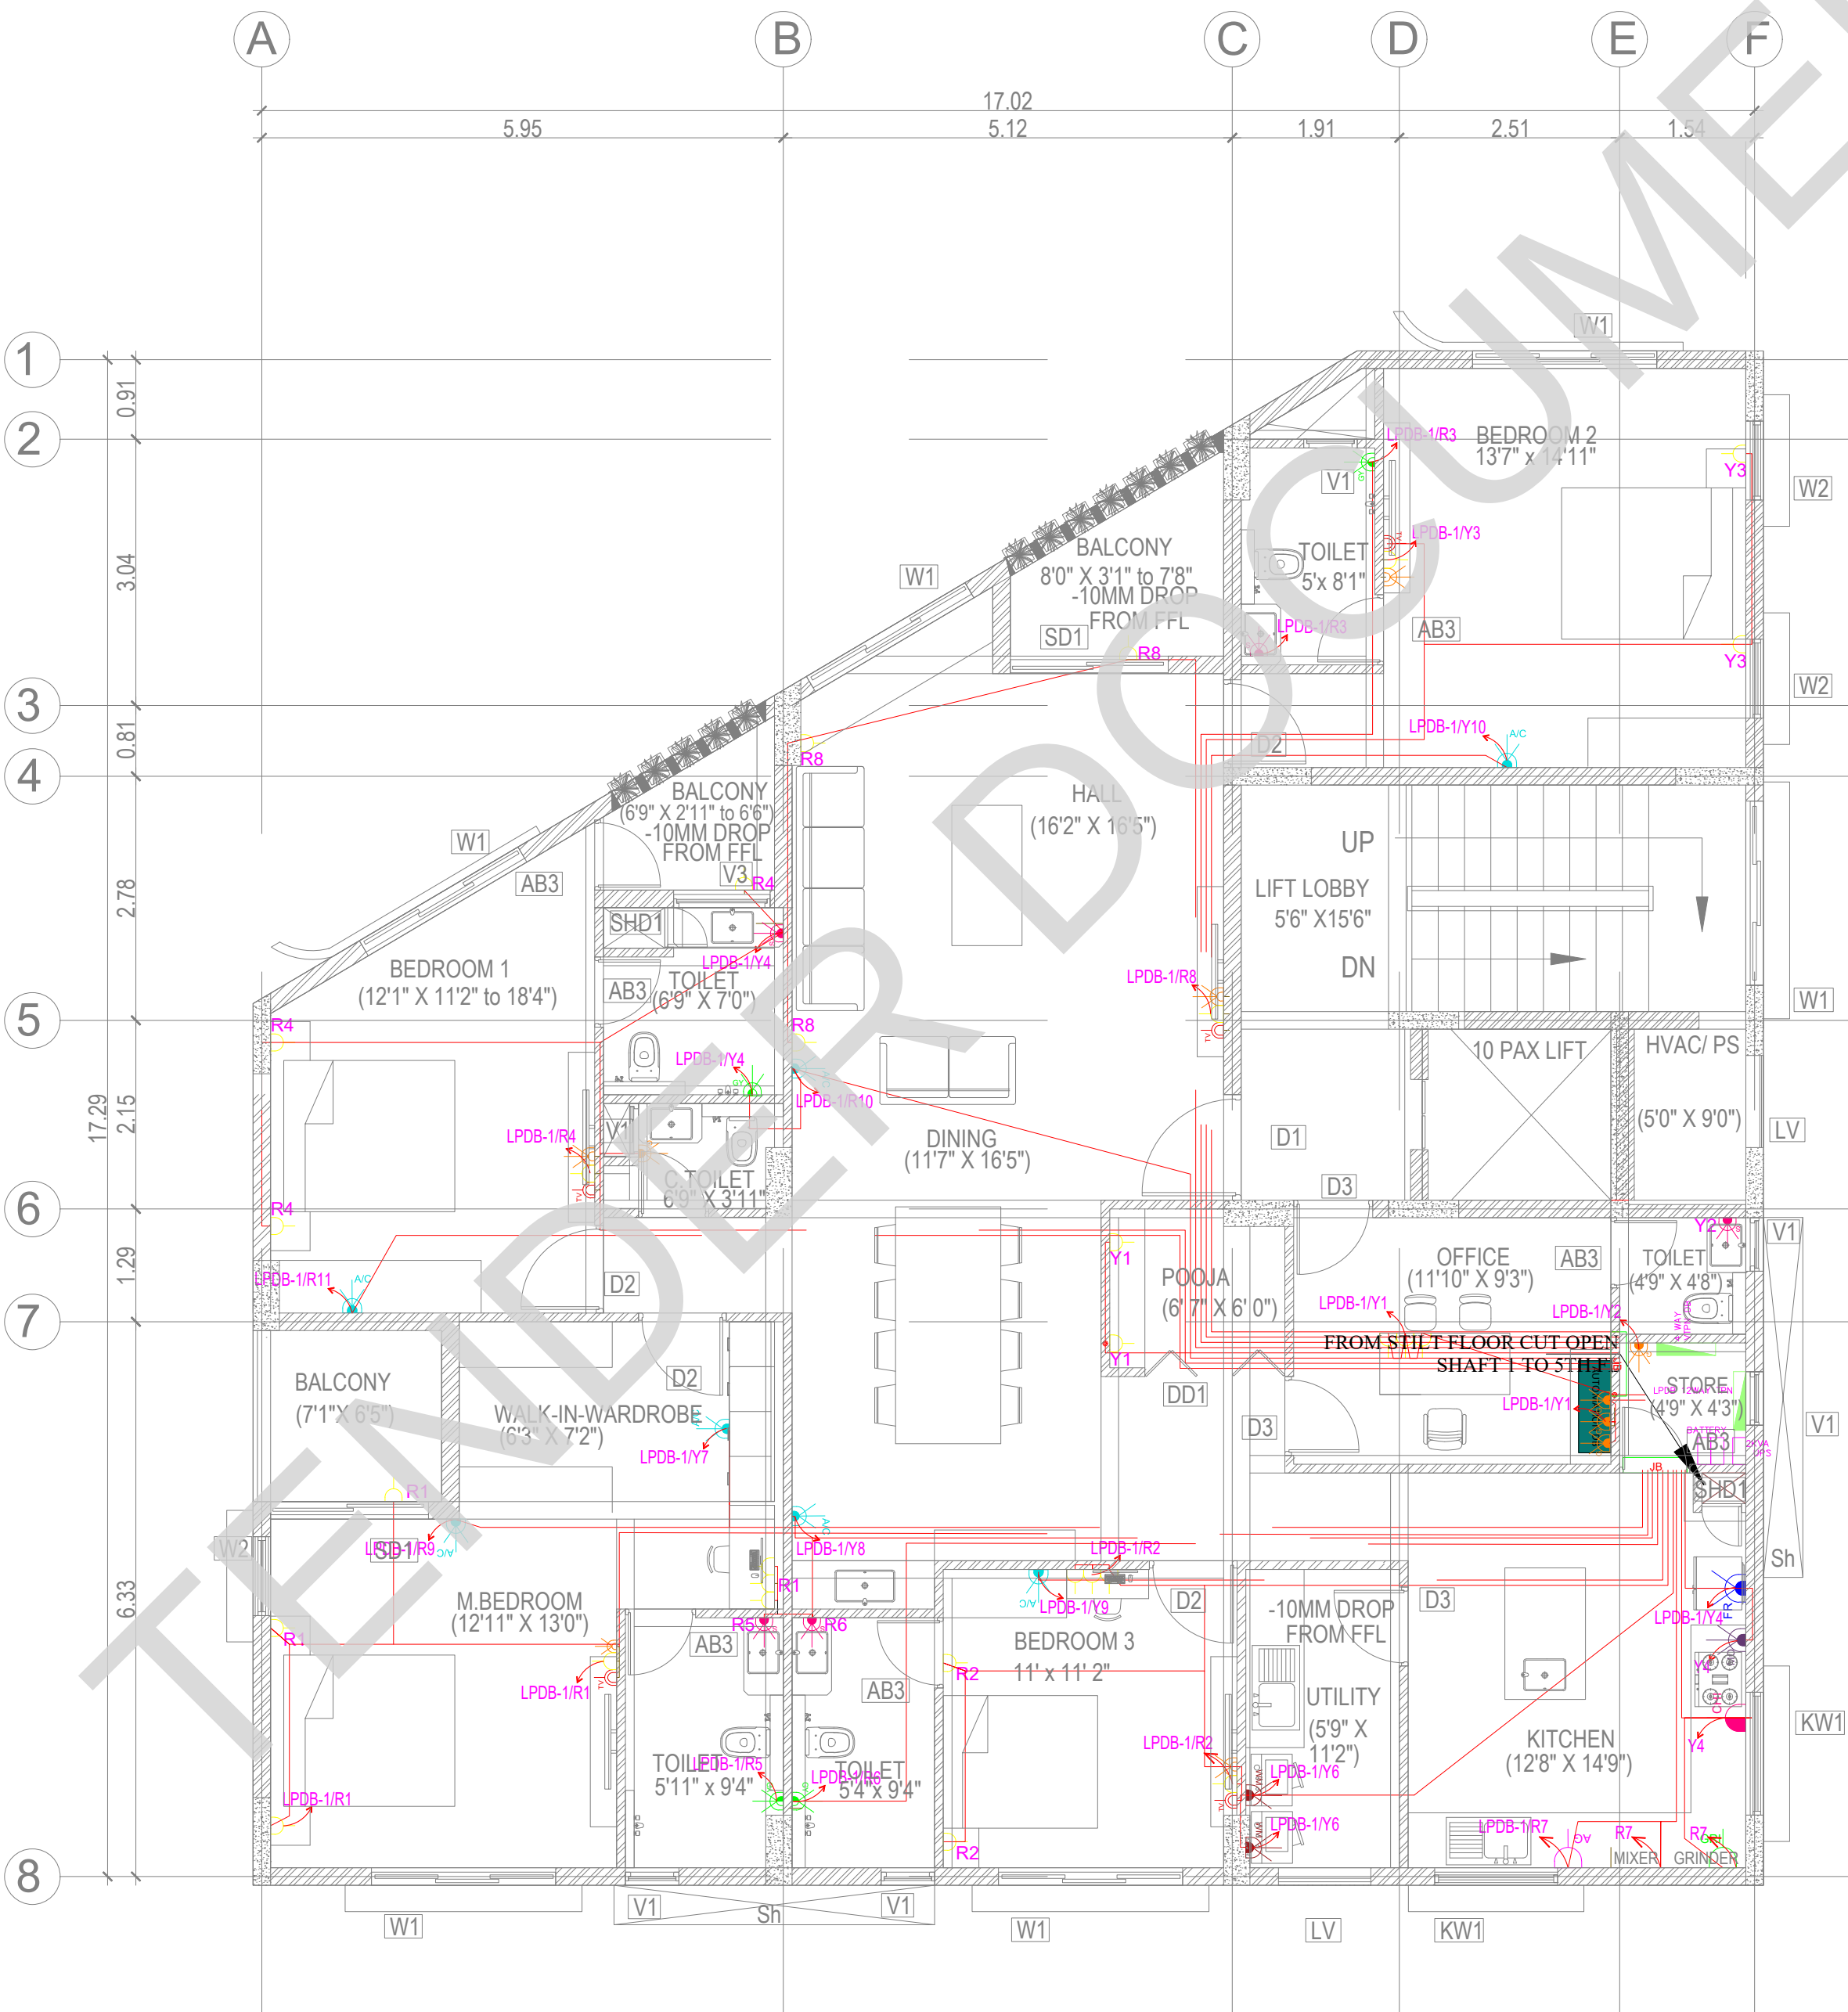

SCHEDULE OF JOINERY:

SCHEDULE OF DOORS:

SCHEDULE OF WINDOWS:

LEGENDS:

| SYMBOL | DESCRIPTION                                          |
|--------|------------------------------------------------------|
|        | 6A SOCKET FOR GENERAL PURPOSE                        |
|        | 16A SWITCH WITH SOCKET FOR WASHING MACHINE           |
|        | SWITCH BOARD WITHOUT SOCKET                          |
|        | 6/16A SWITCH WITH SOCKET FOR SHAVER                  |
|        | 16A SOCKET FOR GEYSER                                |
|        | 6A SOCKET FOR EXHAUST FAN                            |
|        | 6A SWITCH WITH SOCKET FOR AQUA                       |
|        | 16A SOCKET FOR CHIMNEY                               |
|        | 16A SWITCH WITH SOCKET FOR HUB                       |
|        | 6A SWITCH SOCKET FOR GAS DETECTOR                    |
|        | 16A SWITCH WITH SOCKET FOR MIXER                     |
|        | 16A SWITCH WITH SOCKET FOR GRINDER                   |
|        | 6/16A SWITCH WITH SOCKET FOR MICRO OVEN              |
|        | 16A SWITCH WITH SOCKET FOR HAND DRYER                |
|        | 2NOS 6A SWITCH SOCKET FOR GENERAL                    |
|        | 16A SOCKET FOR AC                                    |
|        | 16A SOCKET FOR BATH TUB                              |
|        | 6/16A SWITCH WITH SOCKET FOR GENERAL                 |
|        | 2NOS 6/16A SWITCH SOCKET FOR HOME THEATRE            |
|        | 2 NOS 6A SWITCH 3 NOS 6A SOCKET FOR TV               |
|        | 16A, 3PIN SOCKET (AIR CONDITIONER) AT NEAR INDOOR AC |
|        | 6/16A SWITCH SOCKET FOR REFRIGERATOR                 |
|        | ELECTRICAL ISOLATOR WITH WEATHER PROOF ENCLOSURE     |

REVISION

| NO. | DATE | DESCRIPTION |
|-----|------|-------------|
|-----|------|-------------|

NOTE:  
ALL DIMENSIONS ARE IN METERS.  
ALL DIMENSIONS TO BE CHKD. AT SITE.  
DO NOT SCALE THE DRAWING  
IN THE EVENT OF ANY DISCREPANCIES OR DIFFERENCES BETWEEN  
ARCHITECT DRAWINGS, STRUCTURAL DRAWING AND SITE CONDITIONS,  
IMMEDIATE REFERENCE IS TO BE MADE TO THE ARCHITECT PRIOR TO THE  
EXECUTION OF WORK AT THE SITE.

ARCHITECTS & EP CONSTRUCTION:

**Taamaesek Engineering Consortium**  
New no. 5, Old no.2a, Bishop Wallers  
Avenue west, Mylapore,  
Chennai - 600 004. Ph:044-24671157/1139.  
Fax : 044-24672237.  
url:www.taamaesek.com  
e-mail: info@taamaesek.com

CLIENT:



M/s. INDIAN BANK  
254-260, INDIAN BANK CORPORATE OFFICE,  
AVVAI SHANMUGAM SALAI, ROYAPETTAH, CHENNAI - 4.

PROJECT:

Tender ID: CO-EST-TNDR-MBG-001-2023-24  
PROPOSED CONSTRUCTION OF RESIDENTIAL BUILDING  
(Shift + 5 Floors) @MUSIRI SUBRAMANIAM SALAI, CHENNAI - 600 004.

DRAWING STAGE: INFORMATION COPY


|              |            |  |
|--------------|------------|--|
| DRAWN BY :   | PS         |  |
| CHECKED BY : | AK         |  |
| SCALE :      | 1:1000     |  |
| DATE :       | 19.09.2024 |  |

DRAWING TITLE:


TYPICAL FLOOR POWER LAYOUT

Drawing number: TMA/292/1B/ELE & EL /ELE-12

| Project code number | Project name | Stage of Construction | Type of Drawing | Drawing number | Revision |
|---------------------|--------------|-----------------------|-----------------|----------------|----------|
| TMA-292             | IB           | IFC                   | ELECTRICAL      | ELE-12         | R1       |

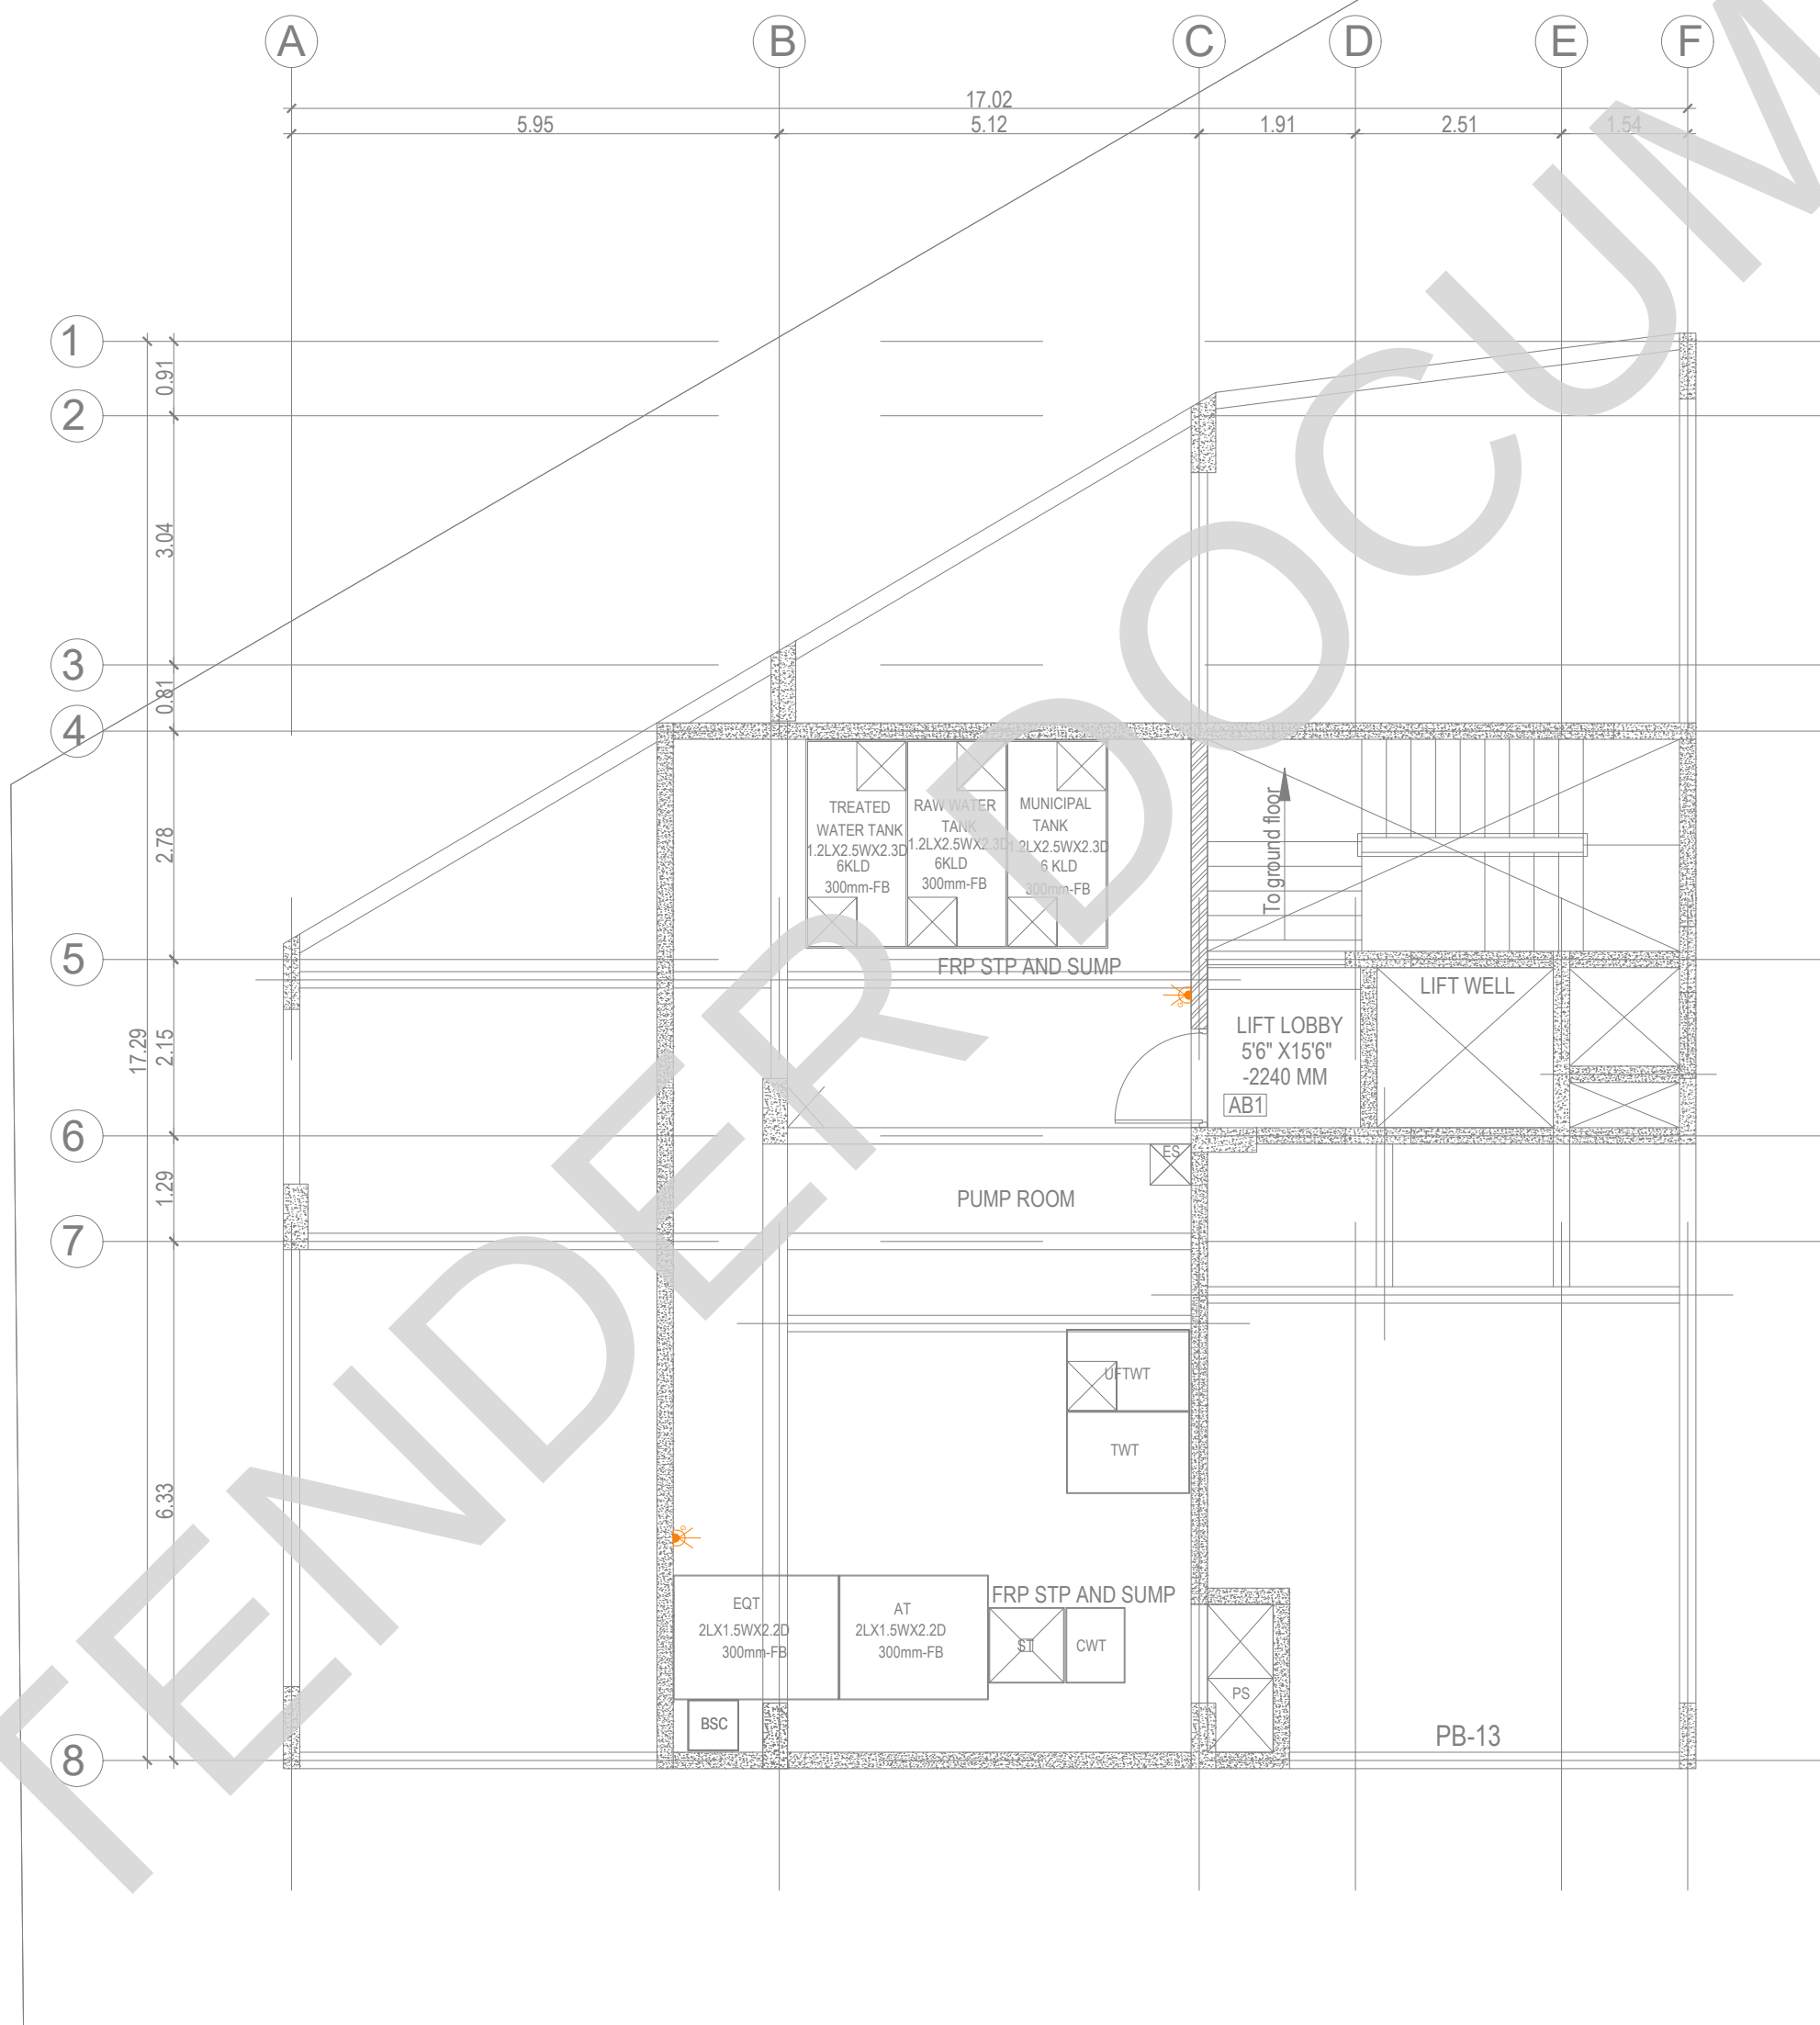

BASEMENT FLOOR PLAN

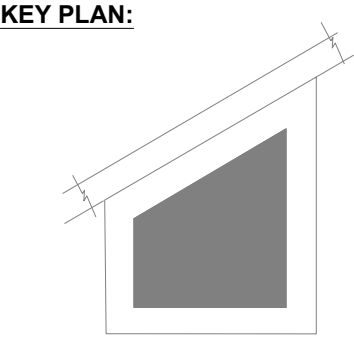

SCHEDULE OF JOINERY:

SCHEDULE OF DOORS:

SCHEDULE OF WINDOWS:

LEGENDS:

| SYMBOL | DESCRIPTION                                          |
|--------|------------------------------------------------------|
|        | 6A SOCKET FOR GENERAL PURPOSE                        |
|        | 16A SWITCH WITH SOCKET FOR WASHING MACHINE           |
|        | SWITCH BOARD WITHOUT SOCKET                          |
|        | 6/16A SWITCH WITH SOCKET FOR SHAVER                  |
|        | 16A SOCKET FOR GEYSER                                |
|        | 6A SOCKET FOR EXHAUST FAN                            |
|        | 6A SWITCH WITH SOCKET FOR AQUA                       |
|        | 16A SOCKET FOR CHIMNEY                               |
|        | 16A SWITCH WITH SOCKET FOR HUB                       |
|        | 6A SWITCH SOCKET FOR GAS DETECTOR                    |
|        | 16A SWITCH WITH SOCKET FOR MIXER                     |
|        | 16A SWITCH WITH SOCKET FOR GRINDER                   |
|        | 6/16A SWITCH WITH SOCKET FOR MICRO OVEN              |
|        | 16A SWITCH WITH SOCKET FOR HAND DRYER                |
|        | 2NOS 6A SWITCH SOCKET FOR GENERAL                    |
|        | 16A SOCKET FOR AC                                    |
|        | 16A SOCKET FOR BATH DUB                              |
|        | 6/16A SWITCH WITH SOCKET FOR GENERAL                 |
|        | 2NOS 6/16A SWITCH SOCKET FOR HOME THEATRE            |
|        | 2 NOS 6A SWITCH 3 NOS 6ASOCKET FOR TV                |
|        | 16A, 3PIN SOCKET (AIR CONDITIONER) AT NEAR INDOOR AC |
|        | 6/16A SWITCH SOCKET FOR REFRIGERATOR                 |
|        | ELECTRICAL ISOLATOR WITH WEATHER PROOF ENCLOSURE     |

REVISION

| NO. | DATE | DESCRIPTION. |
|-----|------|--------------|
|-----|------|--------------|

NOTE:  
ALL DIMENSIONS ARE IN METERS.  
ALL DIMENSIONS TO BE CHKD. AT SITE.  
DO NOT SCALE THE DRAWING  
IN THE EVENT OF ANY DISCREPANCIES OR DIFFERENCES BETWEEN  
ARCHITECT DRAWINGS, STRUCTURAL DRAWING AND SITE CONDITIONS,  
IMMEDIATE REFERENCE IS TO BE MADE TO THE ARCHITECT PRIOR TO THE  
EXECUTION OF WORK AT THE SITE.

ARCHITECTS & EP CONSTRUCTION:

 Taamaesek Engineering Consortium  
New no. 5, Old no.2a, Bishop Wallers  
Avenue west, Mylapore,  
Chennai - 600 004. Ph:044-24671157/1139.  
Fax : 044-24672237.  
url:www.taamaesek.com  
e-mail: info@taamaesek.com

CLIENT:



M/s. INDIAN BANK  
254-260, INDIAN BANK CORPORATE OFFICE,  
AVVAI SHANMUGAM SALAI, ROYAPETTAH, CHENNAI - 4.

PROJECT:

Tender ID: CO-EST-TNDR-MBG-001-2023-24  
PROPOSED CONSTRUCTION OF RESIDENTIAL BUILDING  
(Shift + 5 Floors) @MUSIRI SUBRAMANIAM SALAI, CHENNAI - 600 004.

DRAWING STAGE: INFORMATION COPY

|             |            |                                                                                                           |
|-------------|------------|-----------------------------------------------------------------------------------------------------------|
| DRAWN BY :  | PS         | <br>SHEET SIZE<br>A2 |
| CHECKED BY: | AK         |                                                                                                           |
| SCALE :     | 1:1000     |                                                                                                           |
| DATE :      | 19.09.2024 |                                                                                                           |

DRAWING TITLE:

BASEMENT FLOOR POWER LAYOUT

Drawing number: TMA/292/1B/ELE & EL /ELE-10

| Project code number | Project name | Stage of Construction | Type of Drawing | Drawing number | Revision |
|---------------------|--------------|-----------------------|-----------------|----------------|----------|
| TMA-292             | IB           | IFC                   | ELECTRICAL      | ELE-10         | R1       |

8 7 6 5 4 3 2 1

NOTES

1. ANY ADDITION OR MODIFICATION OF EQUIPMENTS ON TERRACE THEN LIGHTNING PROTECTION SYSTEM NEEDS TO BE UPDATED ACCORDINGLY.
2. THE LEVEL OF PROTECTION IS ARRIVED BASED ON THE RISK ASSESSMENT (IS/IEC-62305-2) AND DESIGN IS MADE ACCORDINGLY.
3. IF THE DOWN CONDUCTOR CAN'T BE ROUTED IN EQUAL SPACING, 20% TOLERANCE IS ACCEPTED AS PER IS/IEC 62305-3.
4. THE PROPOSED EARTHING SYSTEM SHALL BE INSTALLED AT 0.5M DEPTH AND 1M AWAY FROM BUILDING PERIPHERY. ATLEAST 80% OF THE TOTAL EARTHING CONDUCTOR LENGTH SHOULD BE LAYED IN SOIL.
5. THE EARTH ELECTRODE LOCATIONS SHOWN ARE TENTATIVE, THE SAME CAN BE INSTALLED AS PER THE SITE CONDITIONS.
6. HIGH TENSILE CU BONDED STEEL ROD IS RECOMMENDED FOR EARTH ELECTRODES, THE SAME SHALL BE TESTED TESTED AS PER IEC 62561-2-2018.
7. MAINTENANCE FREE EARTH ENHANCEMENT COMPOUND IS RECOMMENDED FOR THE EARTHING SYSTEM. THE SAME SHALL BE TESTED AS PER IEC 62561-7-2018.
8. ALL THE COMPONENTS USED IN LIGHTNING PROTECTION SYSTEM SHALL BE TESTED AS PER IEC 62561 - 2018.

KEY PLAN:

NOTE:

ALL DIMENSIONS ARE IN METERS.  
ALL DIMENSIONS TO BE CHKD. AT SITE.  
DO NOT SCALE THE DRAWING  
IN THE EVENT OF ANY DISCREPANCIES OR DIFFERENCES BETWEEN ARCHITECT DRAWINGS, STRUCTURAL DRAWING AND SITE CONDITIONS, IMMEDIATE REFERENCE IS TO BE MADE TO THE ARCHITECT PRIOR TO THE EXECUTION OF WORK AT THE SITE.

ARCHITECTS & EP CONSTRUCTION:

**Taamaesek Engineering Consortium**  
New no. 5, Old no.2a, Bishop Wallers Avenue west, Mylapore, Chennai - 600 004. Ph:044-24671157/1139. Fax : 044-24672237. url:www.taamaesek.com e-mail: info@taamaesek.com

CLIENT:

Indian bank .

PROJECT:

Proposed Residential development for indian bank Musiri Subramaniam Salai

DRAWING STAGE: INFORMATION COPY

DRAWN BY : PS  
CHECKED BY: AK  
SCALE : 1:1000  
DATE : 19.09.2024

NORTH  
SHEET SIZE  
A2

DRAWING TITLE:

LIGHTNING PROTECTION SYSTEM-1

Drawing number: TMA/292/IB/ELE & ELE/EL-14

Project code number Project name Stage of Construction Type of Drawing Drawing number Revision

TMA-292 IB IFC ELECTRICAL ELE-14 R1

2MTR. VERTICAL AIR TERMINAL (AXIS MAKE TYPE ATP2018P)

8MM DIA ALUMINIUM ROUND CONDUCTOR (AXIS MAKE TYPE BARH08)

TEST JOINT (AXIS MAKE TYPE RFC0825P)

EARTH PIT (AXIS MAKE TYPE CBR2030PUL)

LEGEND

|                                          |            |
|------------------------------------------|------------|
| 8MM ALUMINIUM CONDUCTOR - TERRACE        | BARH08     |
| 25X6MM GI STRIP                          |            |
| 8MM ALUMINIUM CONDUCTOR - DOWN CONDUCTOR | BARH08     |
| SS CROSS CONNECTOR                       | SSQ0810P   |
| 2MTR VERTICAL AIR TERMINAL               | ATP2018P   |
| TEST JOINT                               | RFC0825P   |
| EARTHING                                 | CBR2030PUL |

CONDUCTOR HOLDER @EVERY 1MTR ON TERRACE

Disconnecting Clamp For Conductor dia 8-10mm

Parallel Connection clamp for round conductor dia 8-10mm

TYPICAL EXTERNAL LIGHTNING PROTECTION SYSTEM

CROSS CONNECTOR

MAINTENANCE FREE EARTHING

Expansion Piece with cross connector

DCSR0810

RFC0825P

SPG0810



SSQ0810P

CBR2030PUL

EXP008

8 7 6 5 4 3 2 1



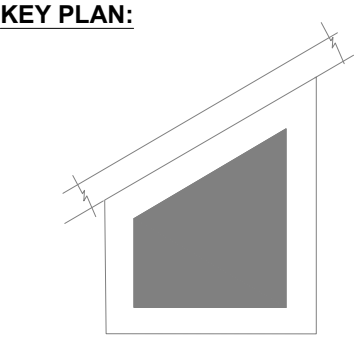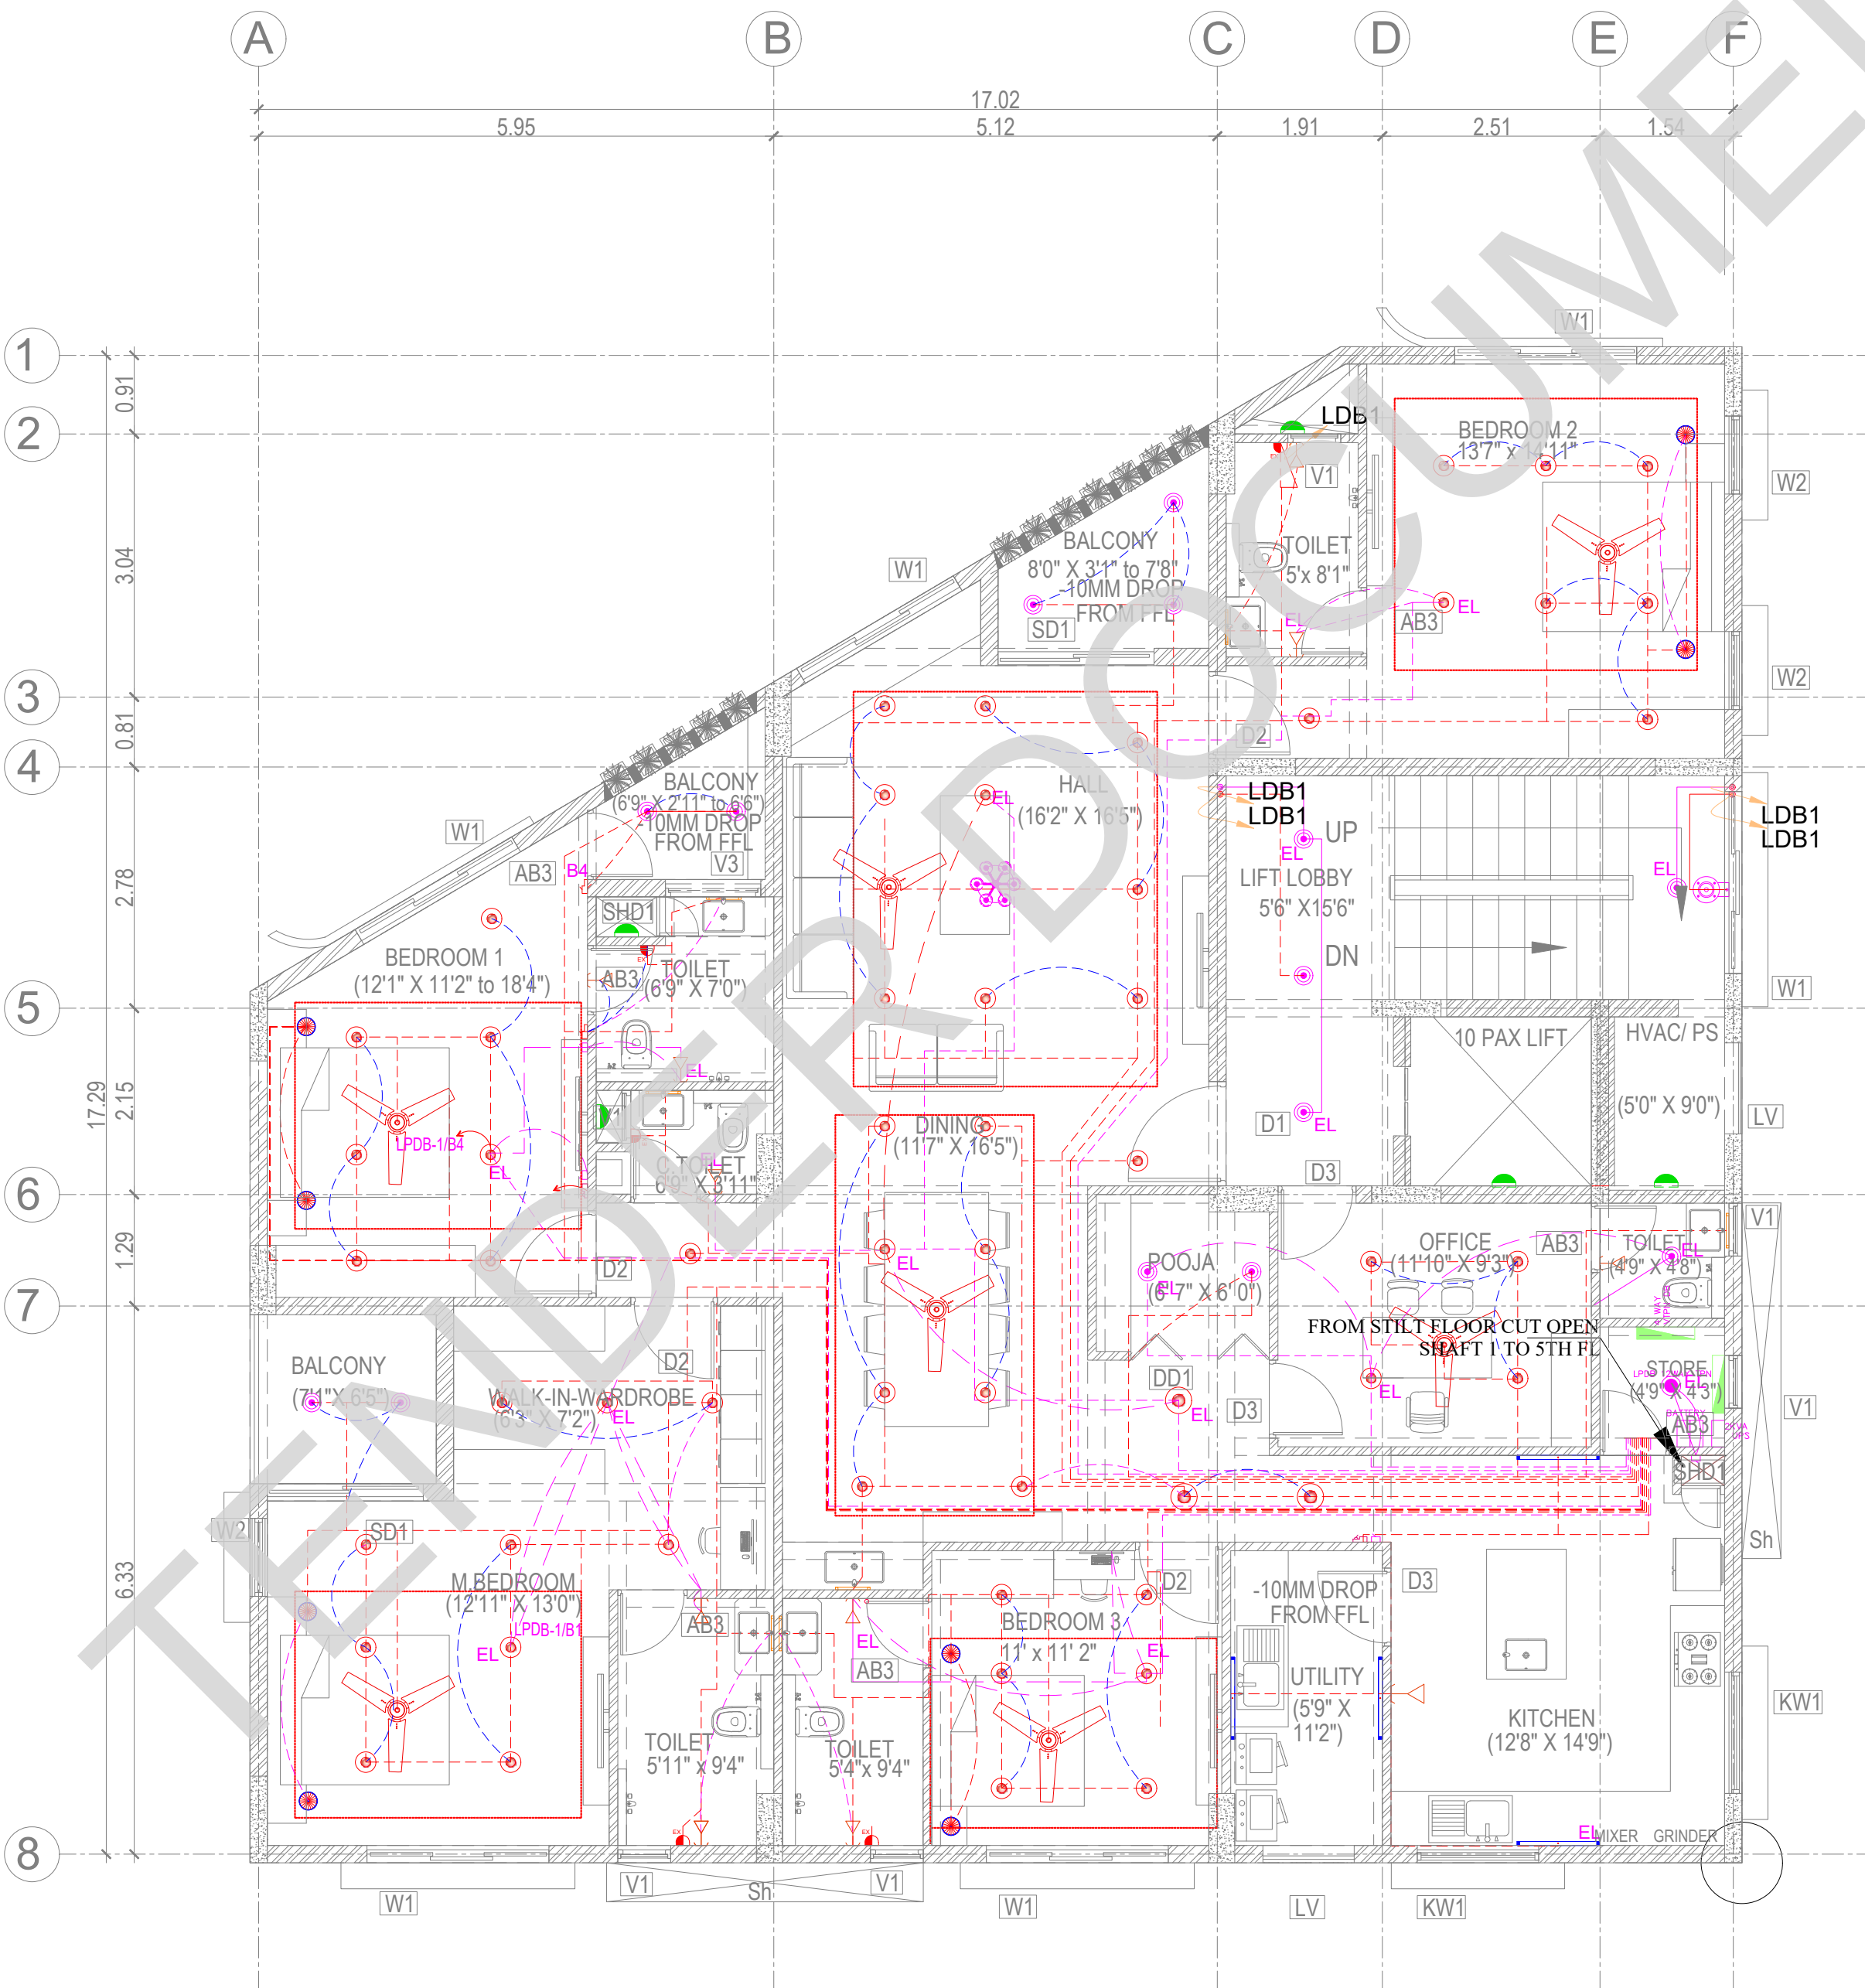

| LEGENDS: |                                         |
|----------|-----------------------------------------|
| SYMBOL   | DESCRIPTION                             |
|          | Bell indicator                          |
|          | Bell push                               |
|          | 1200 & 900mm dia Ceiling fan            |
|          | Ceiling light                           |
|          | Bulkhead light                          |
|          | Mirror light at 1950mm lvl              |
|          | Suspended Bed Room Light                |
|          | Linear Light 40W                        |
|          | 18W Recessed Light                      |
|          | 18W Surface Light                       |
|          | Wall Light                              |
|          | Switch box for all points at 1350mm lvl |

| ABBREVIATIONS: |                  |
|----------------|------------------|
| ES -           | ELECTRICAL SHAFT |
| PS -           | PLUMBING SHAFT   |
| AC -           | AIR CONDITIONING |
| FS -           | FIRE SHAFT       |
| TS -           | TELEPHONE SHAFT  |

| REVISION |      |             |
|----------|------|-------------|
| NO.      | DATE | DESCRIPTION |
|          |      |             |
|          |      |             |
|          |      |             |
|          |      |             |

NOTE:  
ALL DIMENSIONS ARE IN METERS.  
ALL DIMENSIONS TO BE CHKD. AT SITE.  
DO NOT SCALE THE DRAWING  
IN THE EVENT OF ANY DISCREPANCIES OR DIFFERENCES BETWEEN  
ARCHITECT DRAWINGS, STRUCTURAL DRAWING AND SITE CONDITIONS,  
IMMEDIATE REFERENCE IS TO BE MADE TO THE ARCHITECT PRIOR TO THE  
EXECUTION OF WORK AT THE SITE.

**ARCHITECTS & EP CONSTRUCTION:**



**Taamaesek Engineering Consortium**  
New no. 5, Old no.2a, Bishop Wallers  
Avenue west, Mylapore,  
Chennai - 600 004. Ph:044-24671157/1139.  
Fax : 044-24672237.  
url:www.taamaesek.com  
e-mail: info@taamaesek.com

**CLIENT:**




**Indian Bank**  
M/s. INDIAN BANK  
254-260, INDIAN BANK CORPORATE OFFICE,  
AVVAI SHANMUGAM SALAI, ROYAPETTAH, CHENNAI - 4.

**PROJECT:**  
Tender ID: CO-EST-TNDR-MBG-001-2023-24  
PROPOSED CONSTRUCTION OF RESIDENTIAL BUILDING  
(Shift + 5 Floors) @MUSIRI SUBRAMANIAM SALAI, CHENNAI - 600 004.

| DRAWING STAGE: INFORMATION COPY |            |                                                                                       |                  |  |
|---------------------------------|------------|---------------------------------------------------------------------------------------|------------------|--|
| DRAWN BY :                      | PS         |  | SHEET SIZE<br>A2 |  |
| CHECKED BY :                    | AK         |                                                                                       |                  |  |
| SCALE :                         | 1:1000     |                                                                                       |                  |  |
| DATE :                          | 19.09.2024 |                                                                                       |                  |  |

**DRAWING TITLE:**  
TYPICAL FLOOR LIGHTING LAYOUT


| Drawing number: TMA/292/1B/ELE & ELV/EL-08 |              |                       |                 |                |          |
|--------------------------------------------|--------------|-----------------------|-----------------|----------------|----------|
| Project code number                        | Project name | Stage of Construction | Type of Drawing | Drawing number | Revision |
| TMA-292                                    | IB           | IFC                   | ELECTRICAL      | EL-08          | R1       |

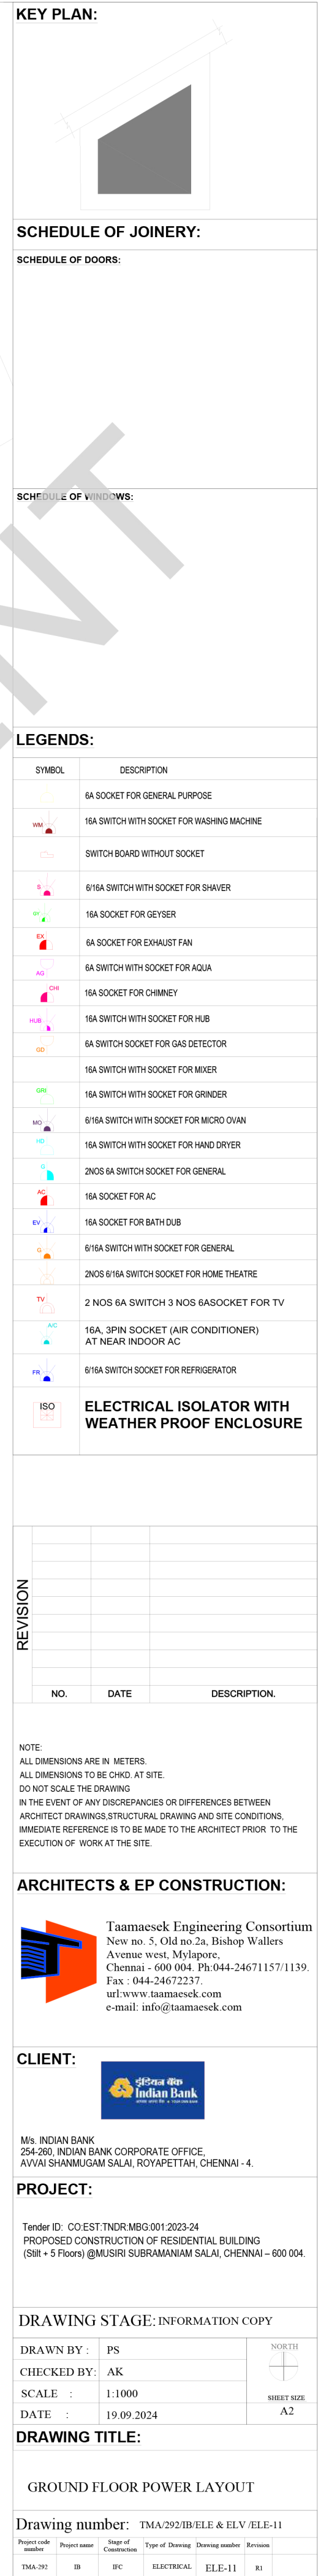

|          |      |              |  |
|----------|------|--------------|--|
| REVISION |      |              |  |
|          |      |              |  |
|          |      |              |  |
| NO.      | DATE | DESCRIPTION. |  |

NOTE:  
ALL DIMENSIONS ARE IN METERS.  
ALL DIMENSIONS TO BE CHKD. AT SITE.  
DO NOT SCALE THE DRAWING  
IN THE EVENT OF ANY DISCREPANCIES OR DIFFERENCES BETWEEN  
ARCHITECT DRAWINGS, STRUCTURAL DRAWING AND SITE CONDITIONS,  
IMMEDIATE REFERENCE IS TO BE MADE TO THE ARCHITECT PRIOR TO THE  
EXECUTION OF WORK AT THE SITE.

## ARCHITECTS &amp; EP CONSTRUCTION:

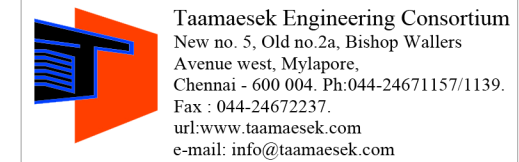

CLIENT: [REDACTED]



M/s. INDIAN BANK  
254-260, INDIAN BANK CORPORATE OFFICE,  
AVVAI SHANMUGAM SALAI, ROYAPETTAH, CHENNAI - 4.

## PROJECT:

Tender ID: CO:EST:TNR:MBG:001:2023-24  
PROPOSED CONSTRUCTION OF RESIDENTIAL BUILDING  
(Stilt + 5 Floors) @MUSIRI SUBRAMANIAM SALAI, CHENNAI – 600 004.

## DRAWING STAGE: INFORMATION COPY

|             |            |                                                                                                                  |
|-------------|------------|------------------------------------------------------------------------------------------------------------------|
| DRAWN BY :  | PS         | <br>NORTH<br><br>SHEET SIZE |
| CHECKED BY: | AK         |                                                                                                                  |
| SCALE :     | 1:1000     |                                                                                                                  |
| DATE :      | 19.09.2024 |                                                                                                                  |
|             |            | A2                                                                                                               |



**DRAWING TITLE:**

### GROUND FLOOR POWER LAYOUT

| Project code<br><i>number</i> | Project name | Stage of<br>Construction | Type of Drawing | Drawing number | Revision |
|-------------------------------|--------------|--------------------------|-----------------|----------------|----------|
| TMA-292                       | IB           | IFC                      | ELECTRICAL      | ELE-11         | R1       |





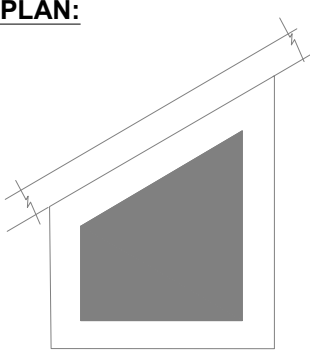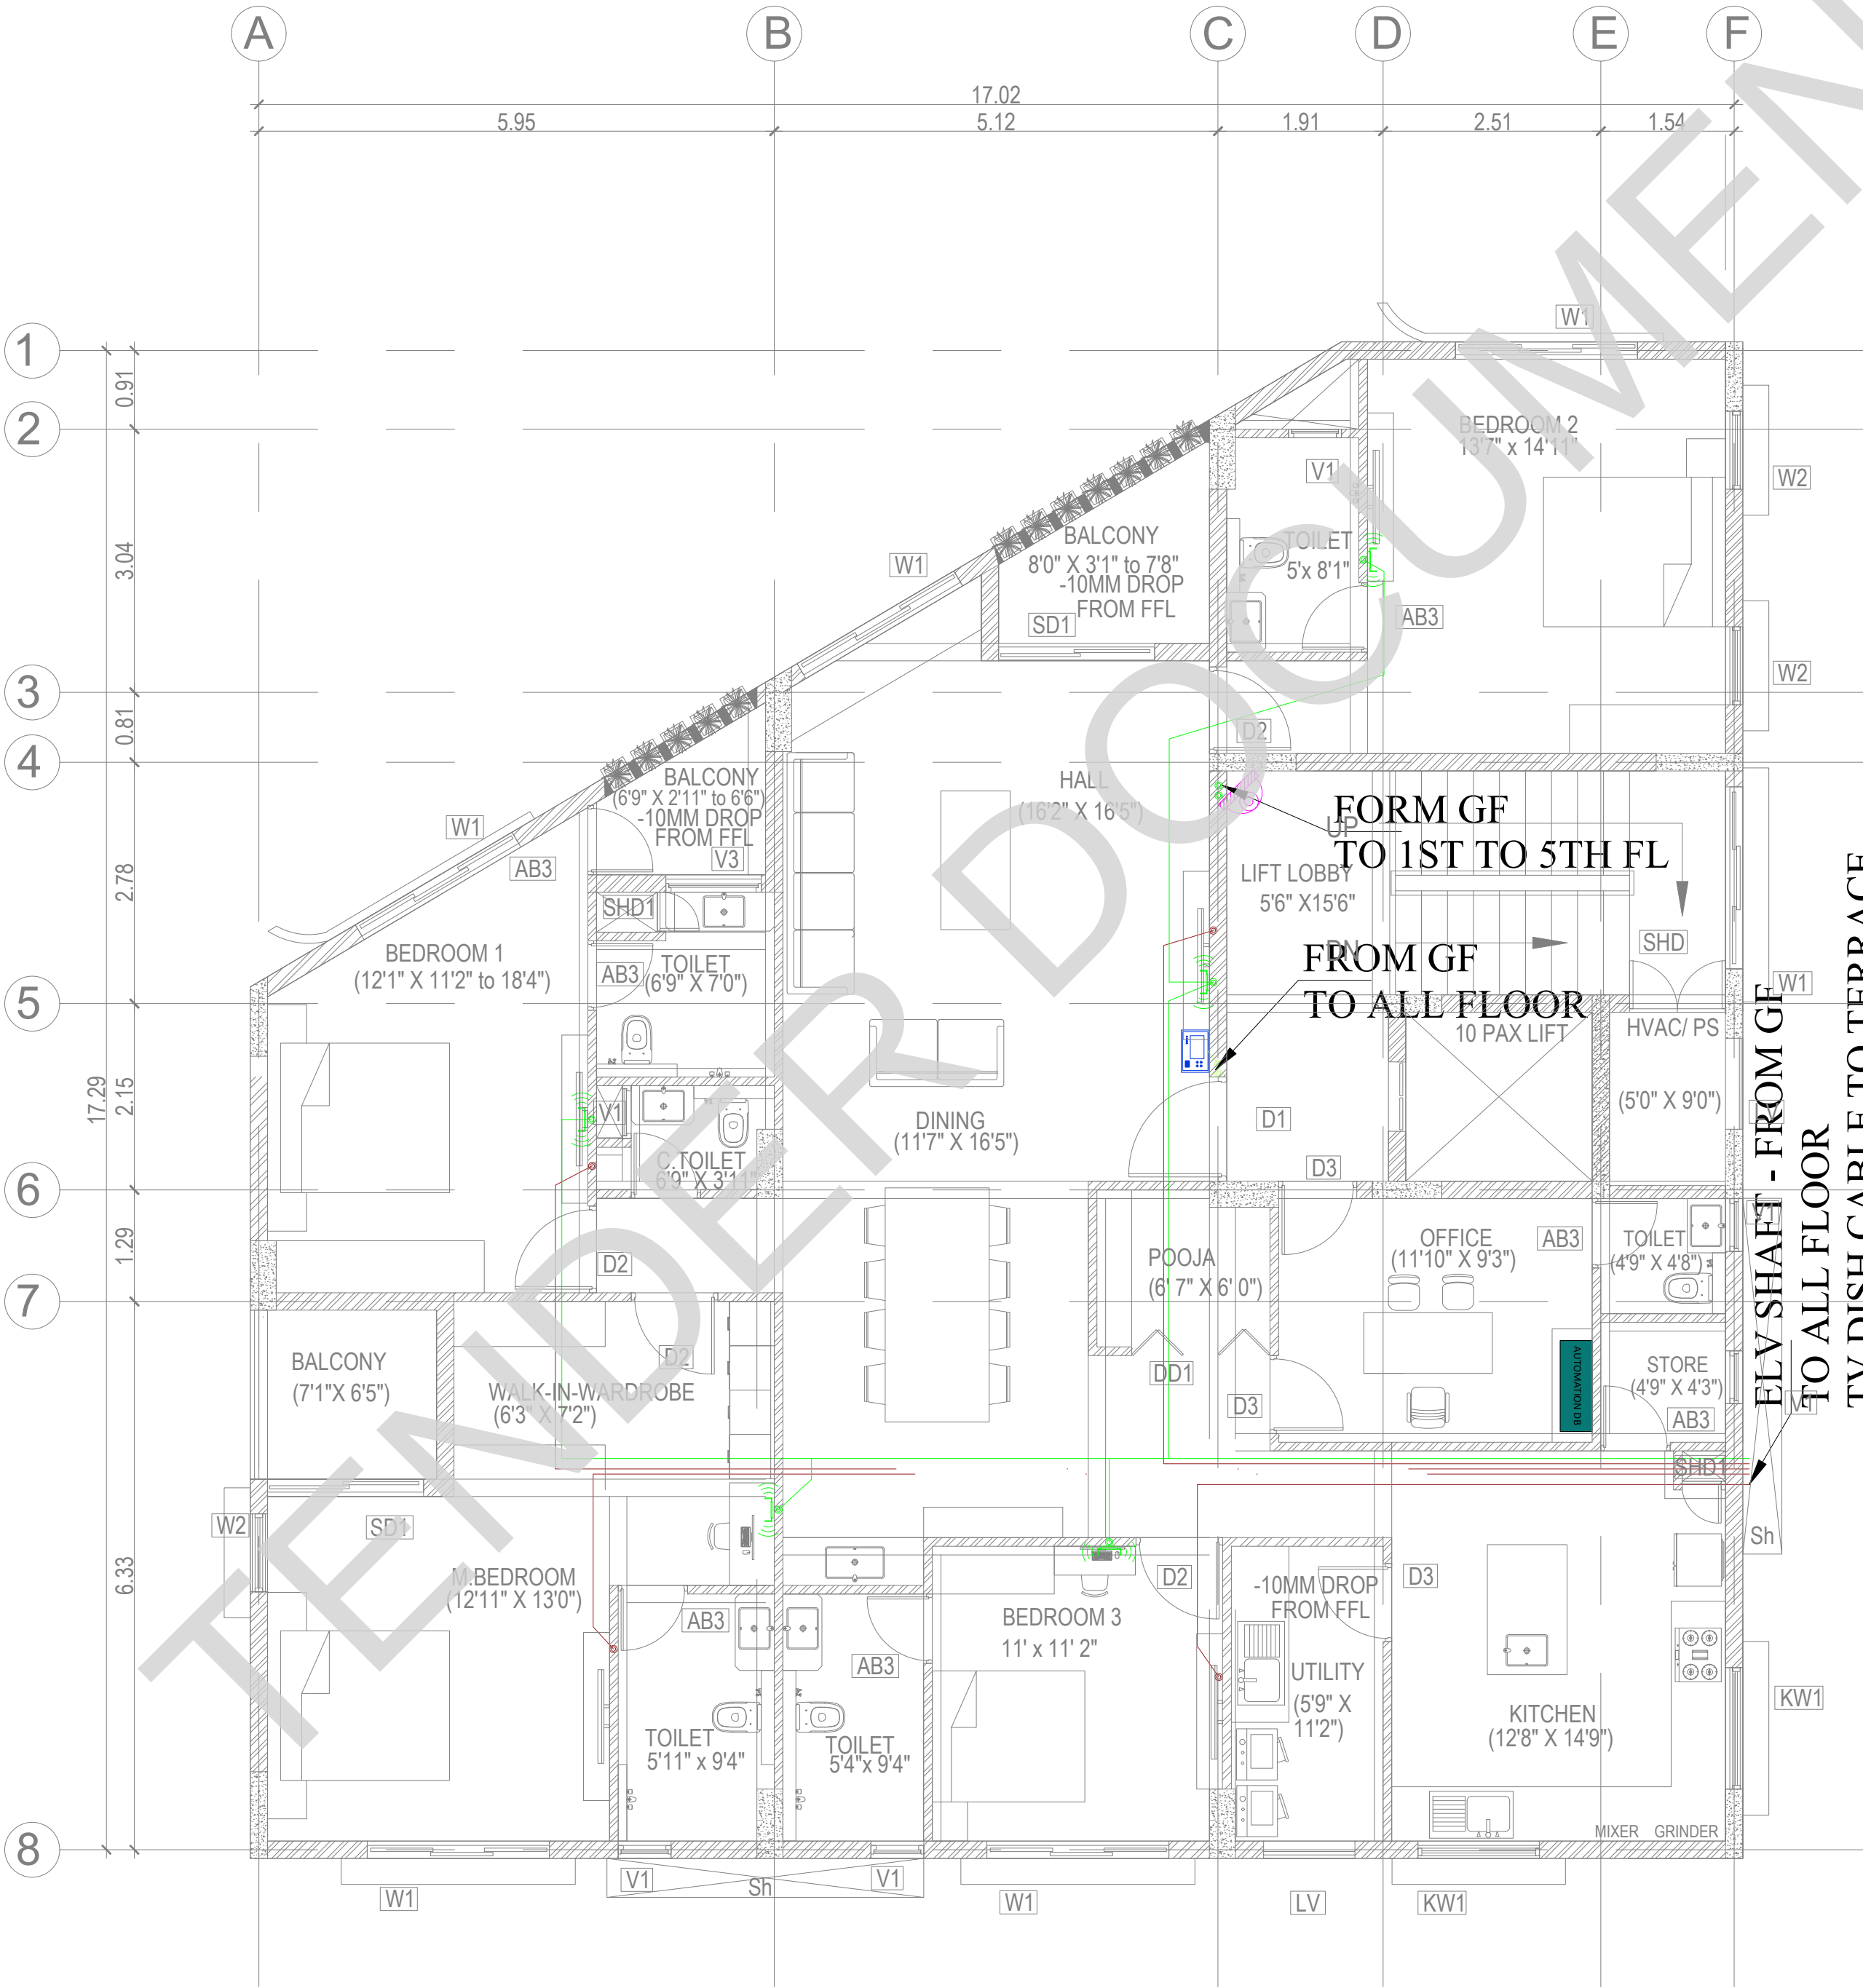

SCHEDULE OF JOINERY:

SCHEDULE OF DOORS:

SCHEDULE OF WINDOWS:

LEGENDS:

|  |                    |
|--|--------------------|
|  | DOMES CAMERA       |
|  | BULLET CAMERA      |
|  | VDP CAMERA INDOOR  |
|  | VDP CAMERA OUTDOOR |
|  | WIFI MODEM         |

ABBREVIATIONS:

|      |                  |
|------|------------------|
| ES - | ELECTRICAL SHAFT |
| PS - | PLUMBING SHAFT   |
| AC - | AIR CONDITIONING |
| FS - | FIRE SHAFT       |
| TS - | TELEPHONE SHAFT  |

NOTE:  
ALL DIMENSIONS ARE IN METERS.  
ALL DIMENSIONS TO BE CHKD. AT SITE.  
DO NOT SCALE THE DRAWING  
IN THE EVENT OF ANY DISCREPANCIES OR DIFFERENCES BETWEEN  
ARCHITECT DRAWINGS, STRUCTURAL DRAWING AND SITE CONDITIONS,  
IMMEDIATE REFERENCE IS TO BE MADE TO THE ARCHITECT PRIOR TO THE  
EXECUTION OF WORK AT THE SITE.

ARCHITECTS & EP CONSTRUCTION:

Taamaesek Engineering Consortium  
New no. 5, Old no.2a, Bishop Wallers  
Avenue west, Mylapore,  
Chennai - 600 004. Ph:044-24671157/1139.  
Fax : 044-24672237.  
url: www.taamaesek.com  
e-mail: info@taamaesek.com

CLIENT:



M/s. INDIAN BANK  
254-260, INDIAN BANK CORPORATE OFFICE,  
AVVAI SHANMUGAM SALAI, ROYAPETTAH, CHENNAI - 4.

PROJECT:

Tender ID: CO-EST-TNDR-MBG-001-2023-24  
PROPOSED CONSTRUCTION OF RESIDENTIAL BUILDING  
(Silt + 5 Floors) @MUSIRI SUBRAMANIAM SALAI, CHENNAI - 600 004.

DRAWING STAGE: INFORMATION COPY

|              |            |                               |
|--------------|------------|-------------------------------|
| DRAWN BY :   | PS         | <br>NORTH<br>SHEET SIZE<br>A2 |
| CHECKED BY : | AK         |                               |
| SCALE :      | 1:1000     |                               |
| DATE :       | 19.09.2024 |                               |


DRAWING TITLE:

TYPICAL FLOOR ELV LAYOUT

Drawing number: TMA/292/IB/EL & ELV /EL-03

| Project code number | Project name | Stage of Construction | Type of Drawing | Drawing number | Revision |
|---------------------|--------------|-----------------------|-----------------|----------------|----------|
| TMA-202             | IB           | IFC                   | ELECTRICAL      | ELV-03         | R1       |

KEY PLAN:

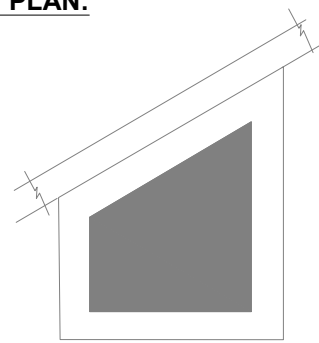

SCHEDULE OF JOINERY:

SCHEDULE OF DOORS:

SCHEDULE OF WINDOWS:

LEGENDS:

|  |                    |
|--|--------------------|
|  | DOMA CAMERA        |
|  | BULLET CAMERA      |
|  | VDP CAMERA INDOOR  |
|  | VDP CAMERA OUTDOOR |
|  | WIFI MODAM         |

ABBREVIATIONS:

|      |                  |
|------|------------------|
| ES - | ELECTRICAL SHAFT |
| PS - | PLUMBING SHAFT   |
| AC - | AIR CONDITIONING |
| FS - | FIRE SHAFT       |
| TS - | TELEPHONE SHAFT  |

REVISION

| NO. | DATE | DESCRIPTION. |
|-----|------|--------------|
|-----|------|--------------|

NOTE:  
ALL DIMENSIONS ARE IN METERS.  
ALL DIMENSIONS TO BE CHKD. AT SITE.  
DO NOT SCALE THE DRAWING  
IN THE EVENT OF ANY DISCREPANCIES OR DIFFERENCES BETWEEN  
ARCHITECT DRAWINGS, STRUCTURAL DRAWING AND SITE CONDITIONS,  
IMMEDIATE REFERENCE IS TO BE MADE TO THE ARCHITECT PRIOR TO THE  
EXECUTION OF WORK AT THE SITE.

ARCHITECTS & EP CONSTRUCTION:



**Taamaesek Engineering Consortium**  
New no. 5, Old no.2a, Bishop Wallers  
Avenue west, Mylapore,  
Chennai - 600 004. Ph:044-24671157/1139.  
Fax : 044-24672237.  
url:www.taamaesek.com  
e-mail: info@taamaesek.com

CLIENT:



M/s. INDIAN BANK  
254-260, INDIAN BANK CORPORATE OFFICE,  
AVVAI SHANMUGAM SALAI, ROYAPETTAH, CHENNAI - 4.

PROJECT:

Tender ID: CO.EST:TDR:MBG:001:2023-24  
PROPOSED CONSTRUCTION OF RESIDENTIAL BUILDING  
(Silt + 5 Floors) @MUSIRI SUBRAMANIAM SALAI, CHENNAI - 600 004.

DRAWING STAGE: INFORMATION COPY

|             |            |                                                                                                                        |
|-------------|------------|------------------------------------------------------------------------------------------------------------------------|
| DRAWN BY :  | PS         | <br>NORTH<br><br>SHEET SIZE<br>A2 |
| CHECKED BY: | AK         |                                                                                                                        |
| SCALE :     | 1:1000     |                                                                                                                        |
| DATE :      | 19.09.2024 |                                                                                                                        |

DRAWING TITLE:

BASEMENT FLOOR ELV LAYOUT

Drawing number: TMA/292/IB/ELV & EL /EL-01

| Project code number | Project name | Stage of Construction | Type of Drawing | Drawing number | Revision |
|---------------------|--------------|-----------------------|-----------------|----------------|----------|
| TMA-292             | IB           | IFC                   | ELECTRICAL      | ELV-1          | R1       |



**KEY PLAN:**

**LEGENDS:**

| SYMBOL | DESCRIPTION                             |
|--------|-----------------------------------------|
|        | Bell indicator                          |
|        | Bell push                               |
|        | 1200 & 900mm dia Ceiling fan            |
|        | Ceiling light                           |
|        | Bulkhead light                          |
|        | Mirror light at 1950mm lvl              |
|        | Bedroom Bed Room Light                  |
|        | Ceiling Light 40W                       |
|        | 18W Recessed Light                      |
|        | 18W Surface Light                       |
|        | Wall Light                              |
|        | Switch box for all points at 1350mm lvl |

**ABBREVIATIONS:**

|      |                  |
|------|------------------|
| ES - | ELECTRICAL SHAFT |
| PS - | PLUMBING SHAFT   |
| AC - | AIR CONDITIONING |
| FS - | FIRE SHAFT       |
| TS - | TELEPHONE SHAFT  |

| NO. | DATE | DESCRIPTION. |
|-----|------|--------------|
|     |      |              |

NOTE:  
ALL DIMENSIONS ARE IN METERS.  
ALL DIMENSIONS TO BE CHKD. AT SITE.  
DO NOT SCALE THE DRAWING  
IN THE EVENT OF ANY DISCREPANCIES OR DIFFERENCES BETWEEN  
ARCHITECT DRAWINGS, STRUCTURAL DRAWING AND SITE CONDITIONS,  
IMMEDIATE REFERENCE IS TO BE MADE TO THE ARCHITECT PRIOR TO THE  
EXECUTION OF WORK AT THE SITE.

**ARCHITECTS & EP CONSTRUCTION:**

Taamaesek Engineering Consortium  
New no. 5, Old no.2a, Bishop Wallers  
Avenue west, Mylapore,  
Chennai - 600 004. Ph:044-24671157/1139.  
Fax : 044-24672237.  
url:www.taamaesek.com  
e-mail: info@taamaesek.com

**CLIENT:**

M/s. INDIAN BANK  
254-280, INDIAN BANK CORPORATE OFFICE,  
AVVAI SHANMUGAM SALAI, ROYAPETTAH, CHENNAI - 4.

**PROJECT:**

Tender ID: CO-EST-TNDR-MBG-001-2023-24  
PROPOSED CONSTRUCTION OF RESIDENTIAL BUILDING  
(Still + 5 Floors) @MUSIRI SUBRAMANIAM SALAI, CHENNAI – 600 004.

**DRAWING STAGE: INFORMATION COPY**

|              |            |  |
|--------------|------------|--|
| DRAWN BY :   | PS         |  |
| CHECKED BY : | AK         |  |
| SCALE :      | 1:1000     |  |
| DATE :       | 19.09.2024 |  |

**DRAWING TITLE:**

GROUND FLOOR LIGHTING LAYOUT

Drawing number: TMA/292/IB/ELE & ELV /EL-07

| Project code number | Project name | Stage of Construction | Type of Drawing | Drawing number | Revision |
|---------------------|--------------|-----------------------|-----------------|----------------|----------|
| TMA-292             | IB           | IFC                   | ELECTRICAL      | EL-07          | R1       |