


 





LEGEND		NO.
	WALL FAN 400MM METAL BODY	01
	2'X2' LED PANEL	04
	LED PANEL 15 WATT	24
	36W LED PATTI	06
	(A.C.POINT)	03
	300MM EXHAUST FAN	02



## PROPOSED ELECTRICAL LAYOUT PLAN

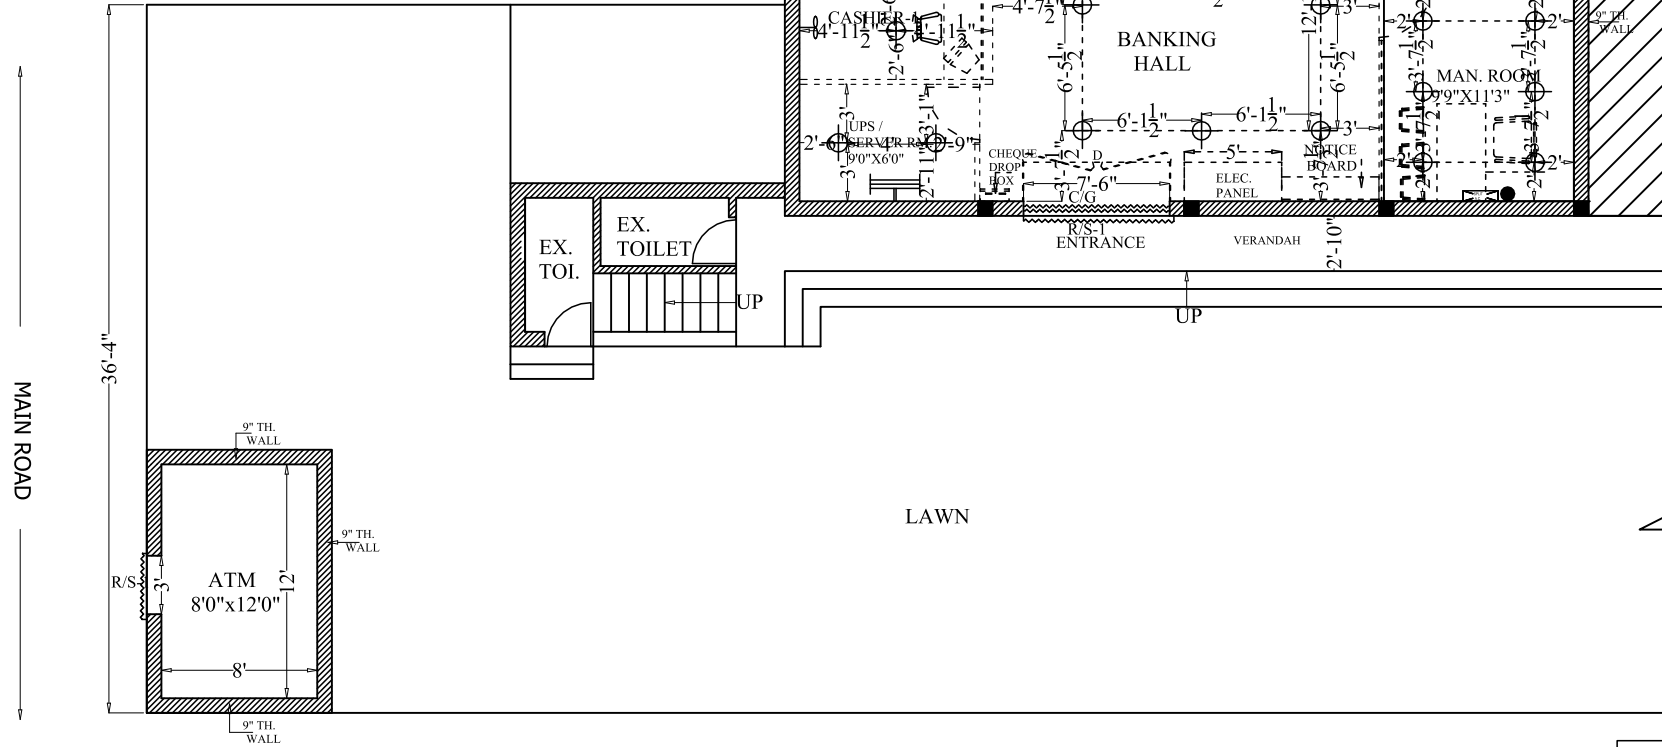

**Project :** PROPOSED INTERIOR LAYOUT PLAN FOR  
INDIAN BANK AT THARWAI BRANCH  
PRAYAGRAJ

**Zone:** PRAYGRAJ U.P.

**DRAWING TITLE:**  
ELECTRICAL LAYOUT PLAN

**DATE**  
30-04-2026

**SCALE**

**DRAWING NO.- 03**

**CONSULTANT :-**

**ARCONS**  
AR. AKHILESHWAR SINGH

OFF: LOTUS APARTMENT, TASHKAND MARG, CIVIL LINES, ALLD.